

1) 66" GONDOLA RINS HAVE 22" DEEP BASE DECKS W/ 1) SHEET
 PEGBOARD EACH SIDE, 46" X 56" PER 4' SECTION, END CAPS FROM
 GONDOLA WALL-CASE SECTIONS W/ 48" 22" BASE DECKS, 60" UPRIGHTS
 W/ 48" 22" SHEET PEGBOARD, 46" X 56" EACH SIDE W/ 2) BASE END TRIMS &
 2) UPRIGHT END TRIMS.
 2) 66" GONDOLA RINS HAVE 22" DEEP BASE DECKS W/ 1) SHEET
 PEGBOARD EACH SIDE, 46" X 58" PER 4' SECTION, END CAPS FROM
 GONDOLA WALL-CASE SECTIONS W/ 48" 22" BASE DECKS, 60" UPRIGHTS
 W/ 48" 22" SHEET PEGBOARD, 46" X 58" EACH SIDE W/ 2) BASE END TRIMS &
 2) UPRIGHT END TRIMS.
 3) 72" GONDOLA RINS HAVE 22" DEEP BASE DECKS W/ 1) SHEET
 PEGBOARD EACH SIDE, 46" X 64" PER 4' SECTION, END CAPS FROM
 GONDOLA WALL-CASE SECTIONS W/ 48" 22" BASE DECKS, 84" UPRIGHTS
 W/ 48" 22" SHEET PEGBOARD, 46" X 64" EACH SIDE W/ 2) BASE END TRIMS &
 2) UPRIGHT END TRIMS.
 4) 84" GONDOLA RINS HAVE 22" DEEP BASE DECKS W/ 2) SHEETS
 PEGBOARD EACH SIDE, (1) 46" X 40" & (1) 46" X 36" PER 4' SECTION,
 END CAPS FROM GONDOLA WALL-CASE SECTIONS W/ 48" 22" BASE DECKS,
 84" UPRIGHTS W/ 48" 22" SHEET PEGBOARD, 46" X 40" & (1) 46" X 36"
 EACH SIDE, 2) BASE END TRIMS, & 2) UPRIGHT END TRIMS.
 5) 84" WALLCASE RINS HAVE 25" DEEP BASE DECKS W/ 2) SHEETS
 PEGBOARD ONE SIDE, 46" X 40" & (1) 46" X 36" PER 4' SECTION.
 6) 66" GONDOLA RINS THAT HAVE THIS SYMBOL GETS 4 DUPLEX
 OUTLETS WHERE NOTED ON THE GONDOLA.



HARDWARE NOTES

EACH TO RECEIVE:

1-1/2 PAIR BUTTS, BB1279, 4-1/2 X 4-1/2 , NRP, US26D	HAGER
1 EACH THRESHOLD 887 X REQUIRED LENGTH	NATIONAL GUARD
1 SET WEATHER-STRIPPING	ZERO
1 EACH DRIP CAP	RE: CONST. DOC'
** 1 EACH PANIC DEVICE ECL-230 D	DETEX
** 1 EACH PANIC DEVICE ECL-435k FOR DOUBLE DOORS	DETEX
1 CLOSER, 1461, AL	LCN

EACH TO RECEIVE:
FULLY AUTOMATIC OPERATORS
* KEYS CYLINDER EXTERIOR FA-C977-626
WITH THUMB TURN INTERIOR M.S. ILCO# 7161262-26D
THRESHOLD ADA APPROVED
MANUFACTURER STANDARD OFFSET PIVOTS
INSTALL ALUM. CART GUARDS ON EXTERIOR & INTERIOR OF DOOR

EACH TO RECEIVE:

1-1/2 PAIR BUTTS, BB1279, 4-1/2 X 4-1/2 , NRP, US26D	HAGER
1 FLOOR STOP 438B 26D	IVESS
1 PUSH PLATE & PULL HANDLE	
1 CLOSER, 1461, AL	LCN

EACH TO RECEIVE:

1-1/2 PAIR BUTTS, BB1279, 4-1/2 X 4-1/2, NRP, US26D	HAGER
* 1 STOREROOM SET, M12SR1C-26D	AKRON
1 FLOOR STOP 4388 26D	IVESS
1 CLOSER, 1461, AL	LCN

EACH TO RECEIVE:

* PUSH BAR & FULL HANDLE	
* KEYS CYLINDER EXTERIOR FA-C977-026	
* KEYS THUMB TURN INTERIOR M.S. ILCOM 7161TK2-26D	ARROW
1 CLOSER, 1461, AL	LCN
THRESHOLD ADA APPROVED	NATIONAL GARD
MANUFACTURER STANDARD OFFSET PIVOTS	
INSTALL ALUM. CART GUARDS ON EXTERIOR & INTERIOR OF DOOR	
* DUMMY MORTISE CYLINDER ILCOM 7160DC-26D	
INTERIOR THUMBTURN ILCOM 7161 TK2-26D FOR ALL OTHER OUTSIDE DOORS.	

EACH TO RECEIVE:

1-1/2 PAIR BUTTS, BB1279, 4-1/2 X 4-1/2 , NRP, US260	HAGER
* 1- ENTRANCE LEVERSET #MISRIC-26D	SCHLAGE
1 FLOOR STOP 438B 26D	IVISS



**** ADDITIONAL NOTES:**

- BASS LOCK WILL PROVIDE PADLOCKS FOR OVERHEAD DOORS AND ROOFHATCH AND ONE (1) SPARE LOCK.

EMERGENCY LIGHT WITH BATTERY PICK-UP.
 EMERGENCY LIGHT EXIT SIGN COMBO.

COLOR	PART NO.	
BROWN	SW2600	SHERWIN WILLIAMS A100 SEMI-GLOSS
TAN	SW2060	SHERWIN WILLIAMS A100 SEMI-GLOSS
WHITE		SHERWIN WILLIAMS A100 SEMI-GLOSS

ROOM & OR AREA	FLOOR	BASE	WALLS	CEILING		REMARKS
				MATERIAL	HEIGHT	
				#1-#82 - CLOUD WHITE FTE APPROX #100 - SLEIGH	THE BASE, ARMSTRONG, G1	

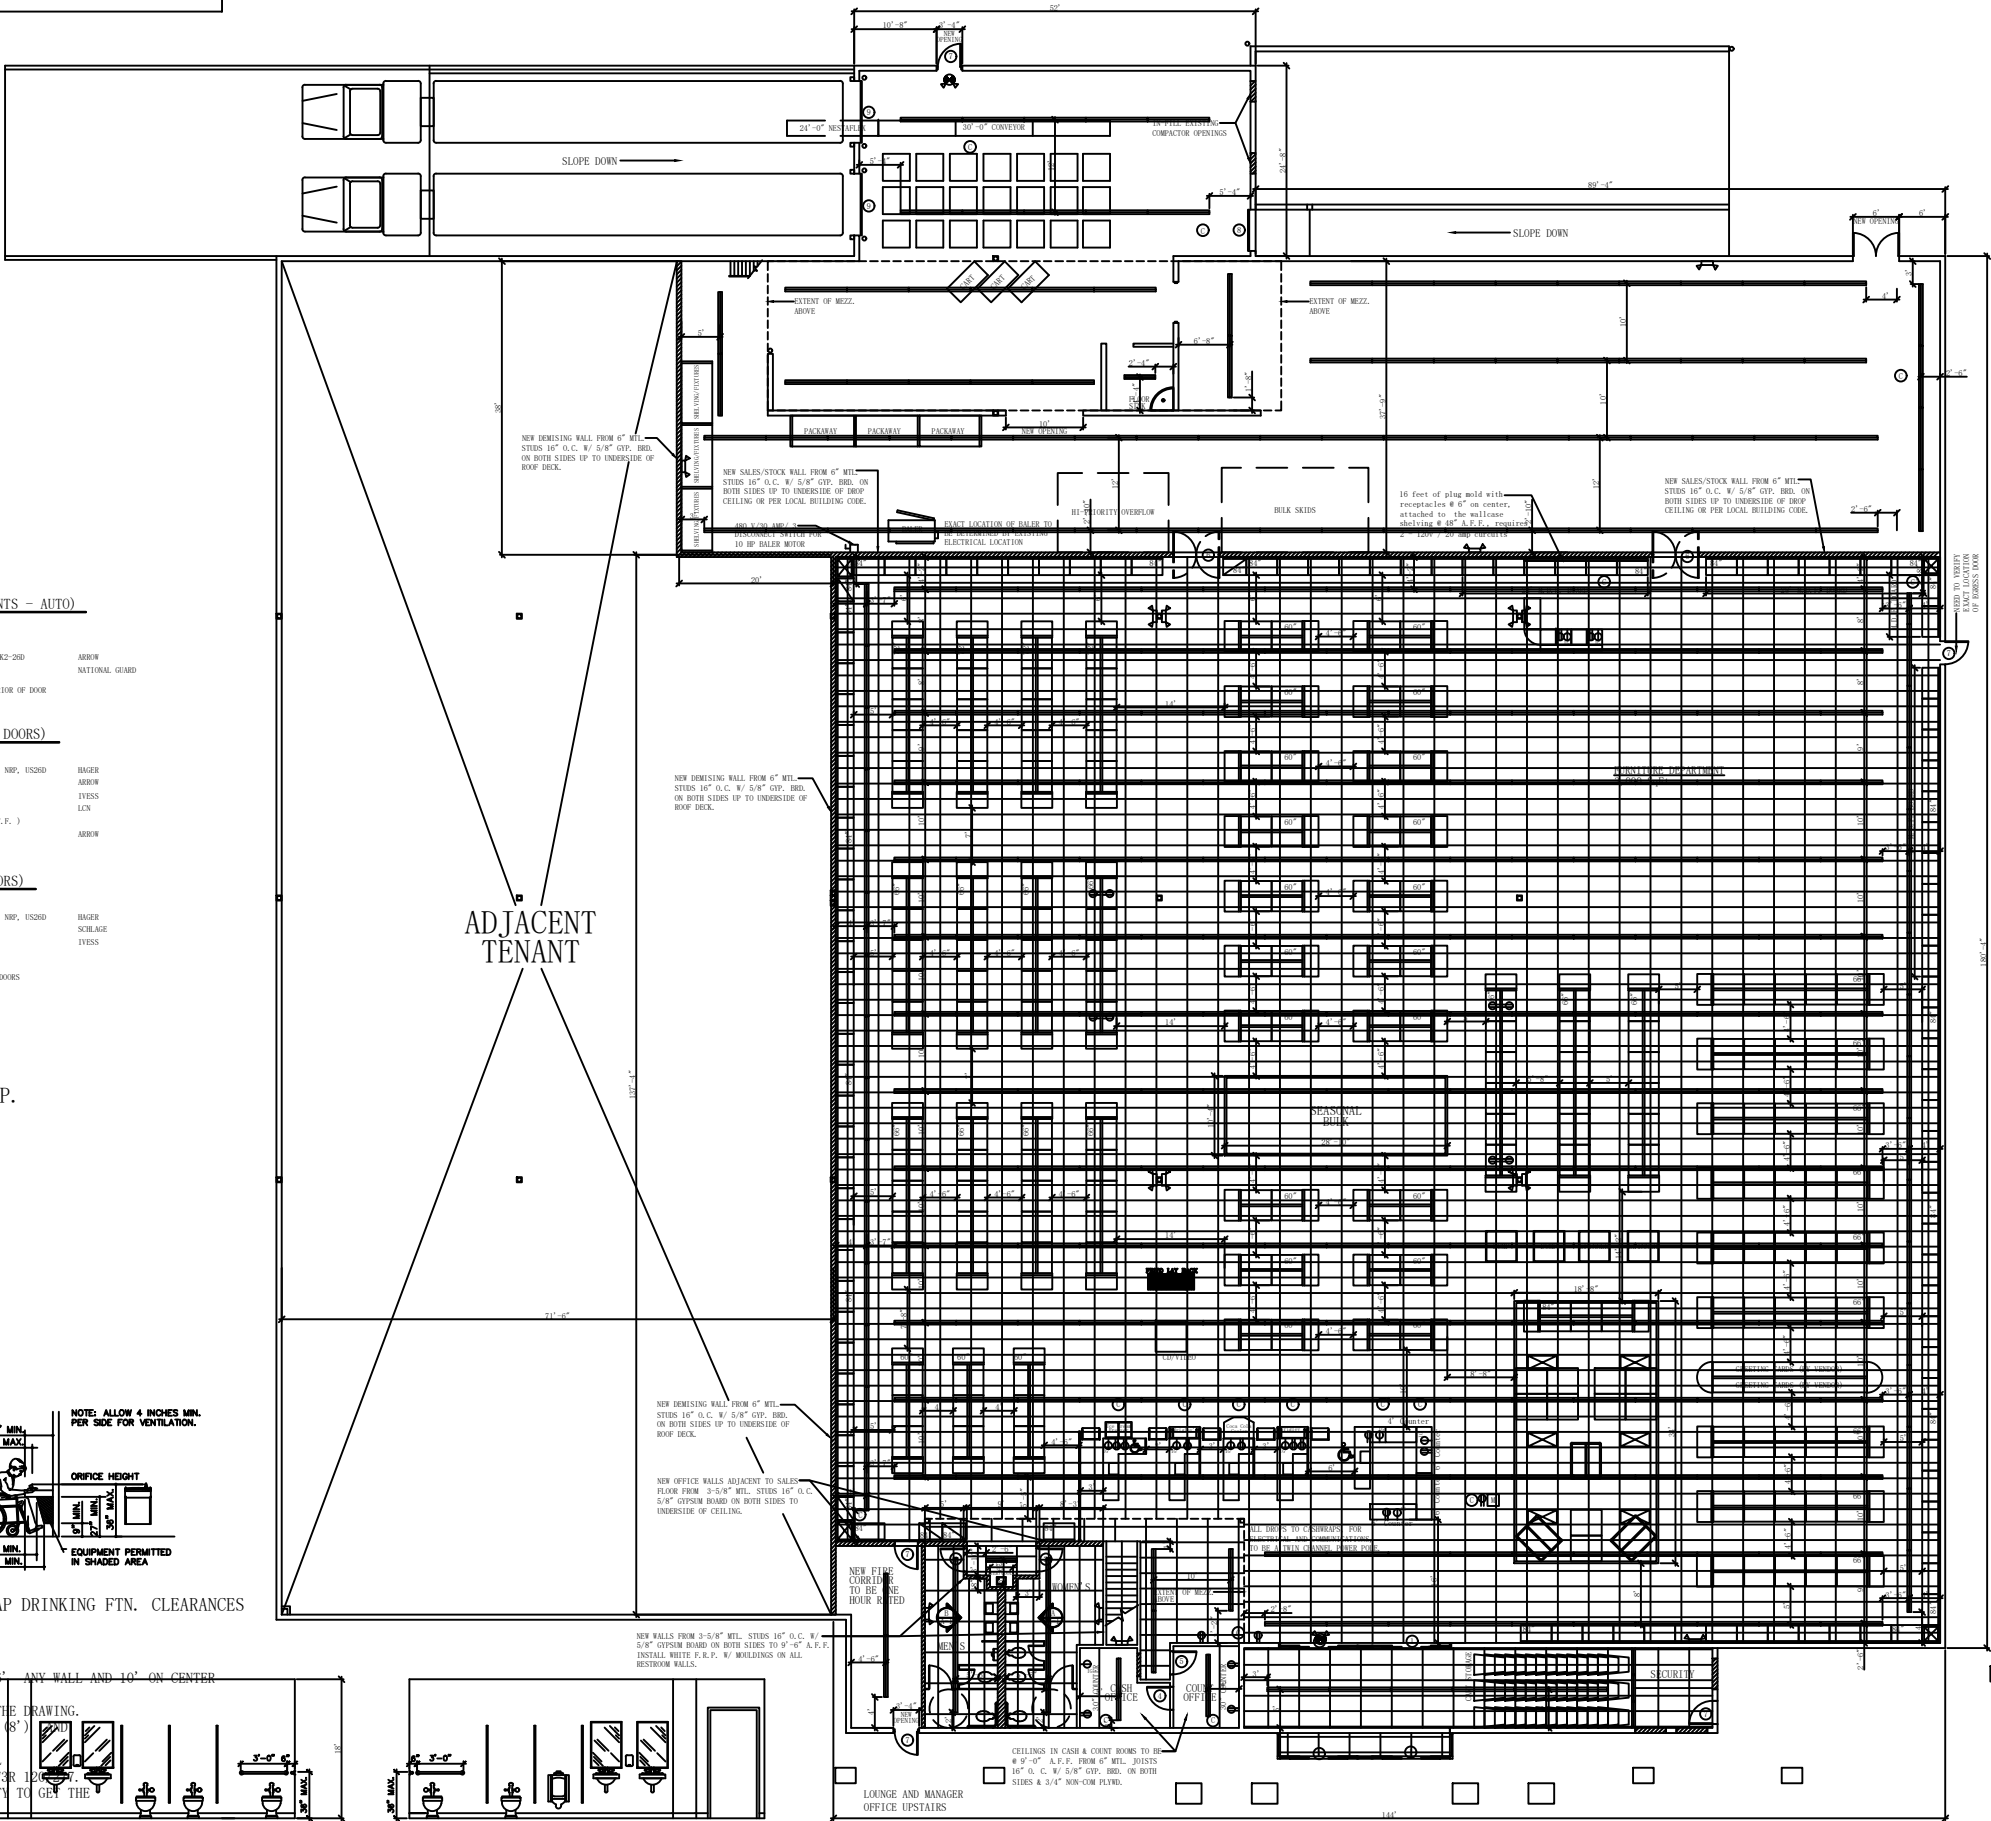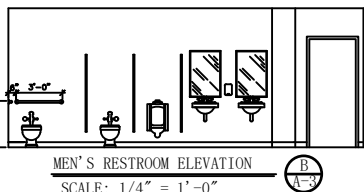[illegible]

BIG LOTS STORES, INC.
STORE PLANNING DEPT.
300 PHILLIPI ROAD
COLUMBUS, OHIO 43228
PHONE: (614) 278-6800

BIG LOTS STORE #4485
SHOPPING CENTER
90th SOUTH & 40th WEST
WEST JORDAN, UT 84008


SCALE:	DATE:
1" = 1'-0"	12 - 17 - 09


**SQUARE
FOOTAGE:
SALES: 20,220
(INCLUDES FURNITURE DEPT.)
TOTAL: 29,200**

BIG LOTS!
BIG LOTS STORES, INC.

SHEET:
W-2

 FIXTURE NOTES:

- 1) 60" GONDOLA RUNS HAVE 22" DEEP BASE DECKS W/ (1) SHEET PEGRBOARD EACH SIDE @ 46" x 52" PER 4" SECTION, END CAPS FROM GONDOLA WALL-CASE SECTIONS W/ 48" x 22" BASE DECKS, 60" UPRIGHTS W/ (2) SHEETS PEGRBOARD 46" x 52" EACH SIDE W/ (2) BASE END TRIMS & (2) UPRIGHT END TRIMS.
- 2) 66" GONDOLA RUNS HAVE 22" DEEP BASE DECKS W/ (1) SHEET PEGRBOARD EACH SIDE @ 46" x 58" PER 4" SECTION, END CAPS FROM GONDOLA WALLCASE SECTIONS W/ 48" x 22" BASE DECKS, 66" UPRIGHTS W/ (2) SHEETS OF PEGRBOARD 48" x 58" W/ (2) BASE END TRIMS & (2) UPRIGHT END TRIMS.
- 3) 72" GONDOLA RUNS HAVE 22" DEEP BASE DECKS W/ (1) SHEET PEGRBOARD EACH SIDE @ 46" x 64" PER 4" SECTION, END CAPS FROM GONDOLA WALLCASE SECTIONS W/ 48" x 22" BASE DECKS, 84" UPRIGHTS W/ (2) SHEETS OF PEGRBOARD 46" x 64" W/ (2) BASE END TRIMS & (2) UPRIGHT END TRIMS.
- 4) 84" GONDOLA RUNS HAVE 22" DEEP BASE DECKS W/ (2) SHEETS PEGRBOARD EACH SIDE, (1) 46" x 40" & (1) 46" x 36" PER 4" SECTION, END CAPS FROM GONDOLA WALLCASE SECTIONS W/ 48" x 22" BASE DECKS, 84" UPRIGHTS W/ (2) SHEETS PEGRBOARD, (1) 46" x 36" & (1) 46" x 40" EACH SIDE, (2) BASE END TRIMS, & (2) UPRIGHT END TRIMS.
- 5) 84" WALLCASE RUNS HAVE 25" DEEP BASE DECKS W/ (2) SHEETS PEGRBOARD ONE SIDE @ 46" x 40" & (1) @ 46" x 36" PER 4" SECTION.
- 6) 66" GONDOLA RUNS THAT HAVE THIS  SYMBOL GETS 4 DUPLEX OUTLETS WHERE NOTED ON THE GONDOLA.

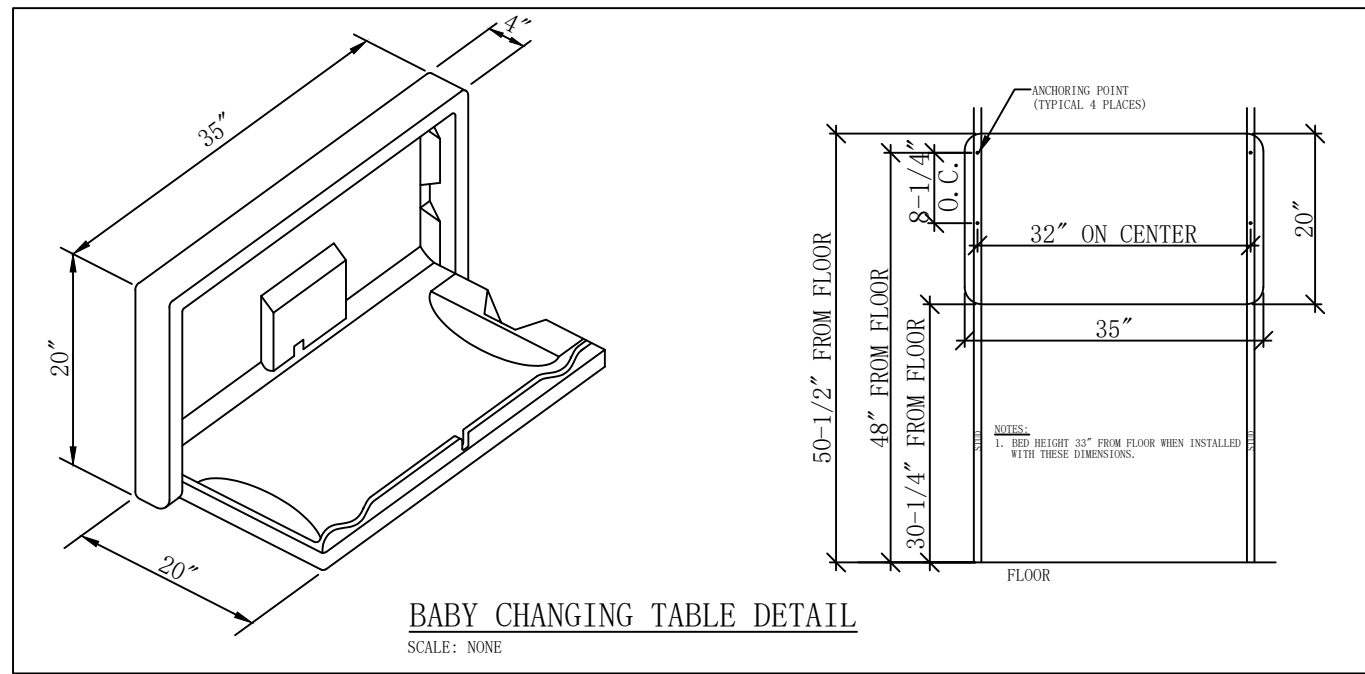

ELECTRICAL LEGEND

-  DUPLEX CONVENIENCE RECEPTACLE OUTLET
-  ISOLATED GROUND RECEPTACLE TO BE NEMA L5-15R
-  LIGHT SWITCH
-  COAX CABLE FOR CCTV
-  COAX CABLE TERMINATION POINT
-  J BOX FOR SIGN
-  CCTV MONITOR

NOTE:
ALL DROPS TO CASHWRAPS, FOR ELECTRICAL AND COMMUNICATIONS TO BE A TWIN CHANNEL POWER POLE.

DOOR SCHEDULE

SYMBOL	SIZE	DESCRIPTION	FRAME TYPE	HARDWARE	DOOR FINISH	REMARKS
①	PR. 2'-0" x 7'-0"	ALUMINUM/GLASS (SLIDING)	ALUM.	PTM	4	NATURAL ALUMINUM
②	3'-0" x 6'-8"	H. C. METAL OR S. C. WOOD	METAL	P-3	2	P-3 P-4
③	3'-0" x 6'-8"	H. C. METAL OR S. C. WOOD	METAL	P-3	6	P-3 P-4
④	3'-0" x 6'-8"	H. C. METAL	METAL	P-3	5	P-3 P-4
⑤	3'-0" x 6'-8"	H. C. METAL OR S. C. WOOD	METAL	P-3	5	P-3 P-4
⑥	PR. 2'-0" x 7'-0"	WOOD-SETTING STOCKROOM DOORS	CASID			BROWN
⑦	3'-0" x 7'-0"	METAL EXTERIOR DOOR	METAL	P-2	1	P-2 P-4
⑧	3'-4" x 8'-0"	METAL OVERHEAD DOOR	METAL	P-3	1	P-3 P-4
⑨	10'-0" x 10'-0"	METAL OVERHEAD DOOR	METAL	P-3	1	P-3 P-4

HARDWARE NOTES

GROUP 1 (TYPICAL H.M. SERVICE DOORS)

- EACH TO RECEIVE:
- 1-1/2 PAIR BUTTS, BR1279, 4-1/2 X 4-1/2 , NRP, US26D
 - 1 EACH THRESHOLD 887 X REQUIRED LENGTH
 - 1 SET WEATHER-STRIPPING
 - 1 EACH DRY CAP
 - ** 1 EACH PANIC DEVICE ECL-230 D
 - ** 1 EACH PANIC DEVICE ECL-435K FOR DOUBLE DOORS
 - 1 CLOSER, 1461, AL

GROUP 2 (TYPICAL TOILET ROOM & LOUNGE DOORS)

- EACH TO RECEIVE:
- 1-1/2 PAIR BUTTS, BR1279, 4-1/2 X 4-1/2 , NRP, US26D
 - 1 FLOOR STOP 4386 26D
 - 1 PUSH PLATE & PULL HANDLE
 - 1 CLOSER, 1461, AL

GROUP 3 (ALUMINUM STOREFRONTS)

- EACH TO RECEIVE:
- PSD BAR & PULL HANDLE
 - * KEVED CYLINDER EXTERIOR FA-077-626
 - WITH THUMB TURN INTERIOR M.S. ILLOW 7161TK2-26D
 - 1 CLOSER, 1461, AL
 - THRESHOLD ADA APPROVED
 - MANUFACTURER STANDARD OFFSET PIVOTS
 - INSTALL ALUM. CART GUARDS ON EXTERIOR & INTERIOR OF DOOR
 - * DOWN MORTISE CYLINDER ILLOW 7160DC-26D
 - INTERIOR THUMBTURN ILLOW 7161 TR2-26D FOR ALL OTHER OUTSIDE DOORS.

GROUP 4 (ALUMINUM STOREFRONTS - AUTO)

- EACH TO RECEIVE:
- FULLY AUTOMATIC OPERATORS
 - * KEVED CYLINDER EXTERIOR FA-077-626
 - WITH THUMB TURN INTERIOR M.S. ILLOW 7161TK2-26D
 - THRESHOLD ADA APPROVED
 - MANUFACTURER STANDARD OFFSET PIVOTS
 - INSTALL ALUM. CART GUARDS ON EXTERIOR & INTERIOR OF DOOR

GROUP 5 (COUNT & CASH ROOM DOORS)

- EACH TO RECEIVE:
- 1-1/2 PAIR BUTTS, BR1279, 4-1/2 X 4-1/2 , NRP, US26D
 - * 1 STOREROOM SET, M12SHIC-26D
 - 1 FLOOR STOP 4386 26D
 - 1 CLOSER, 1461, AL
 - * 1 PEEP HOLE (MOUNT'G HT. TO BE 5'-0" A.F.F.)
 - * SINGLE CYLINDER DEADBOLT #6611C-26D
 - (EXTERIOR KEYWAY / INTERIOR THUMBTURN)

GROUP 6 (TYPICAL OFFICE DOORS)

- EACH TO RECEIVE:
- 1-1/2 PAIR BUTTS, BR1279, 4-1/2 X 4-1/2 , NRP, US26D
 - * 1- ENTRANCE LEVERSET M11SHIC-26D
 - 1 FLOOR STOP 4386 26D
 - ** ADDITIONAL NOTES:
 - BASS LOCK WILL PROVIDE PULLBACKS FOR OVERHEAD DOORS AND ROOFHATCH AND ONE (1) SPARE LOCK.

FINISH LEGEND


- [P-1] "SHERWIN WILLIAMS" PROMAR 200 # SW1662 NATURAL SILK (EGGSHELL FINISH)
- [P-2] " FRP" TO BRITE WHITE WITH T- MOLDING & J-MOLDING ON ALL WALLS
- [P-3] "SHERWIN WILLIAMS" INTERIOR BASIC BROWN #SW1098 (EG-SHEL FINISH) - OR EQUAL
- [P-4] WALNUT STAIN WITH POLYURATHANE FINISH

EXTERIOR FINISH




COLOR	PART NO.	
BROWN	SW2063	SHERWIN WILLIAMS A100 SEMI-GLOSS
TAN	SW2060	SHERWIN WILLIAMS A100 SEMI-GLOSS
WHITE		SHERWIN WILLIAMS A100 SEMI-GLOSS

ROOM FINISH SCHEDULE

ROOM & OR AREA	FLOOR	BASE	WALLS	CEILING		REMARKS
				MATERIAL	HEIGHT	
VESTIBULE						
SALES AREA						
LOUNGE						
WOMEN'S RESTROOM						
MEN'S RESTROOM						
MANAGER'S OFFICE						
COUNT ROOM						
CASH ROOM						
STOCK ROOM						
JANITOR CLOSET						
RESTROOM ENTRY						
WATER COOLER AREA						

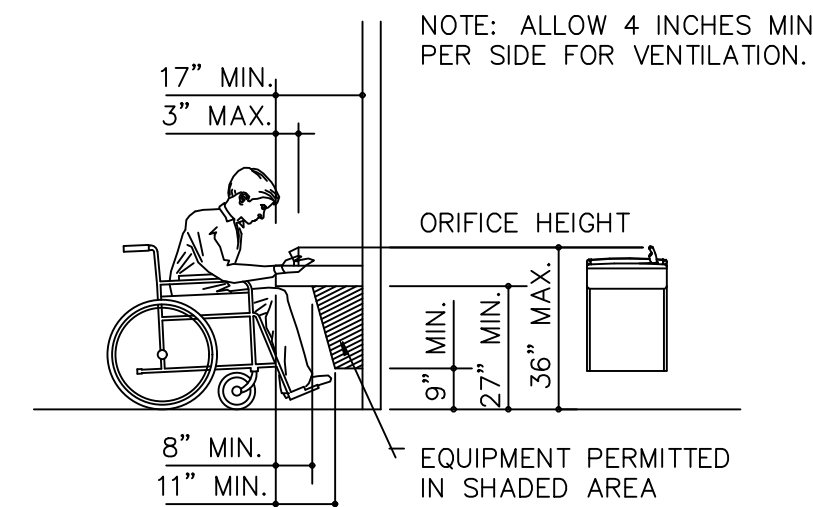

HANDICAP DRINKING FTN. CLEARANCES

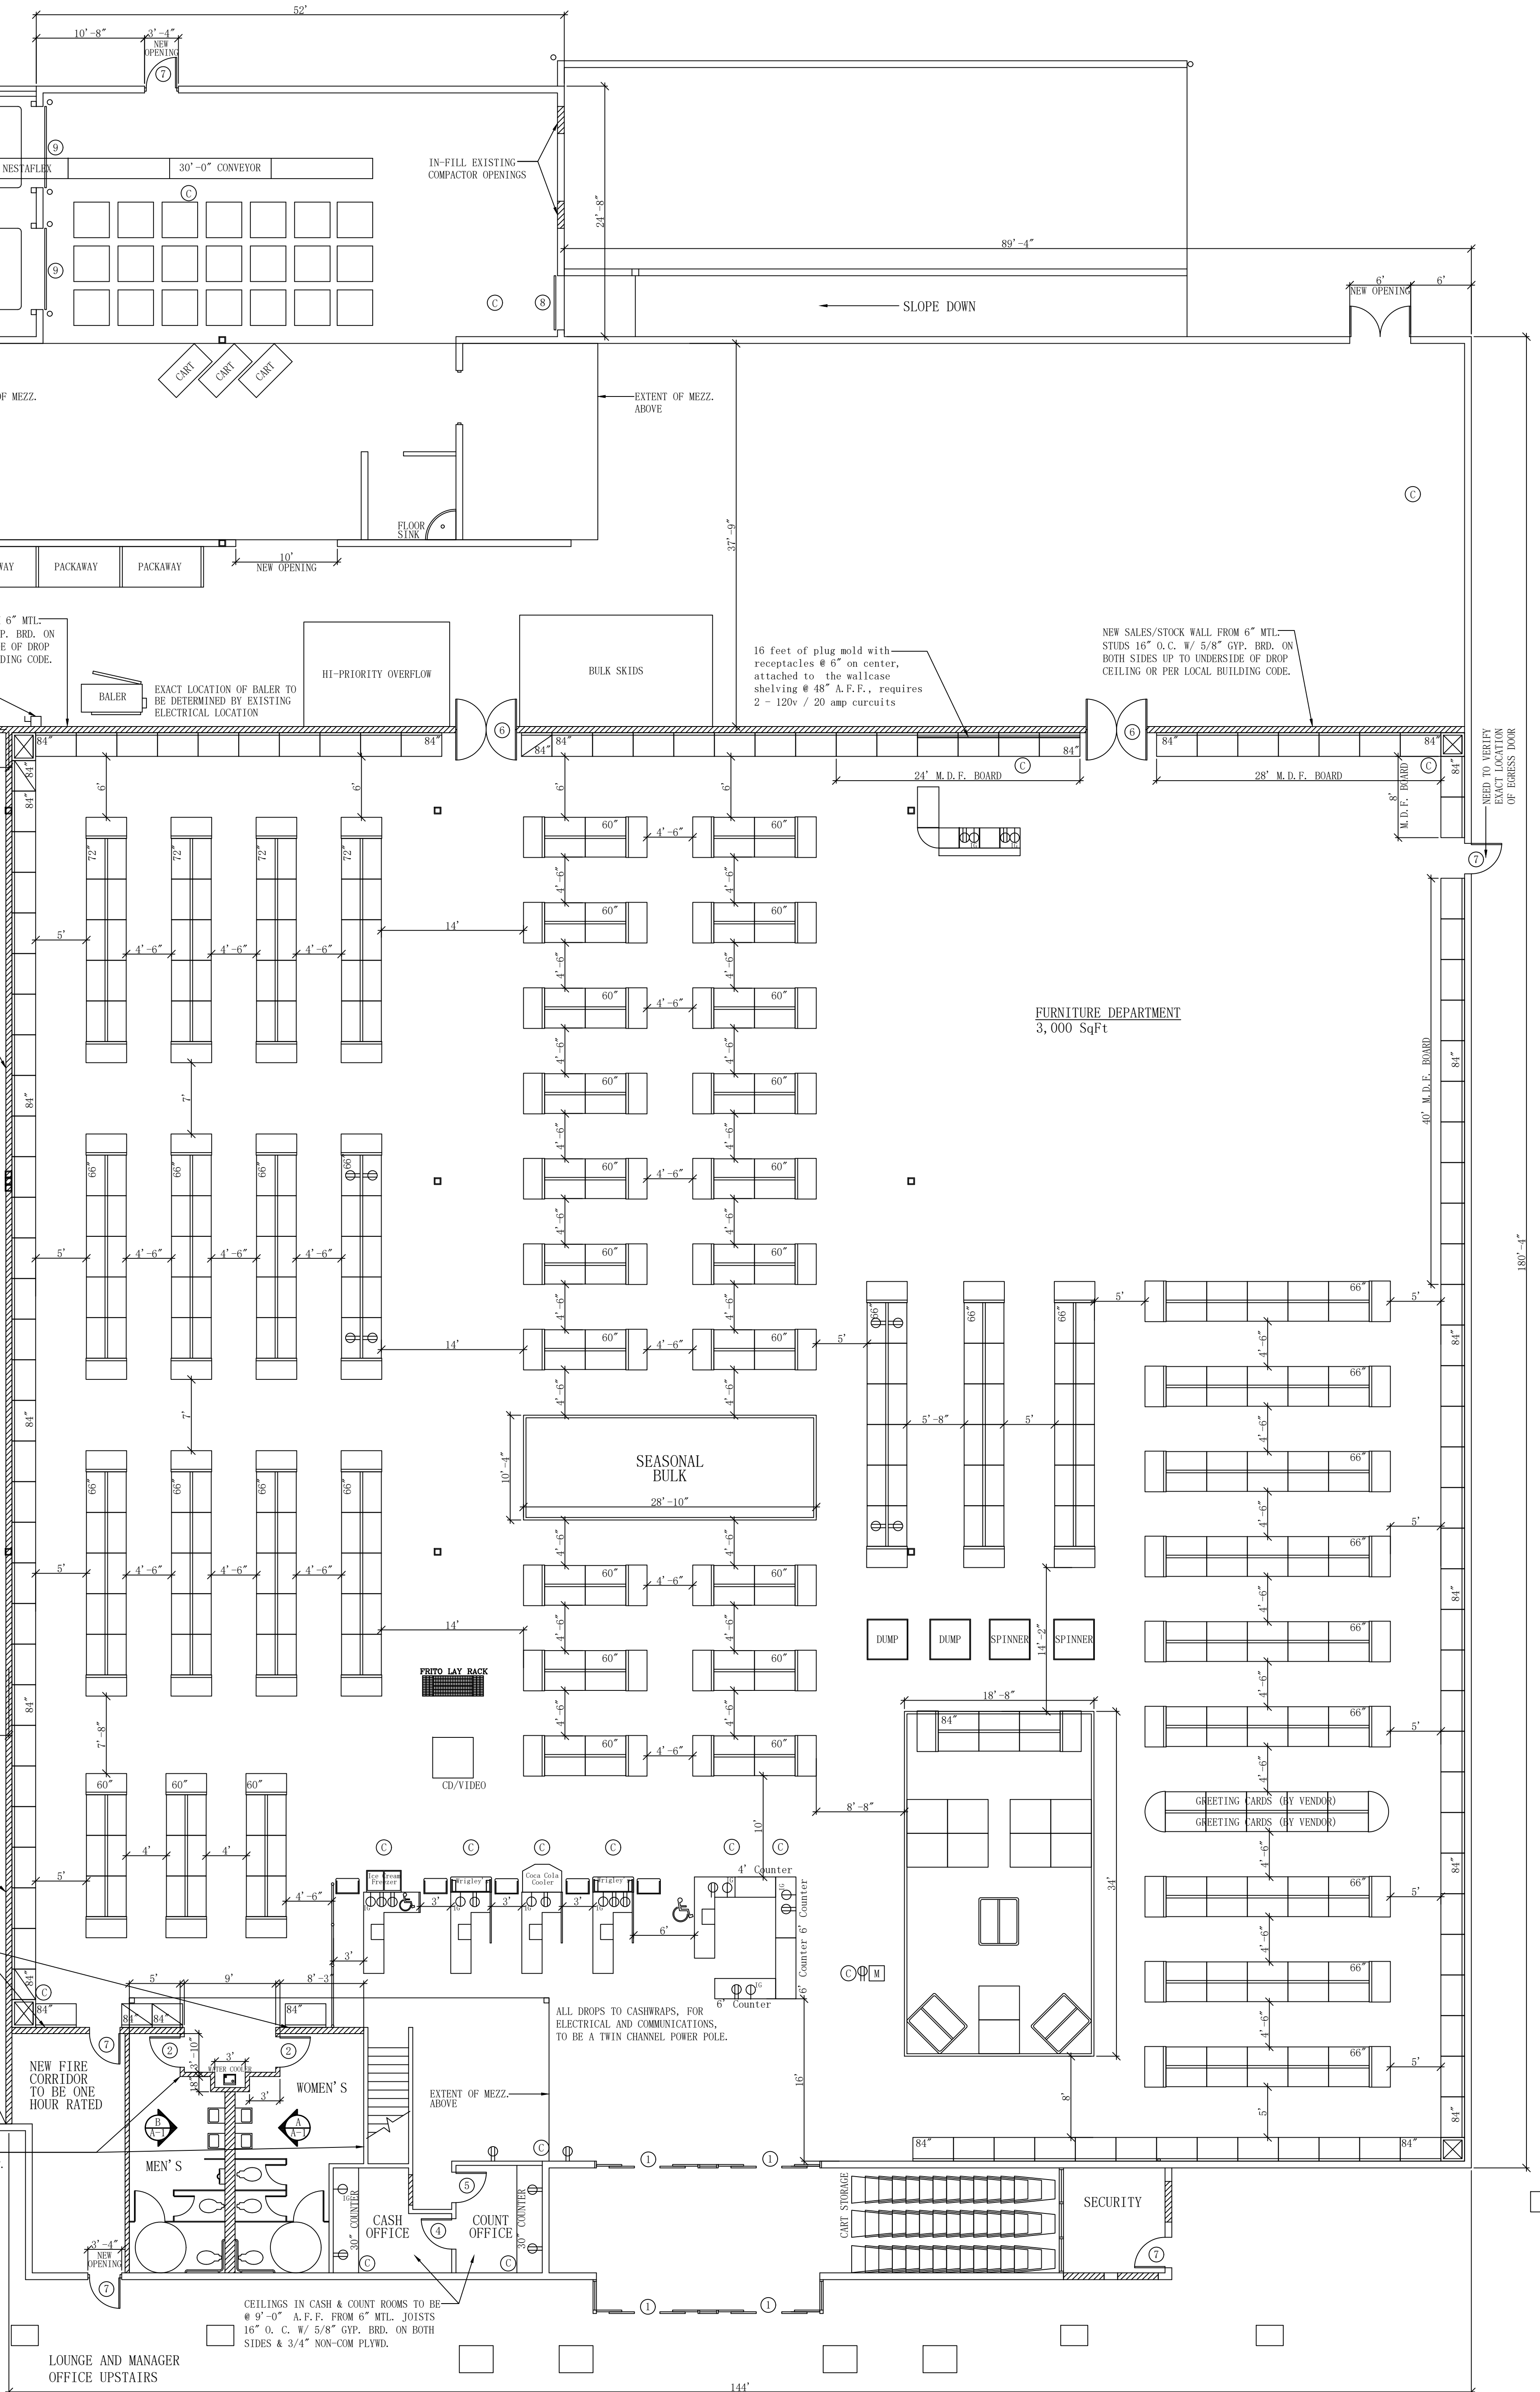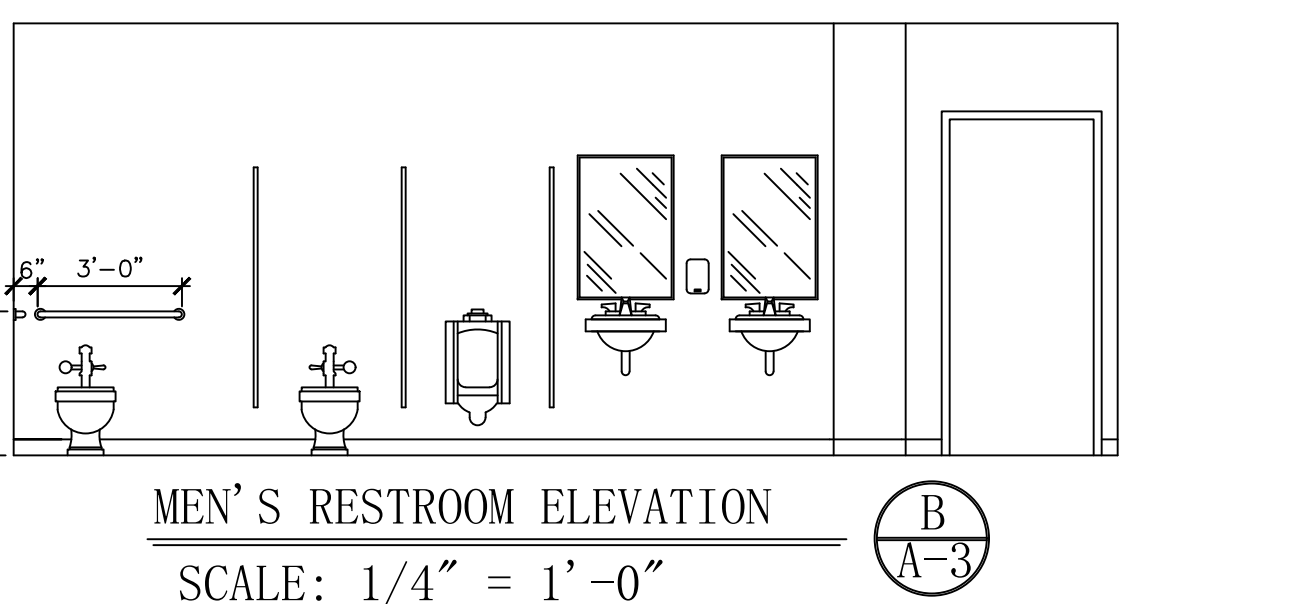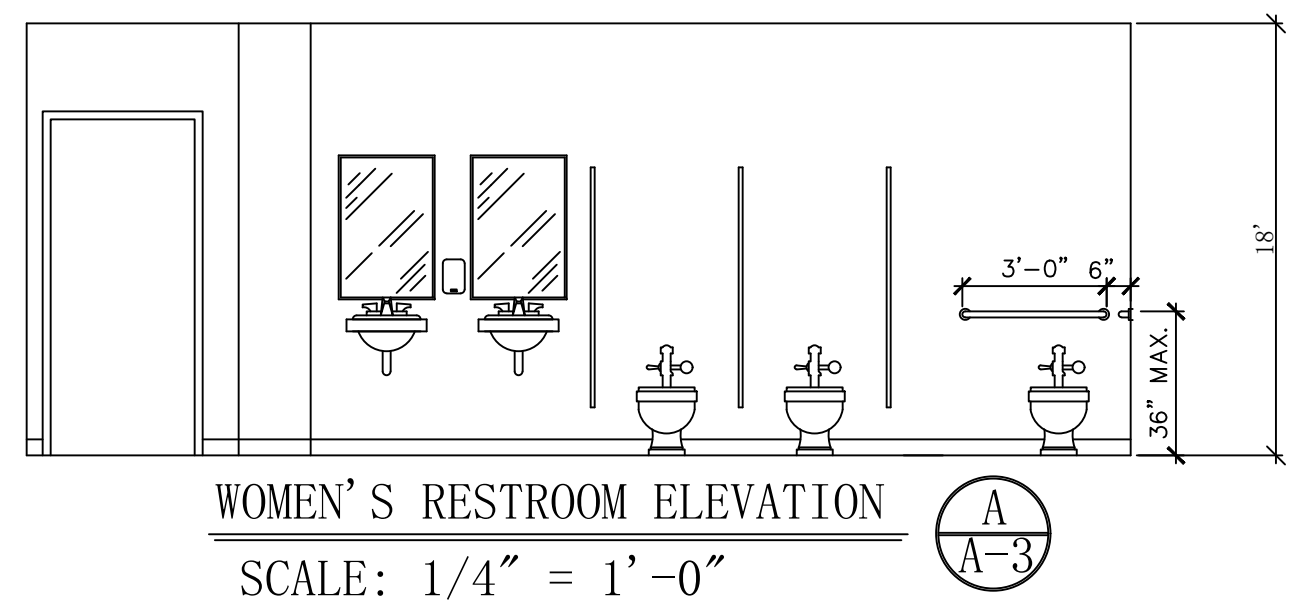

FLOOR PLAN

01/22/04 ADDED FIRE CORRIDOR, ADDED A.D.A. ELEVATIONS OF RESTROOMS. (CIL)

02/11/04 CHANGED HEIGHT OF WALL IN OFFICES FOR PRIVACY (CIL)

02/27/04 ADDED PAIR OF DOORS IN STOCK ROOM FOR FURNITURE PICK-UP (CIL)

03/12/04 ADDED CAMERA LOCATIONS PER M. SPARKS (CIL)

04/12/04 MOVED DUMPS/SPINNERS, REPLACED WITH GONDOLA (CIL)

DATE: REVISION 6:

DATE: REVISION 7:

DATE: REVISION 8:

BIG LOTS STORES, INC.

STORE PLANNING DEPT.

300 PHILLIP ROAD

COLUMBUS , OHIO 43228

PHONE: (614) 278-6800

BIG LOTS STORE #4485

SHOPPING CENTER

90th SOUTH & 40th WEST

WEST JORDAN, UT 84068

SCALE: 1/8" = 1'-0"

DATE: 12 - 17 - 03

DRAWN BY: CIL

SQUARE FOOTAGE: 20,220


SALES: 20,220 (INCLUDES FURNITURE DEPT)

TOTAL: 29,200






BIG LOTS!

BIG LOTS STORES , INC.

SHEET: A-1

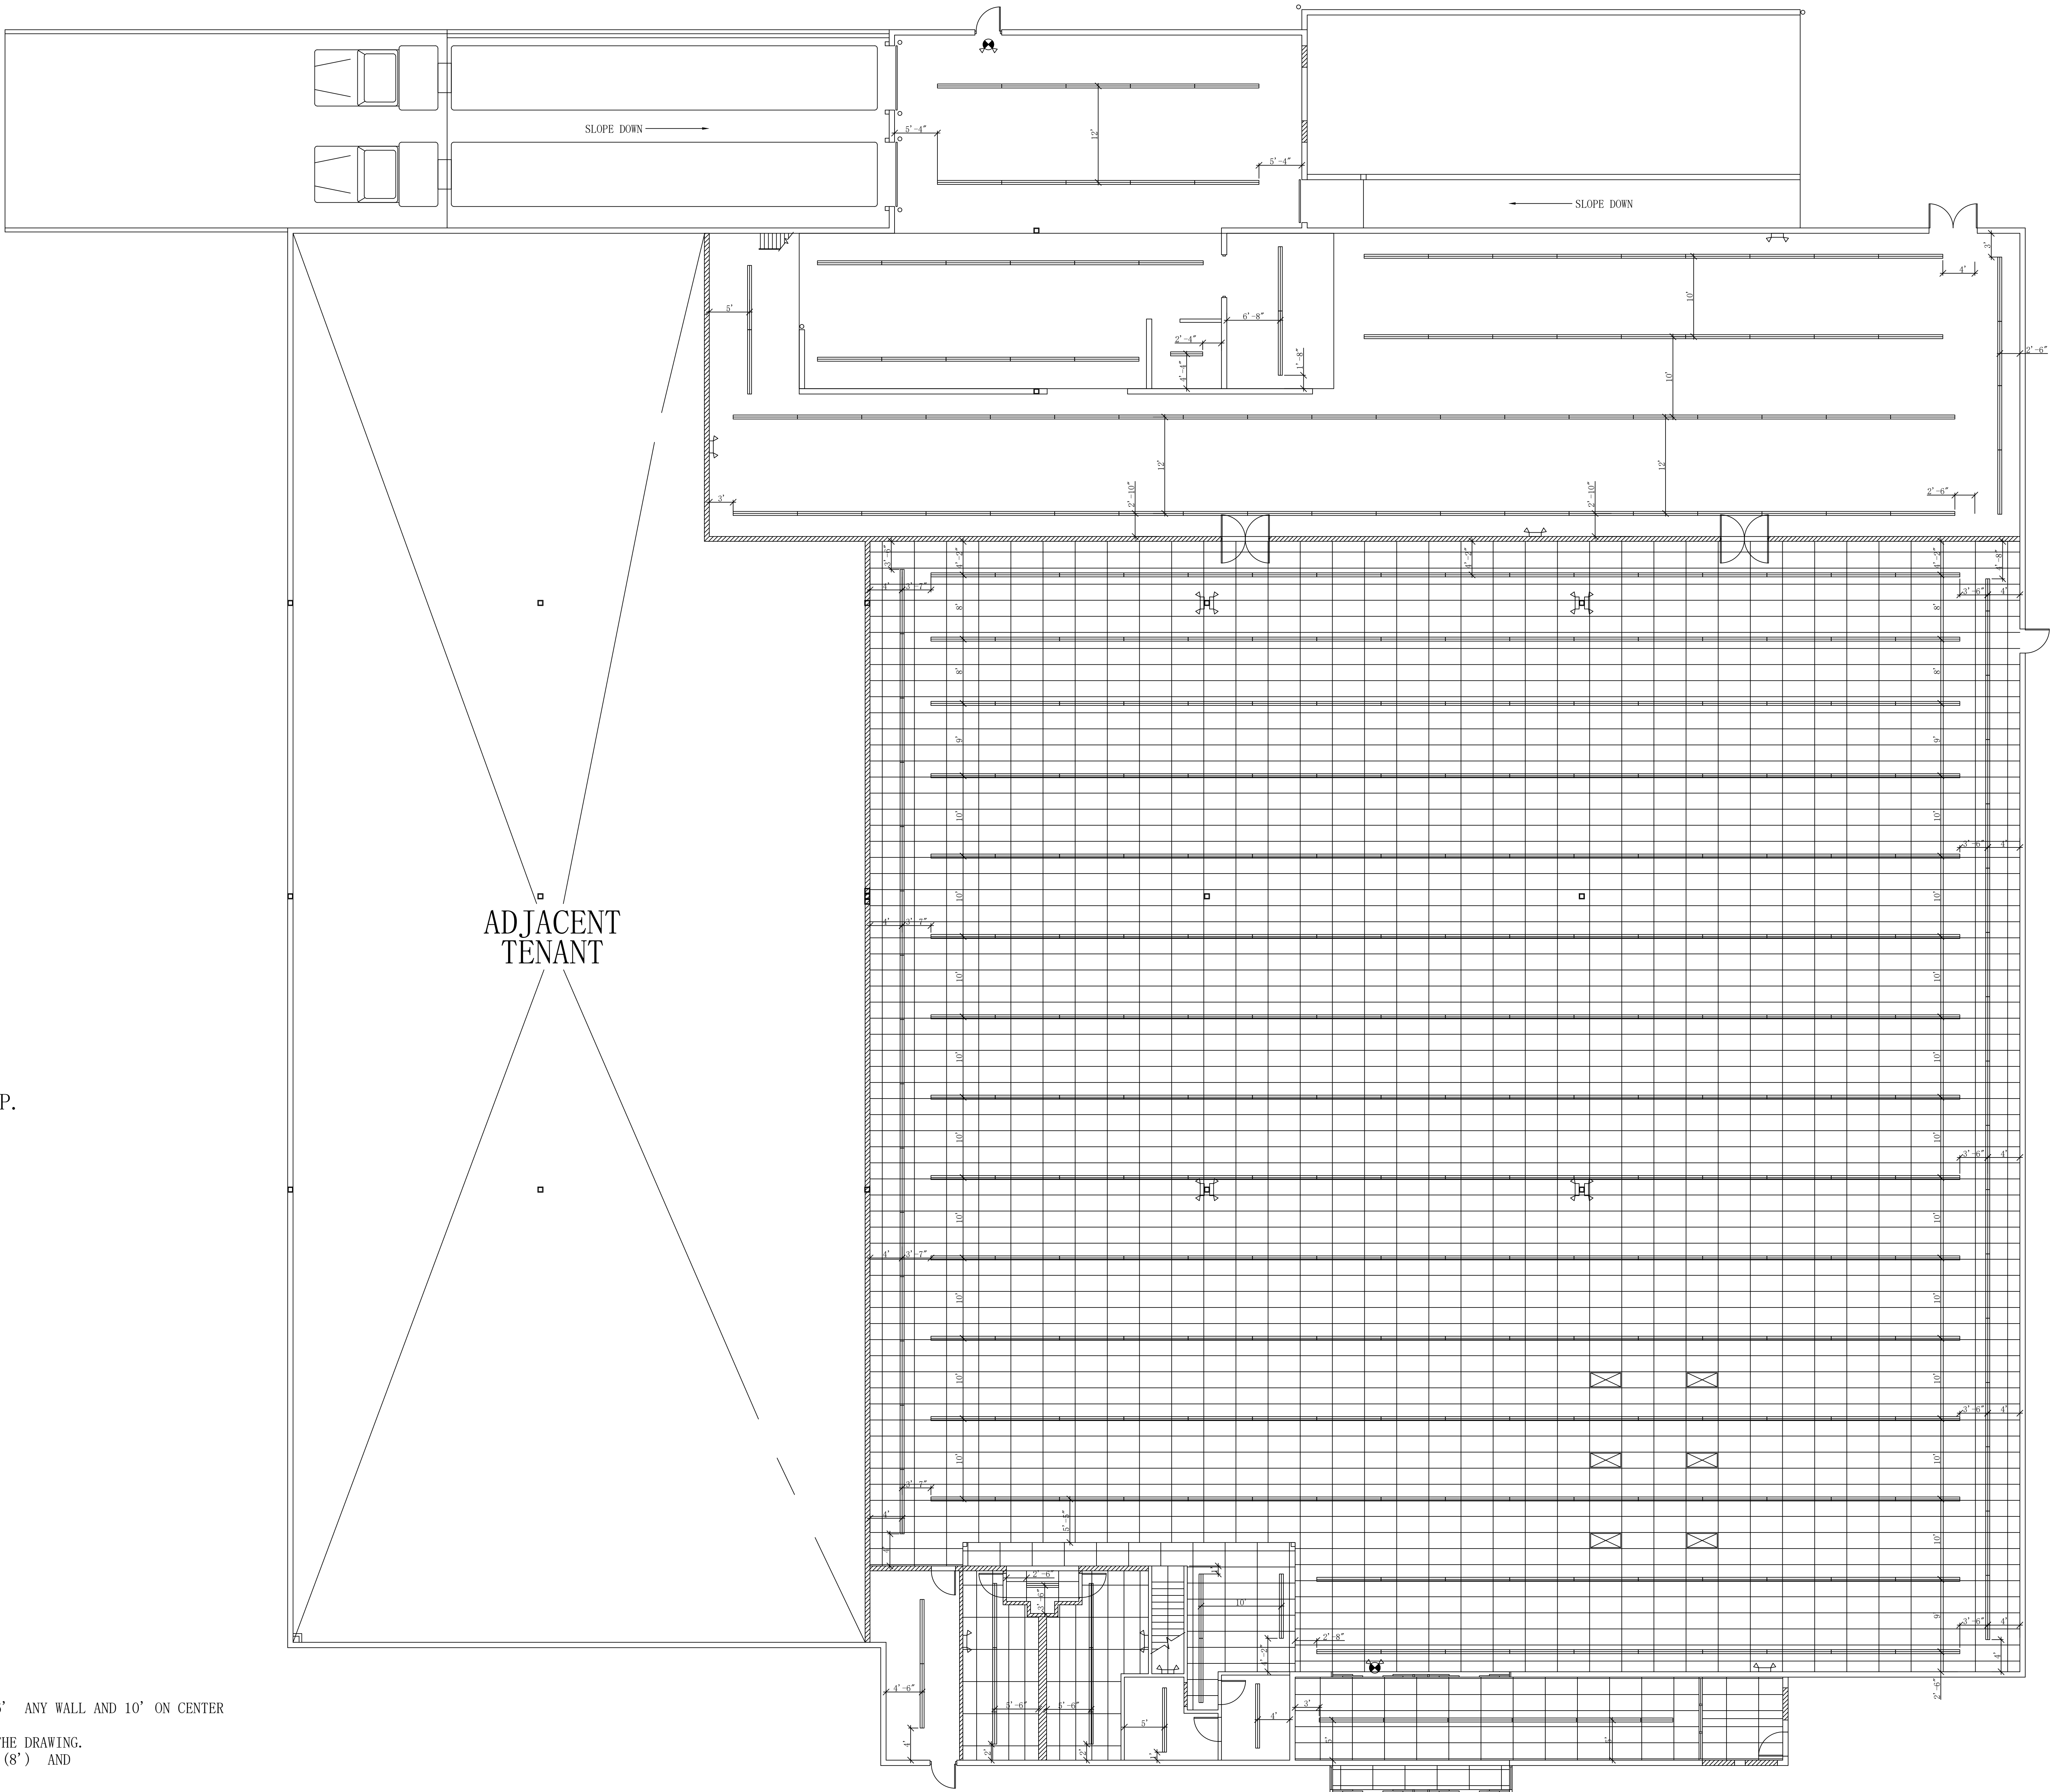

LIGHTING LEGEND

     -  EMERGENCY LIGHT WITH BATTERY PICK-UP.
-  EMERGENCY LIGHT EXIT SIGN COMBO.
-  LIGHTED EXIT SIGN
-  4' DOUBLE TUBE FLOURESCENT LIGHT
-  8' DOUBLE TUBE FLOURESCENT LIGHT
-  2' x 4' LAY-IN LIGHT

LIGHTING NOTES


- ALL LIGHT FIXTURES IN THE STOCK OR STORAGE AREA TO BE HUNG AT 14' AFF.
- WHEN APPLICABLE ALL LIGHT FIXTURES IN THE SALES FLOOR TO BE HUNG FROM THE BOTTOM OF THE CEILING GRID BY THE CLIPS PROVIDED.
- ALL PERIMETER LIGHTING FIXTURES ON THE SALES FLOOR TO BY MOUNTED BETWEEN 4' TO 6' ANY WALL AND 10' ON CENTER WHERE APPLICABLE, ROWS SHOULD RUN LEFT TO RIGHT FROM STORE FRONT .
- ALL THE LIGHT FIXTURES IN THE STOCK OR STORAGE AREAS TO BE MOUNTED AS NOTED ON THE DRAWING.
- ALL LIGHT FIXTURES TO BE DAY-BRIGHT # T-232-UNV-1/2EB (4') AND TT-232-UNV-1/4EB (8') AND SHALL HAVE 4' T-8 LAMPS AND ELECTRONIC BALLAST.
- ALL EMERGENCY FIXTURES TO BE LITHONIA QUANTUM SERIES. THE EMERGENCY LIGHT WILL BE A STOCK NUMBER ELM AND THE EXIT/EMERGENCY COMBO WILL BE A STOCK NUMBER LHQMSW3R 120/277.
- THIS DRAWING MAY NOT MEET THE LOCAL CODED IN YOUR AREA. IT IS YOUR RESPONSIBILITY TO GET THE ENGINEERING STAMP AND PERMIT TO PERFORM THIS WORK.
- ALL CHANGES TO BE APPROVED BY A BIG LOTS, INC. REPRESENTATIVE.
- ALL WORK TO BE DONE IN A WORKMAN LIKE MANOR, WITH A ONE YEAR WARRANTY ON THE LABOR AND MATERIAL OF INSTALLATION.
- ALL LOCATIONS TO BE FIELD VERIFIED.

LIGHTING PLAN


BIG LOTS STORE #4485 SHOPPING CENTER 90th SOUTH & 40th WEST WEST JORDAN, UT 84088 SCALE: 1/8" = 1'-0" DATE: 12 - 17 - 03	SQUARE FOOTAGE: SALES:20,220 (INCLUDES FURNITURE DEPT.) TOTAL:29,200	BIG LOTS STORES, INC. STORE PLANNING DEPT. 300 PHILLIPI ROAD COLUMBUS , OHIO 43228 PHONE: (614) 278-6800	01/22/04	ADDED FIRE CORRIDOR, ADDED A.D.A. ELEVATIONS OF RESTROOMS. (CIL)
			02/11/04	CHANGED HEIGHT OF WALL IN OFFICES FOR PRIVACY (CIL)
			02/27/04	ADDED PAIR OF DOORS IN STOCK ROOM FOR FURNITURE PICK-UP (CIL)
			03/12/04	ADDED CAMERA LOCATIONS PER M. SPARKS (CIL)
			04/12/04	MOVED DUMPS/SPINNERS, REPLACED WITH GONDOLA (CIL)
			DATE:	REVISION 6:
			DATE:	REVISION 7:
			DATE:	REVISION 8:

SHEET:

A-2

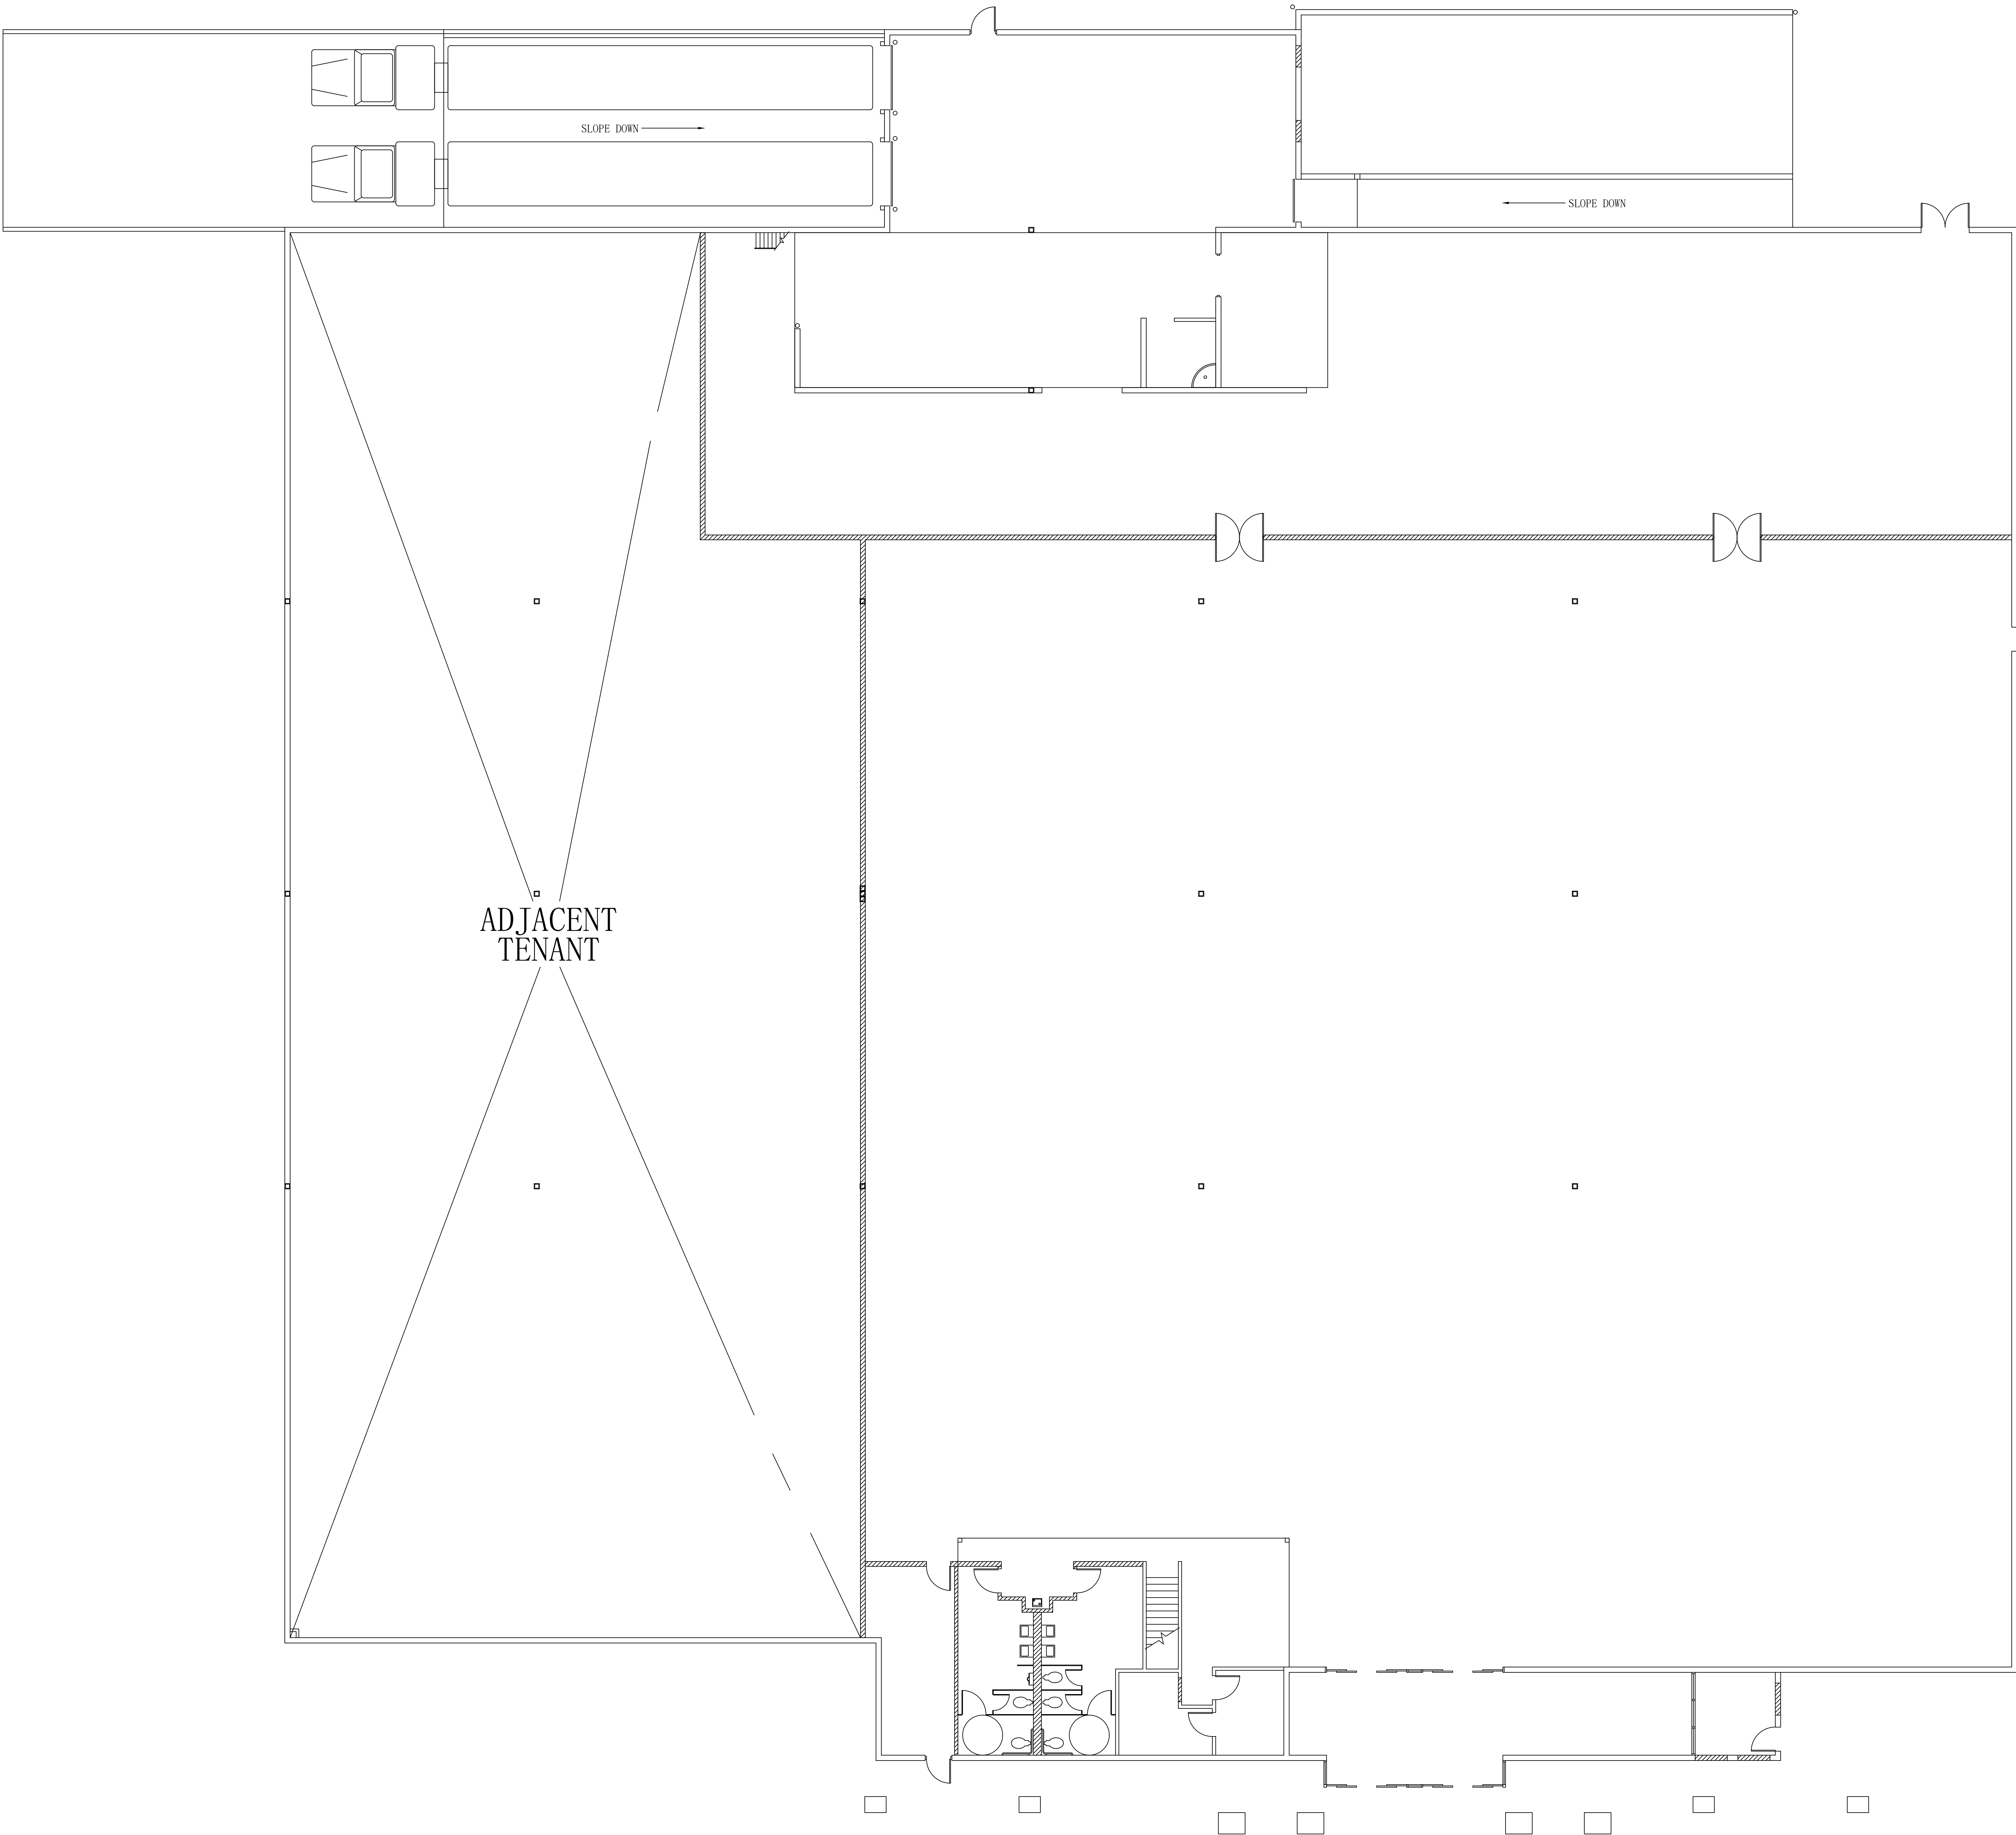

MECHANICAL PLAN

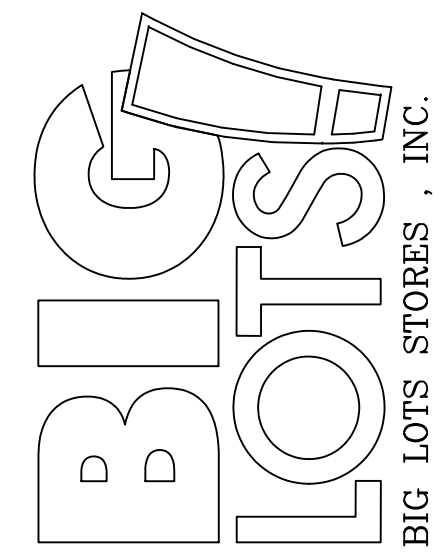


SQUARE
FOOTAGE:
SALES:20,220
(INCLUDES FURNITURE DEPT.)
TOTAL:29,200

BIG LOTS STORE #4485
SHOPPING CENTER
90th SOUTH & 40th WEST
WEST JORDAN, UT 84088

BIG LOTS STORES, INC.
STORE PLANNING DEPT.
300 PHILLIPI ROAD
COLUMBUS , OHIO 43228
PHONE: (614) 278-6800

01/22/04	ADDED FIRE CORRIDOR. ADDED A.D.A. ELEVATIONS OF RESTROOMS. (CJL)
02/11/04	CHANGED HEIGHT OF WALL IN OFFICES FOR PRIVACY (CJL)
02/27/04	ADDED PAIR OF DOORS IN STOCK ROOM FOR FURNITURE PICK-UP (CJL)
03/12/04	ADDED CAMERA LOCATIONS PER M. SPARKS (CJL)
04/12/04	MOVED DUMPS/SPINNERS. REPLACED WITH GONDOLA (CJL)
DATE:	REVISION 6:
DATE:	REVISION 7:
DATE:	REVISION 8:

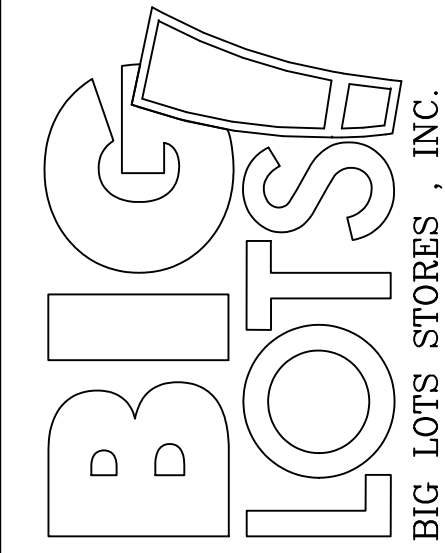

SQUARE
FOOTAGE:
SALES:20,220
(INCLUDES FURNITURE DEPT.)
TOTAL:29,200

BIG LOTS STORE #4485
SHOPPING CENTER
90th SOUTH & 40th WEST
WEST JORDAN, UT 84088

SCALE: 1/8" = 1'-0"	DATE: 12 - 17 - 03	DRAWN BY: CIL
------------------------	-----------------------	------------------

BIG LOTS STORES, INC.
STORE PLANNING DEPT.
300 PHILLIPI ROAD
COLUMBUS , OHIO 43228
PHONE: (614) 278-6800

01/22/04	ADDED FIRE CORRIDOR. ADDED A.D.A. ELEVATIONS OF RESTROOMS. (CIL)
02/11/04	CHANGED HEIGHT OF WALL IN OFFICES FOR PRIVACY (CIL)
02/27/04	ADDED PAIR OF DOORS IN STOCK ROOM FOR FURNITURE PICK-UP (CIL)
03/12/04	ADDED CAMERA LOCATIONS PER M. SPARKS (CIL)
04/12/04	MOVED DUMPS/SPINNERS. REPLACED WITH GONDOLA (CIL)
DATE:	REVISION 6:
DATE:	REVISION 7:
DATE:	REVISION 8: