




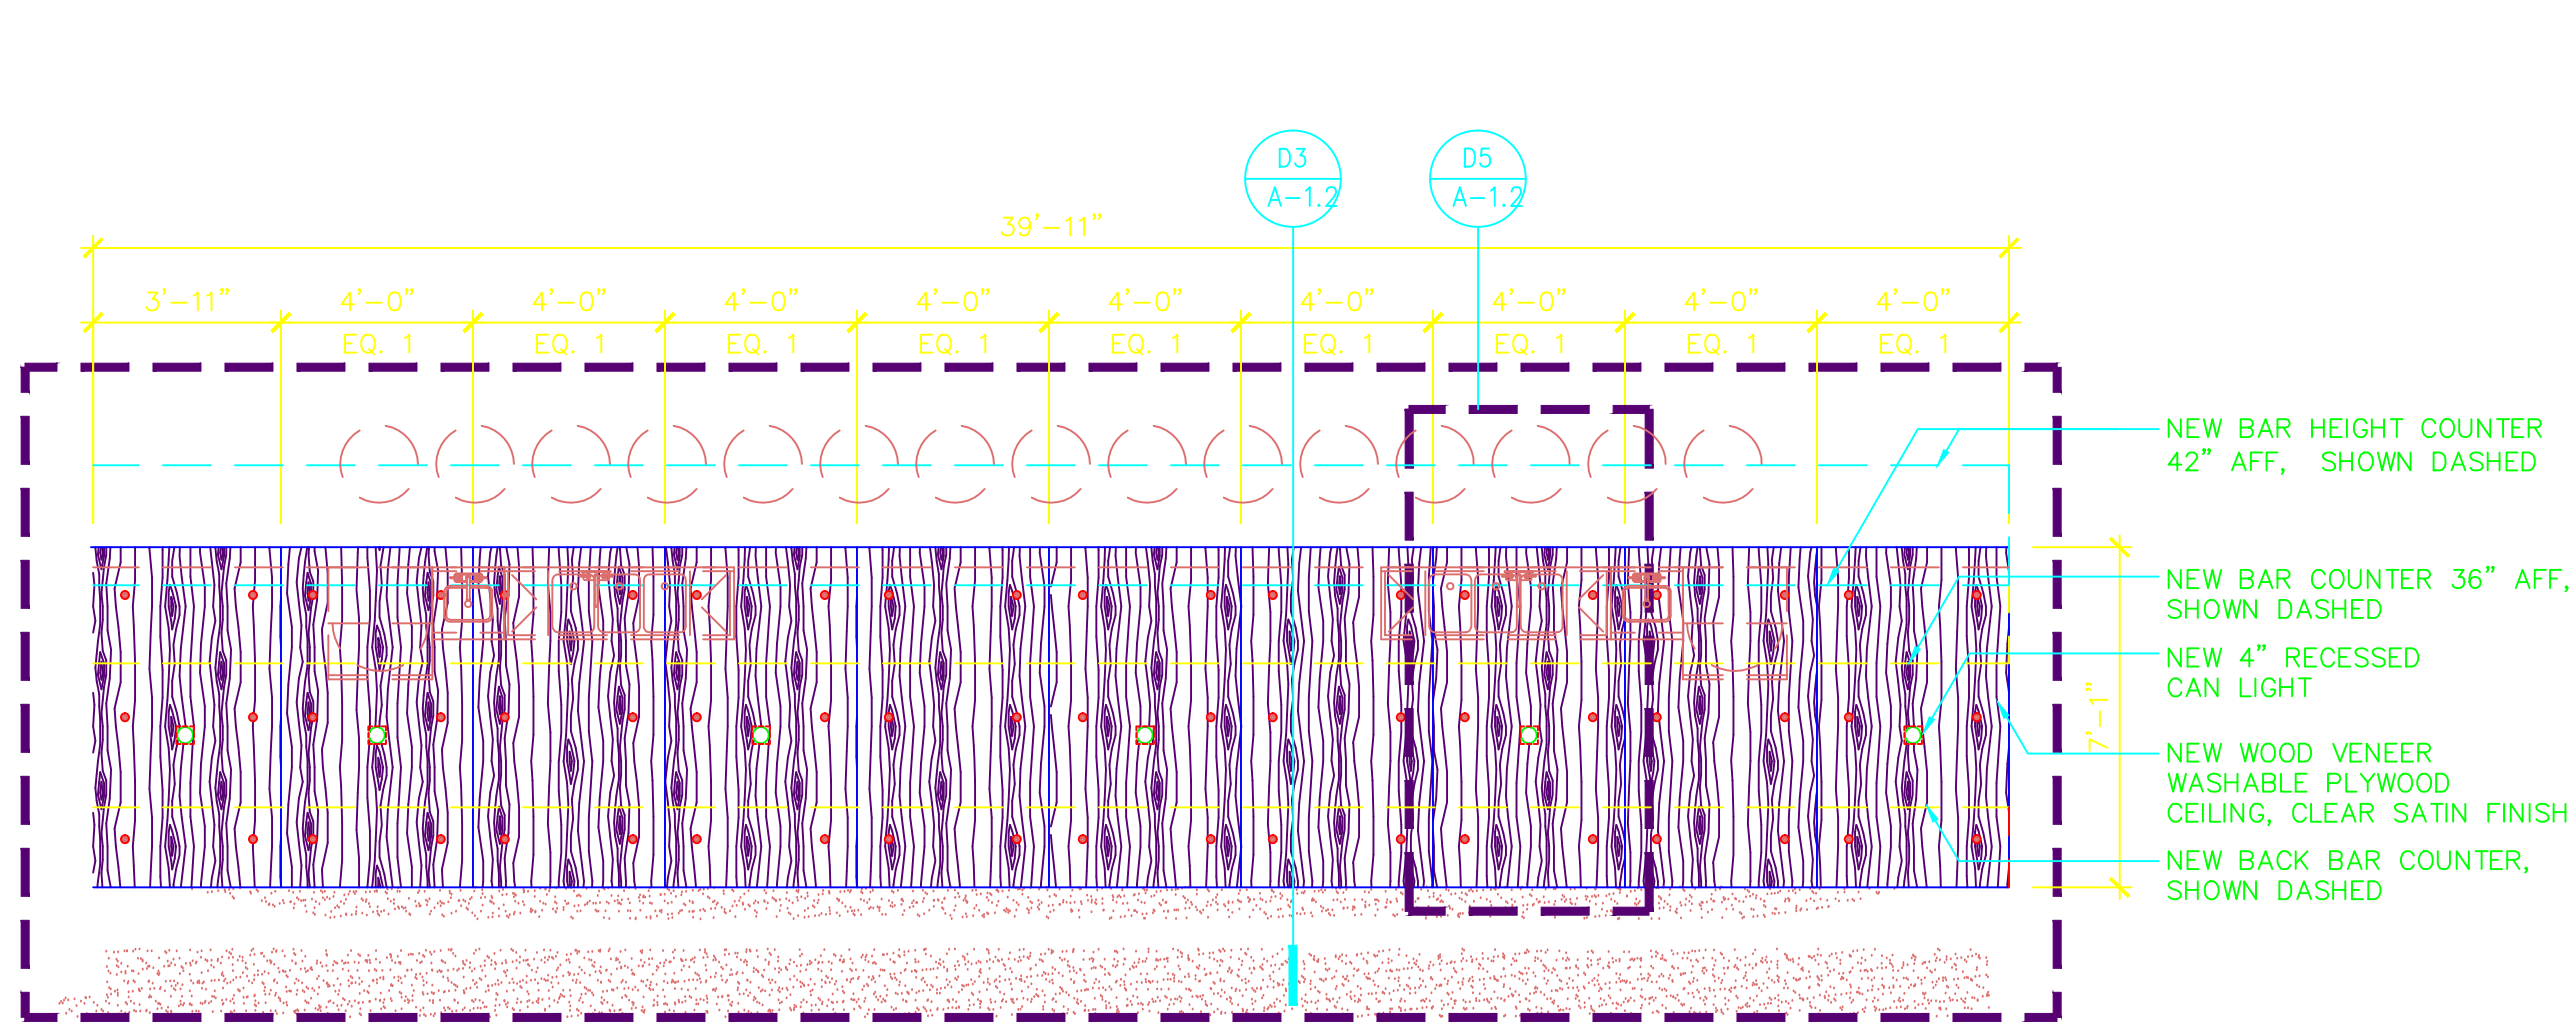

D1 ENLARGED REFLECTED CEILING - BAR (111)
1/4" = 1'-0"

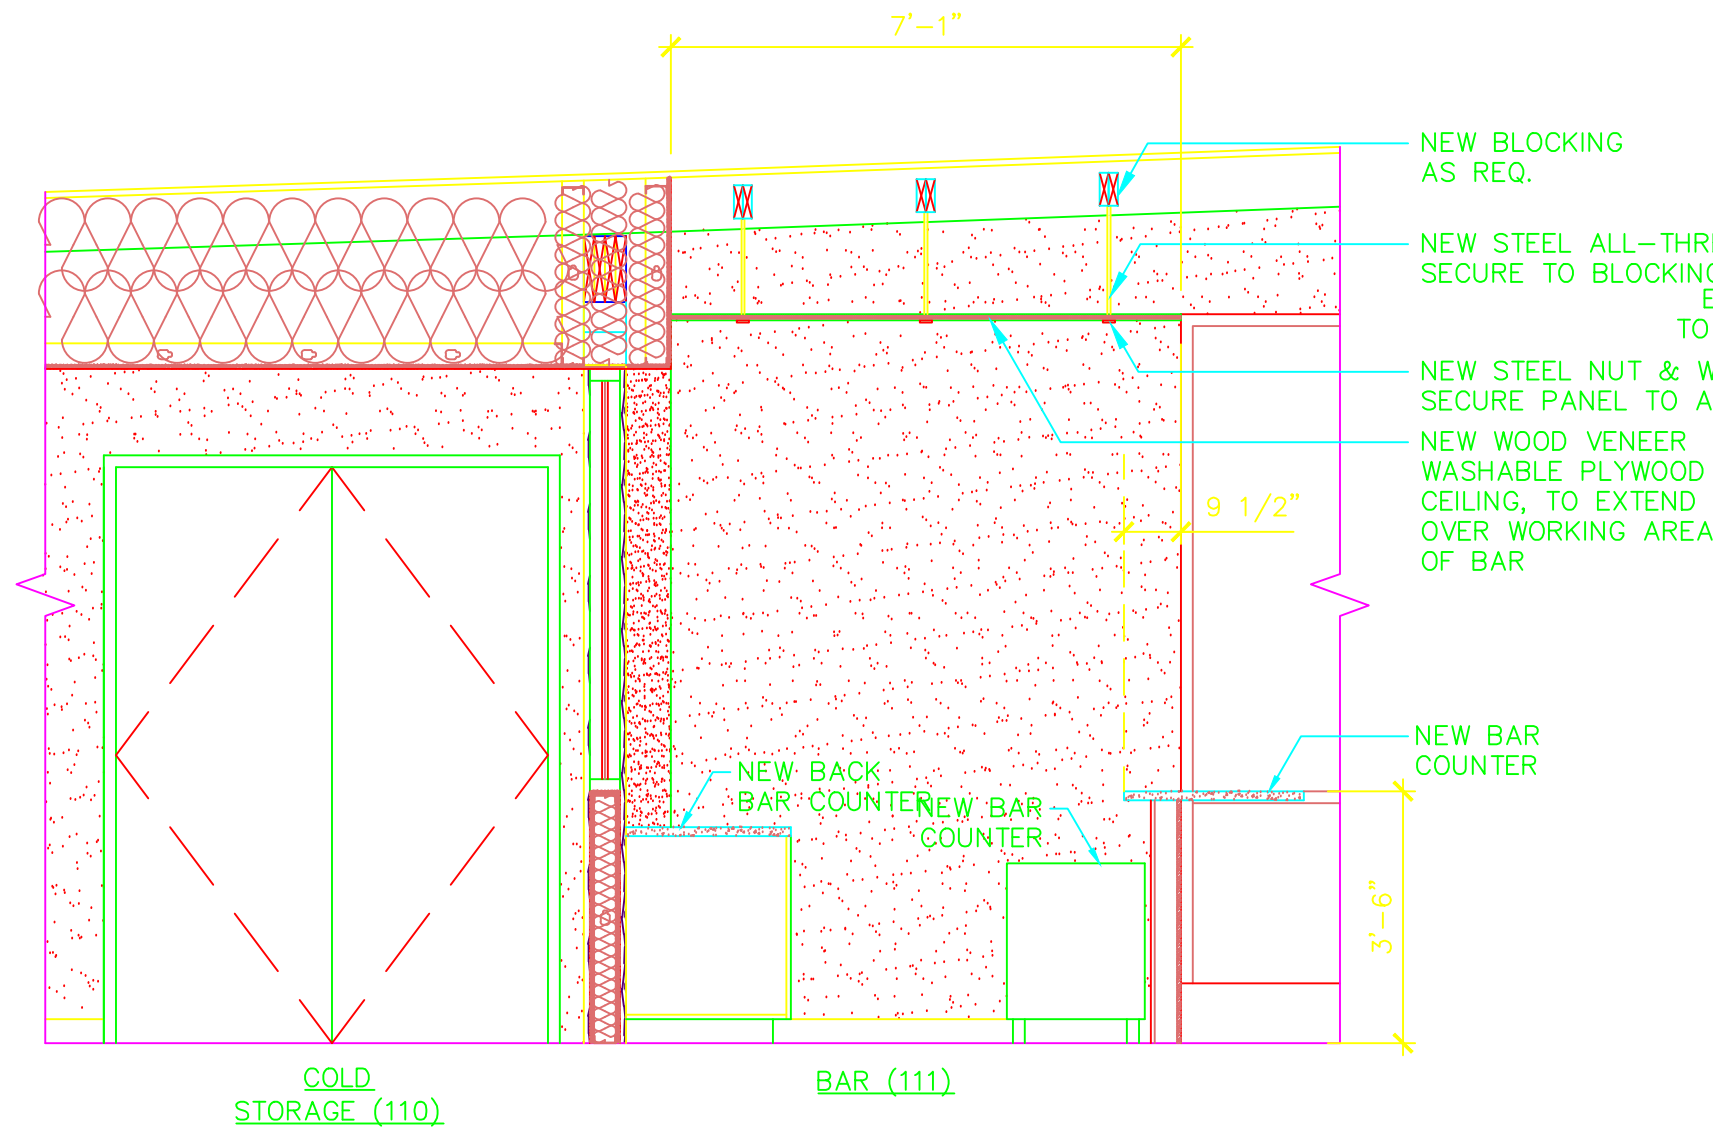


D3 ENLARGED SECTION - BAR (111)
3/8" = 1'-0"

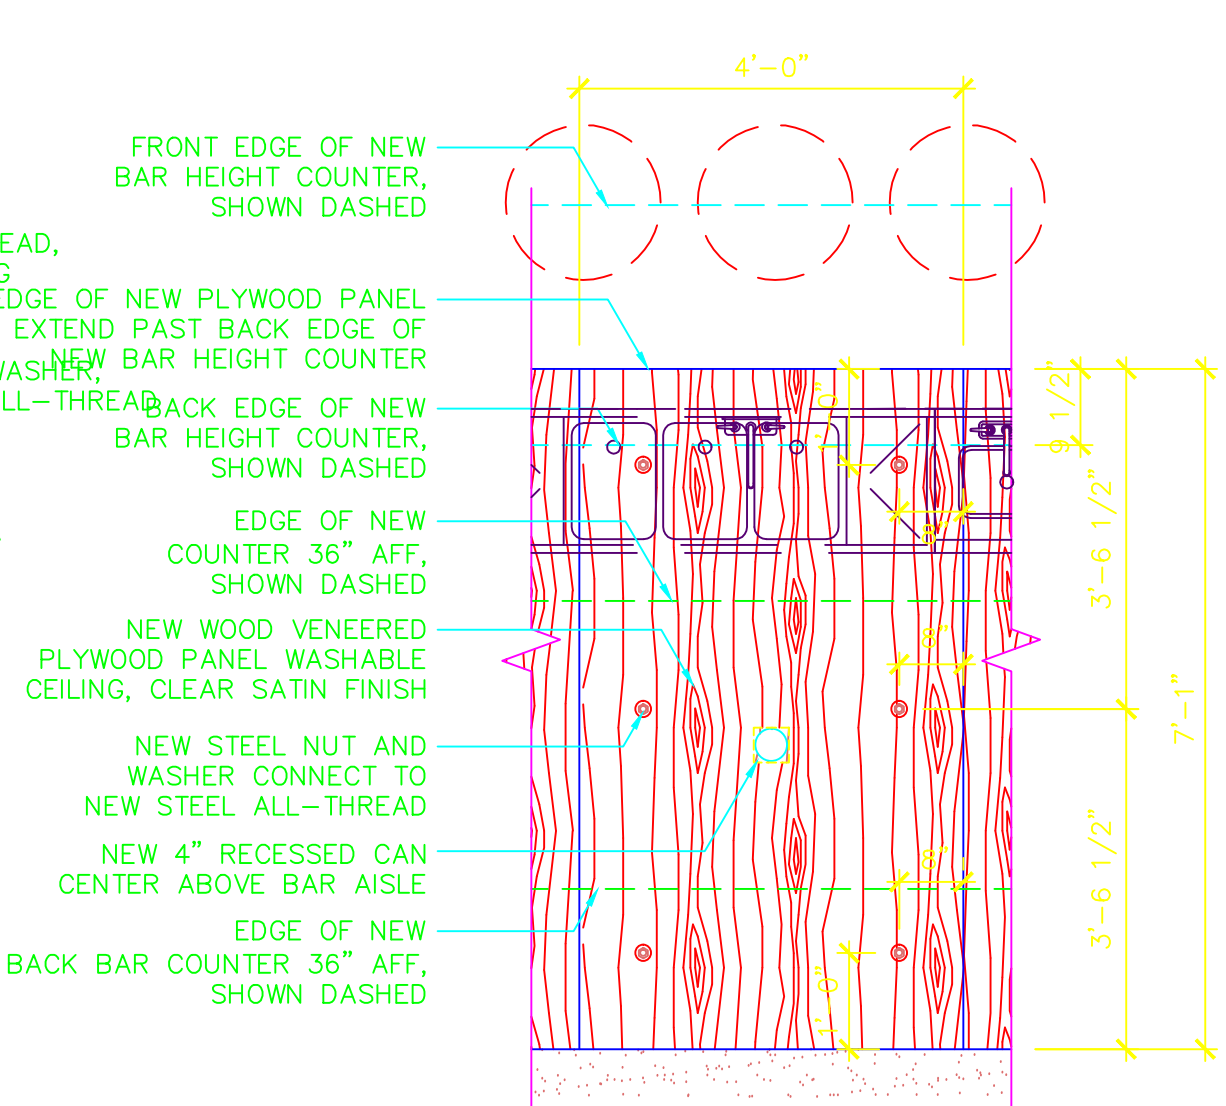

D5 ENLARGED CEILING PANEL - BAR (111)
1/2" = 1'-0"

REFERENCE NOTES:

1. NEW POWER PANEL, RE: ELECTRICAL.
2. PROVIDE POWER FOR FUTURE EXTERIOR LIGHTS, RE: ELECTRICAL.
3. PROVIDE POWER FOR 1.5HP PORTABLE PUMP, RE: ELECTRICAL.
4. PROVIDE POWER FOR CANNING LINE, RE: ELECTRICAL.
5. PROVIDE POWER FOR BAR GLASS WASHER, RE: ELECTRICAL.
6. PROVIDE POWER FOR NEW CEILING MOUNTED COOLING FAN/MECHANICAL UNIT, RE: ELECTRICAL.
7. PROVIDE POWER FOR MECHANICAL COOLER, RE: ELECTRICAL.
8. PROVIDE POWER FOR FUTURE LIGHTING, RE: ELECTRICAL.
9. PROVIDE POWER FOR FUTURE UNDER-COUNTER REFRIGERATOR AT BAR (110), RE: ELECTRICAL. COORDINATE W/ OWNER PROVIDED EQUIPMENT.

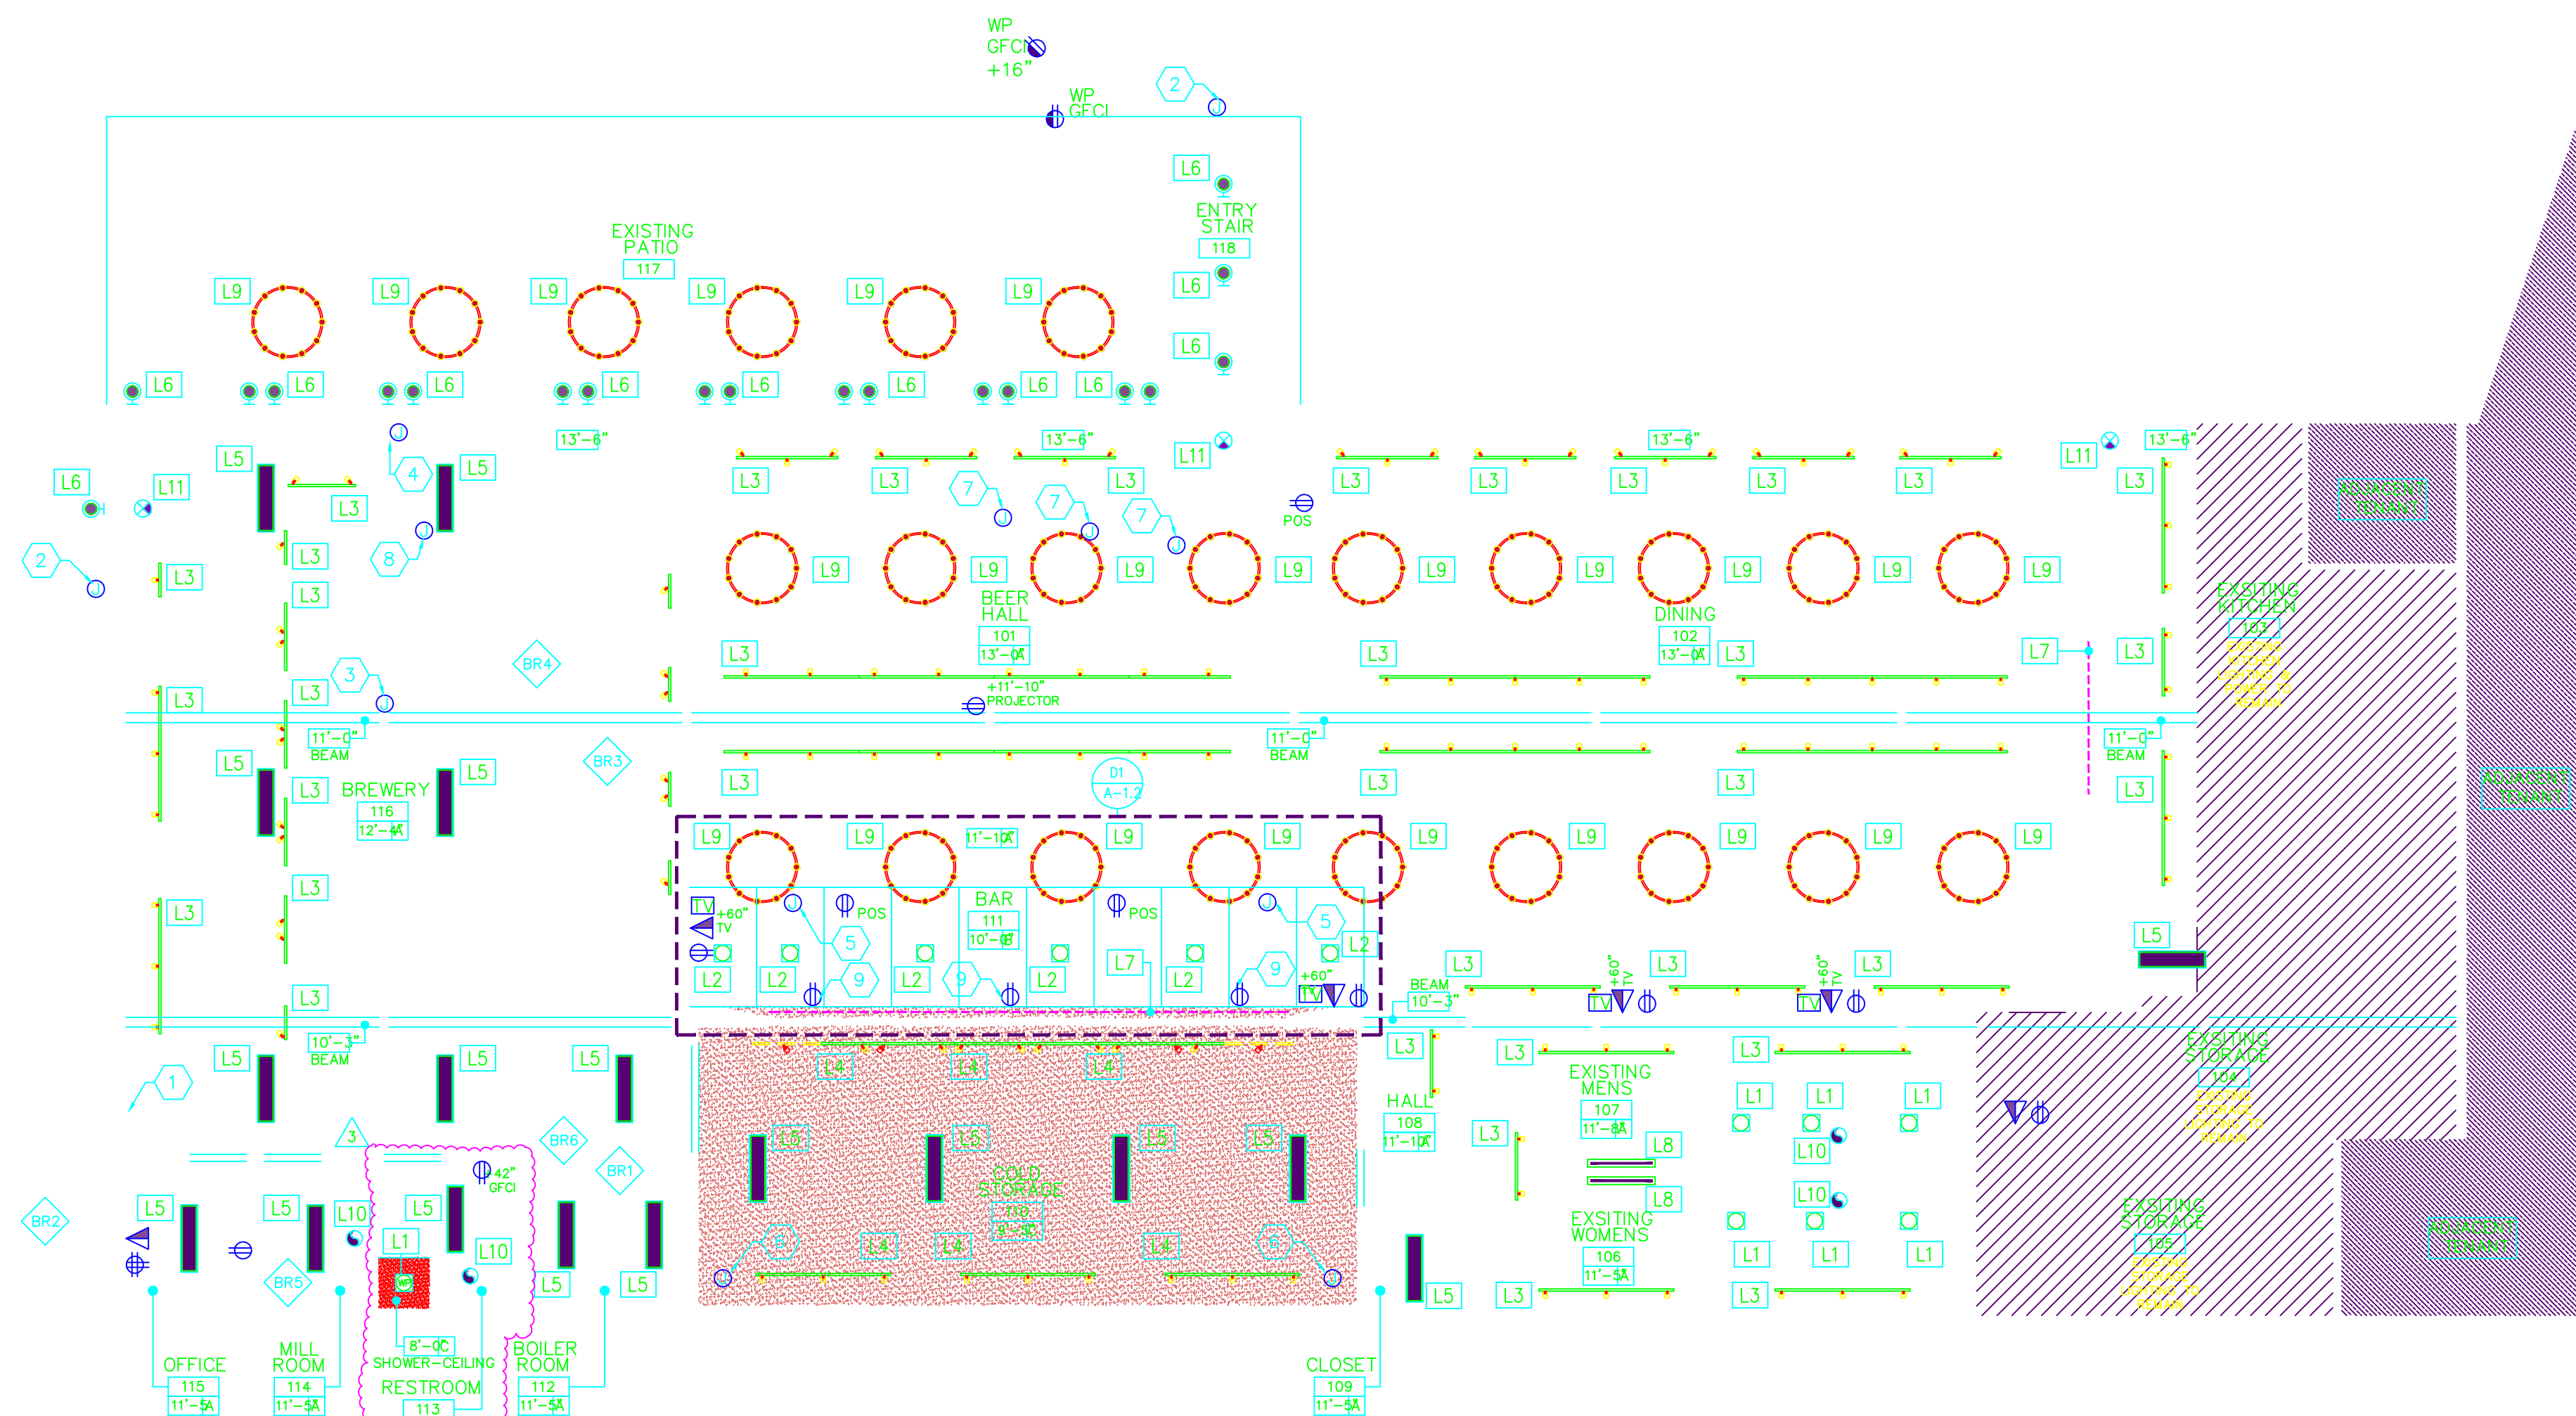

CEILING TYPES:

	TYPE A EXPOSED CEILING (11'-10" BOTTOM OF JOIST)
	TYPE B WASHABLE SUSPENDED VENEERED PLYWOOD
	TYPE C GYP. BOARD CEILING

BREWERY EQUIP. LEGEND:

EQUIP. NO.	DESCRIPTION
BR1	RITE BOILER 63 S
BR2	7X7 HP GLYCOL CHILLER
BR3	10BBL 3V BREWHOUSE W/HLT
BR4	CELLAR TEMPERATURE CONTROL
BR5	MILL MACHINE
BR6	5HP 60 GALLON AIR COMPRESSOR

LIGHT LEGEND:

FIXT. NO.	DESCRIPTION
L1	NEW 4" RECESSED CAN LIGHT BAFFLE & TRIM: CHROME LAMP: LED, 3000K (WET LOCATION RATED)
L2	NEW 4" RECESSED CAN LIGHT BAFFLE & TRIM: CHROME LAMP: LED, 3000K MIN. (SHATTER RESISTANT)
L3	NEW LIGHT TRACK (BLACK) TRACK HEAD: OPEN GIMBAL (BLACK) LAMP: PAR 30 LED, 3000K MIN.
L4	NEW LIGHT TRACK (WHITE) TRACK HEAD: OPEN GIMBAL (WHITE) LAMP: PAR 30, 3000K MIN.
L5	NEW LED PANEL LIGHT 1' X 4', SURFACE MOUNT LAMP: LED, 3000K MIN.
L6	NEW EXTERIOR WALL SCONCE (BLACK) LAMP: LED, 3000K MIN.
L7	NEW LINEAR LED TAPE LIGHT LAMP: LED, 3000K MIN.
L8	NEW LINEAR DIRECT/INDIRECT WALL SCONCE LAMP: LED, 3000K MIN.
L9	NEW OWNER SUPPLIED PENDANT BOTTOM OF FIXTURE @ 9'-0" AFF.
L10	NEW EXHAUST FAN COORD. W/ MECHANICAL
L11	NEW EXIT SIGN W/ BATTERY BACK UP EMERGENCY POWER. SHADE INDICATES SIGN FACE.

POWER LEGEND:

COORD. W/ ELECTRICAL	DESCRIPTION
	DUPLEX RECEPTACLE, 120 V
	DUPLEX RECEPTACLE, 120 V TOP HALF SWITCHED
	FOUR PLEX RECEPTACLE, 120 V
	RECEPTACLE, 220 V
	GFCI GROUND FAULT INTERRUPTER
	WEATHERPROOF RECEPTACLE
	+42" DISTANCE ABOVE FINISHED FLOOR
	J-BOX
	DATA OUTLET
	COMBINED DATA/PHONE OUTLET
	TELEVISION/CABLE OUTLET

WALL LEGEND


	EXISTING EXTERIOR WALL
	EXISTING INTERIOR WALL
	NEW INTERIOR WALL

GENERAL NOTES:

1. CONTACT ARCHITECT FOR ANY CLARIFICATION REQUIRED, INCLUDING POSSIBLE DISCREPANCIES ON THE DRAWINGS.
2. FIELD VERIFY ALL EXISTING CONDITIONS PRIOR TO STARTING ANY WORK.
3. GENERAL CONTRACTOR IS RESPONSIBLE FOR FULL COMPLIANCE WITH GOVERNING CODES AND REGULATIONS, COORDINATION OF SUBCONTRACTORS, SAFETY AT THE SITE AND PROTECTION OF WORK COMPLETED.

REFLECTED
CEILING &
POWER
PLAN

A-1.2

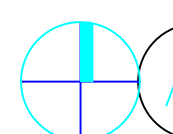

A1

REFLECTED CEILING & POWER PLAN

1/8" = 1'-0"

Xref \\SERVER-PC\Dropbox\01-PROJECTS CURRENT\18112_400 W Brewery\1-CD's\18112_24x36 (vertical) Titleblock.dwg