

**11274 Kestrel Rise RD.
South Jordan, Utah 84095**



SCALE: 1/4" = 1'-0"


5/8" GYPSUM BOARD

2x6 STUD @ 16" O.C.

5/8" GYPSUM BOARD

WALL TYPE

B

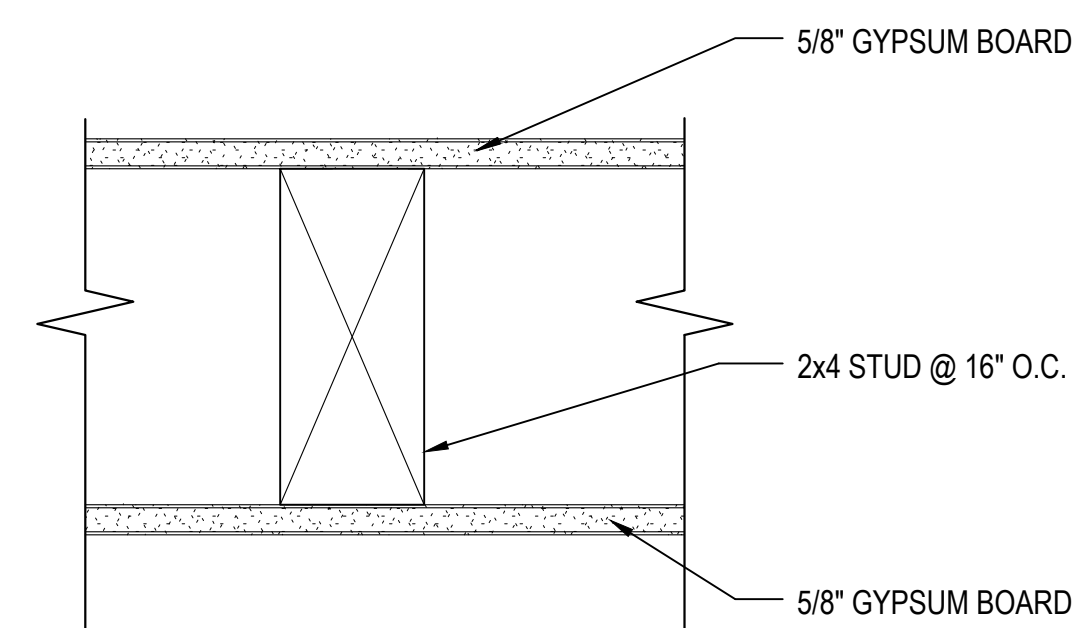

WALL TYPE

A



GO.0	COVER SHEET (THIS SHEET)
AD1.0	DEMO PLANS
A1.0	1ST FLOOR PLAN
A2.0	2ND FLOOR PLAN
A3.0	ENLARGED RESTROOM PLAN
A3.1	ENLARGED KITCHEN PLAN
A4.0	SECTIONS & DETAILS
A4.1	DETAILS
A5.0	FOOTING & FRAMING PLANS
A6.0	RESTROOM ELEVATIONS
E1.0	ELECTRICAL PLANS
FP1.0	FIRE PROTECTION PLAN

[illegible]

G0.0

Scale	NOTED
-------	-------

Summerwood Builders, Inc.
Phone: 801-520-6067
tony@summerwoodbuilders.com
summerwoodbuilders.com

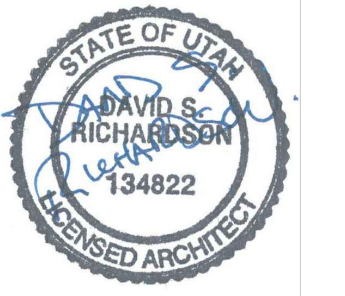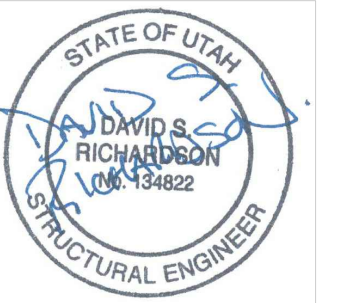


STAMPS



Summerwood Builders, Inc.
DESIGN-BUILD CONTRACTORS

Structural Engineer:

Sumnerwood Builders, Inc.
Phone: 801-520-6067
tony@sumnerwoodbuilders.com
sumnerwoodbuilders.com

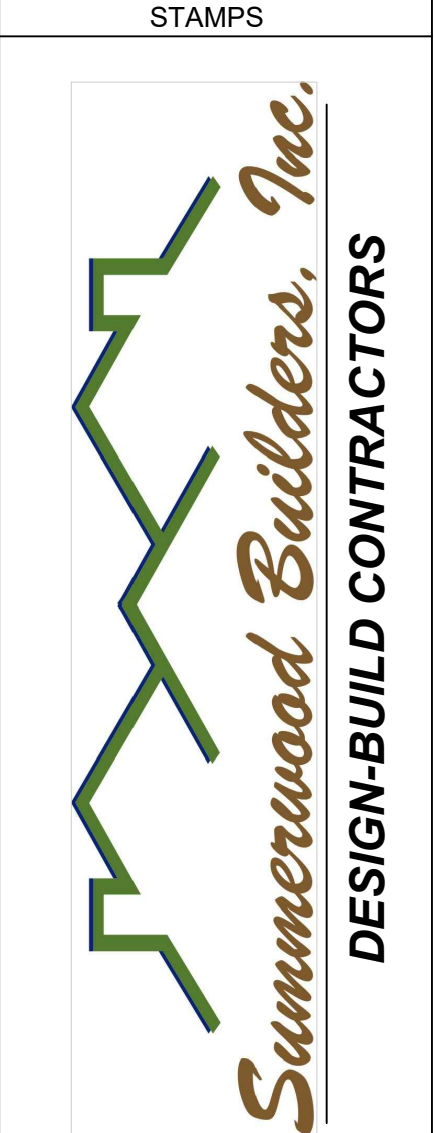


Structural Engineer:

THE BREAK SPORTS GRILL REMODEL	
DEMO PLANS	
Project number	20-002
Date	04/02/20
Drawn by	TW
Checked by	TW
AD1.0	
Scale	NOTED



Sumnerwood Builders, Inc.
Phone: 801-520-6067
tony@summerwoodbuilders.com
summerwoodbuilders.com

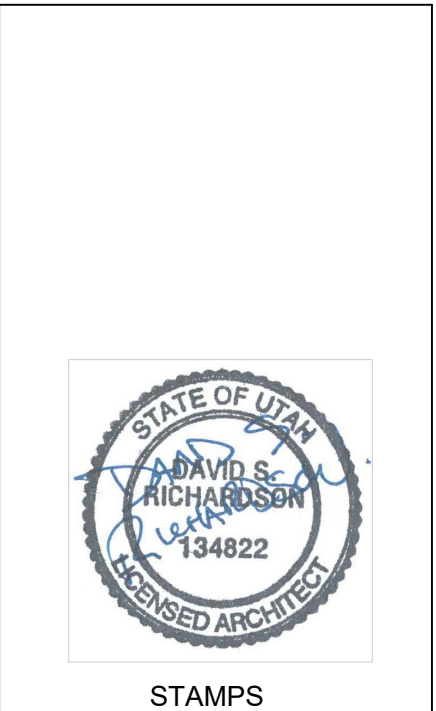



Structural Engineer:

[illegible]


THE BREAK SPORTS GRILL REMODEL

1ST FLOOR
PLAN

Project number	20-002
Date	04/02/20
Drawn by	TW
Checked by	TW

A1.0

Scale	NOTED
-------	-------


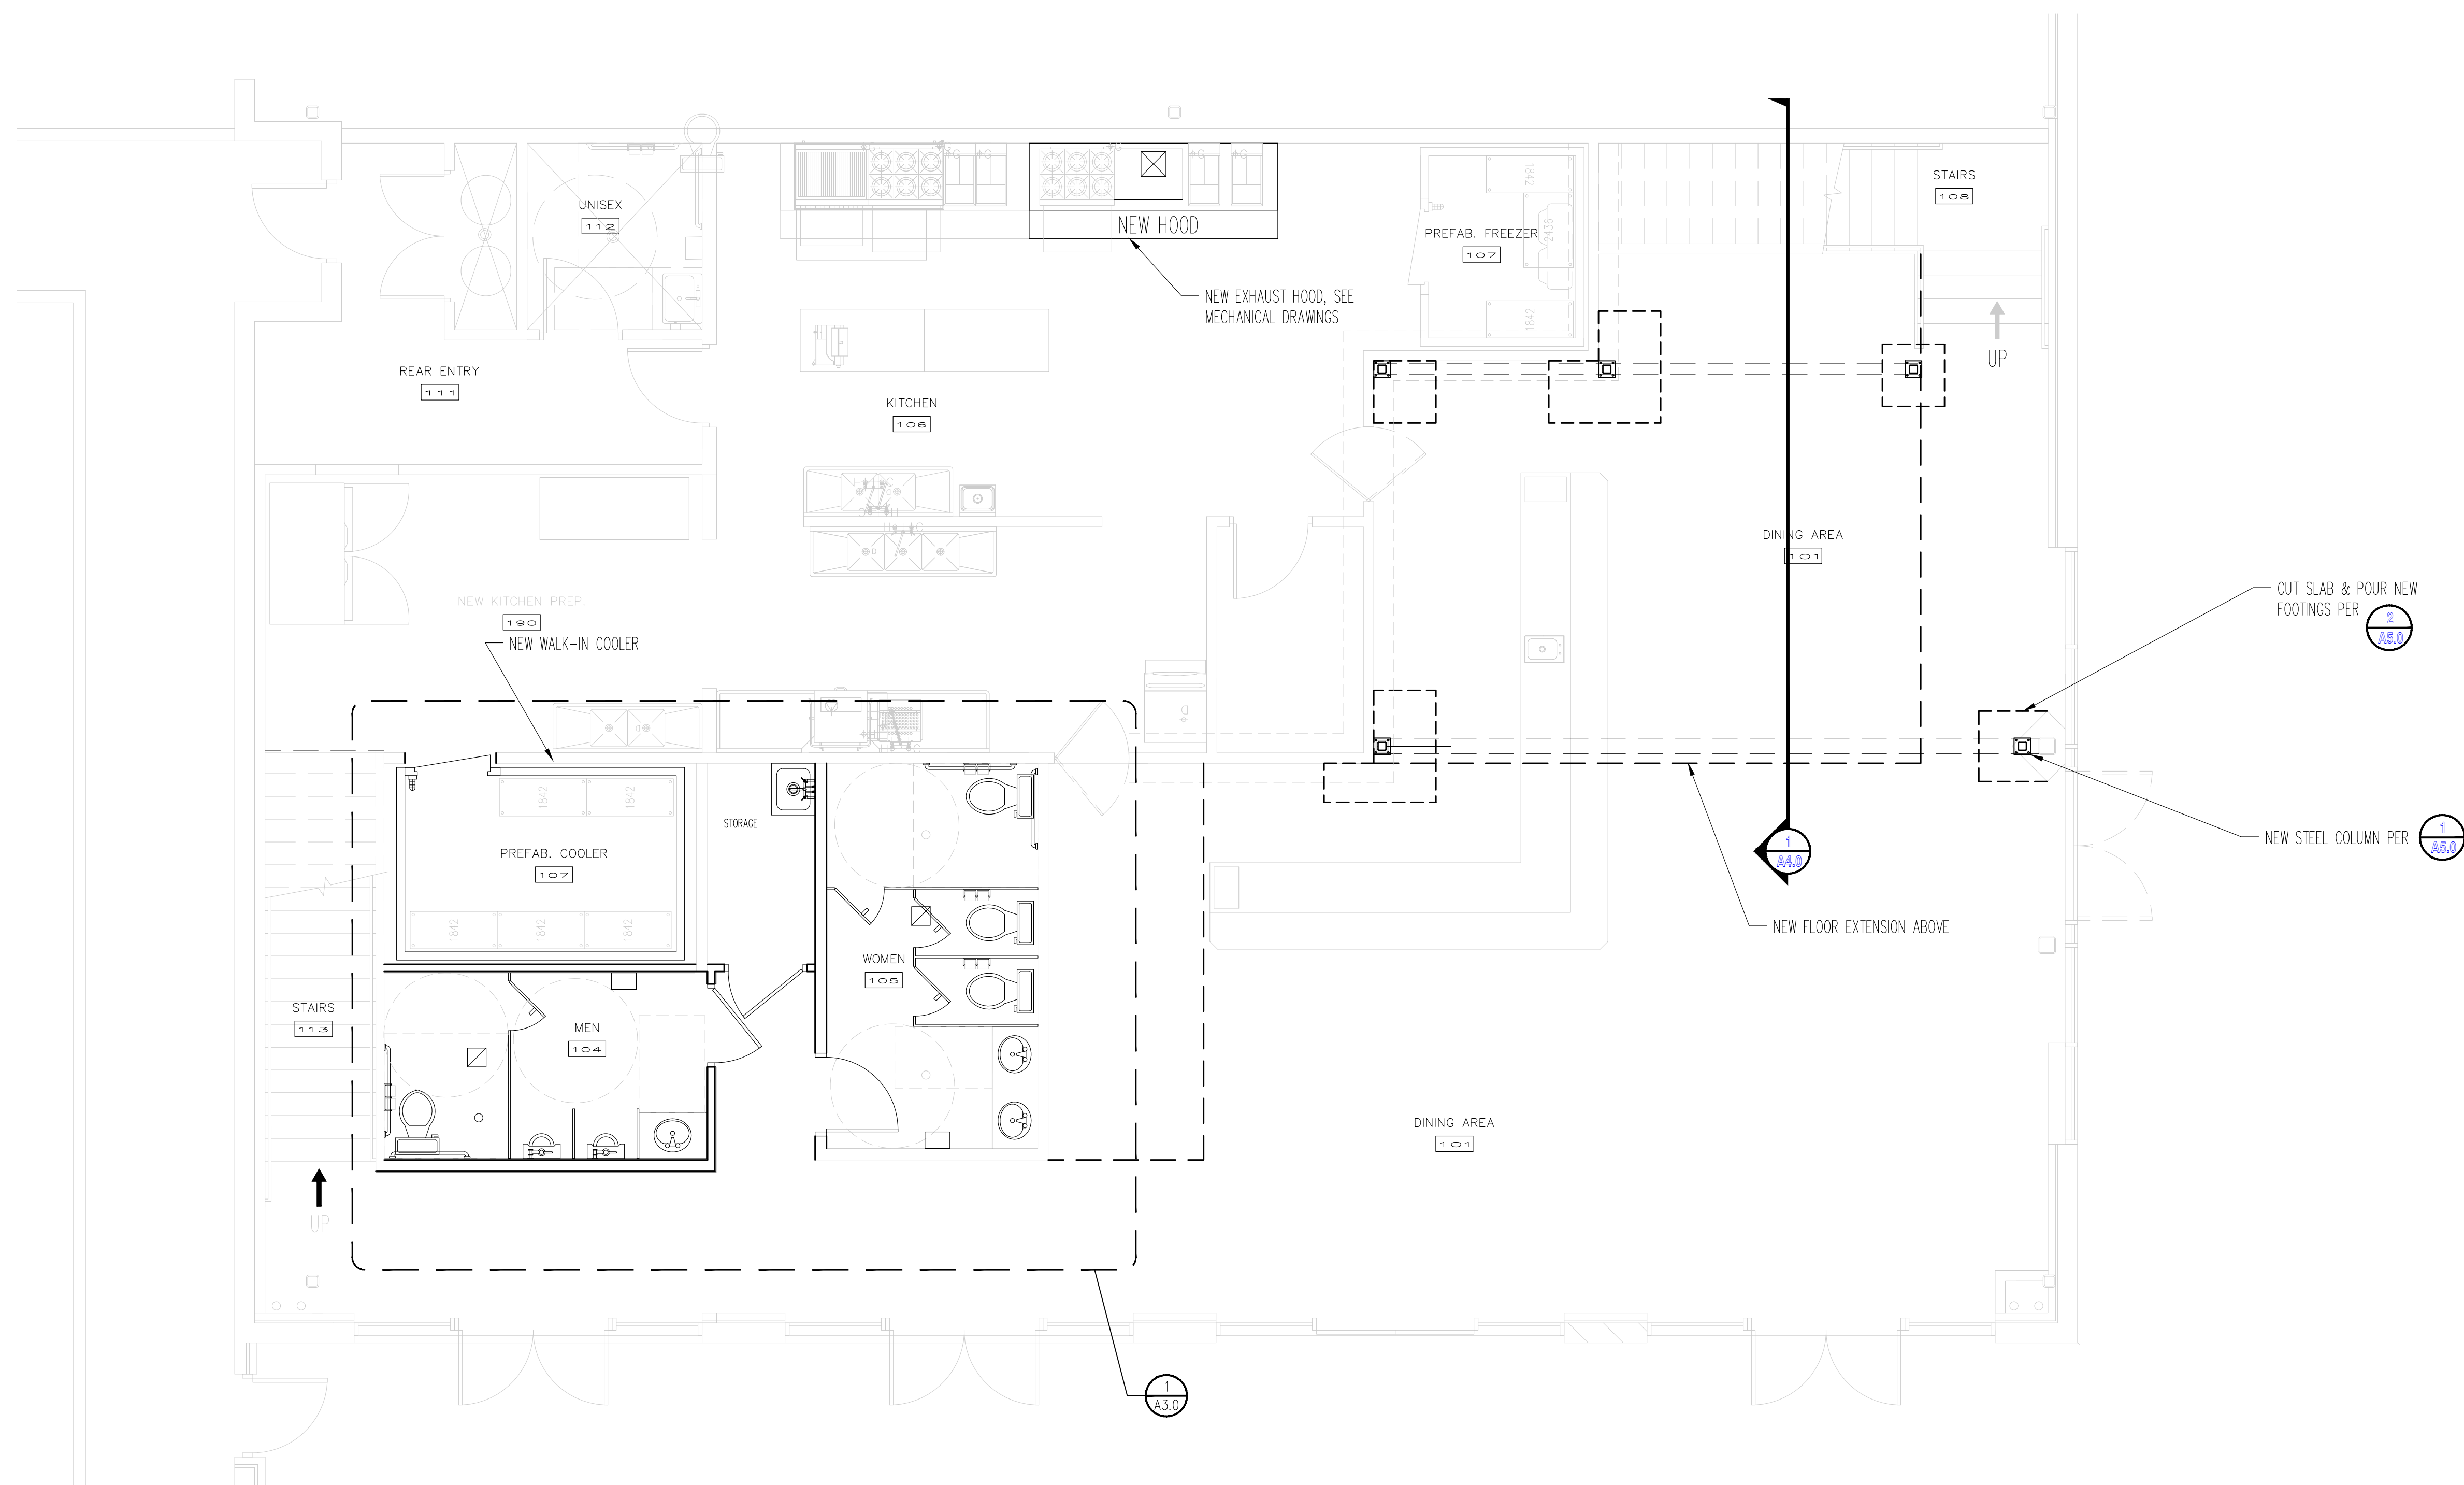



MAIN LEVEL FLOOR PLAN

SCALE: $1/4" = 1'-0"$

1


SCALE: $1/4" = 1'-0"$

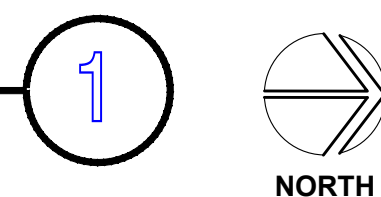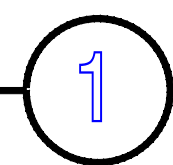

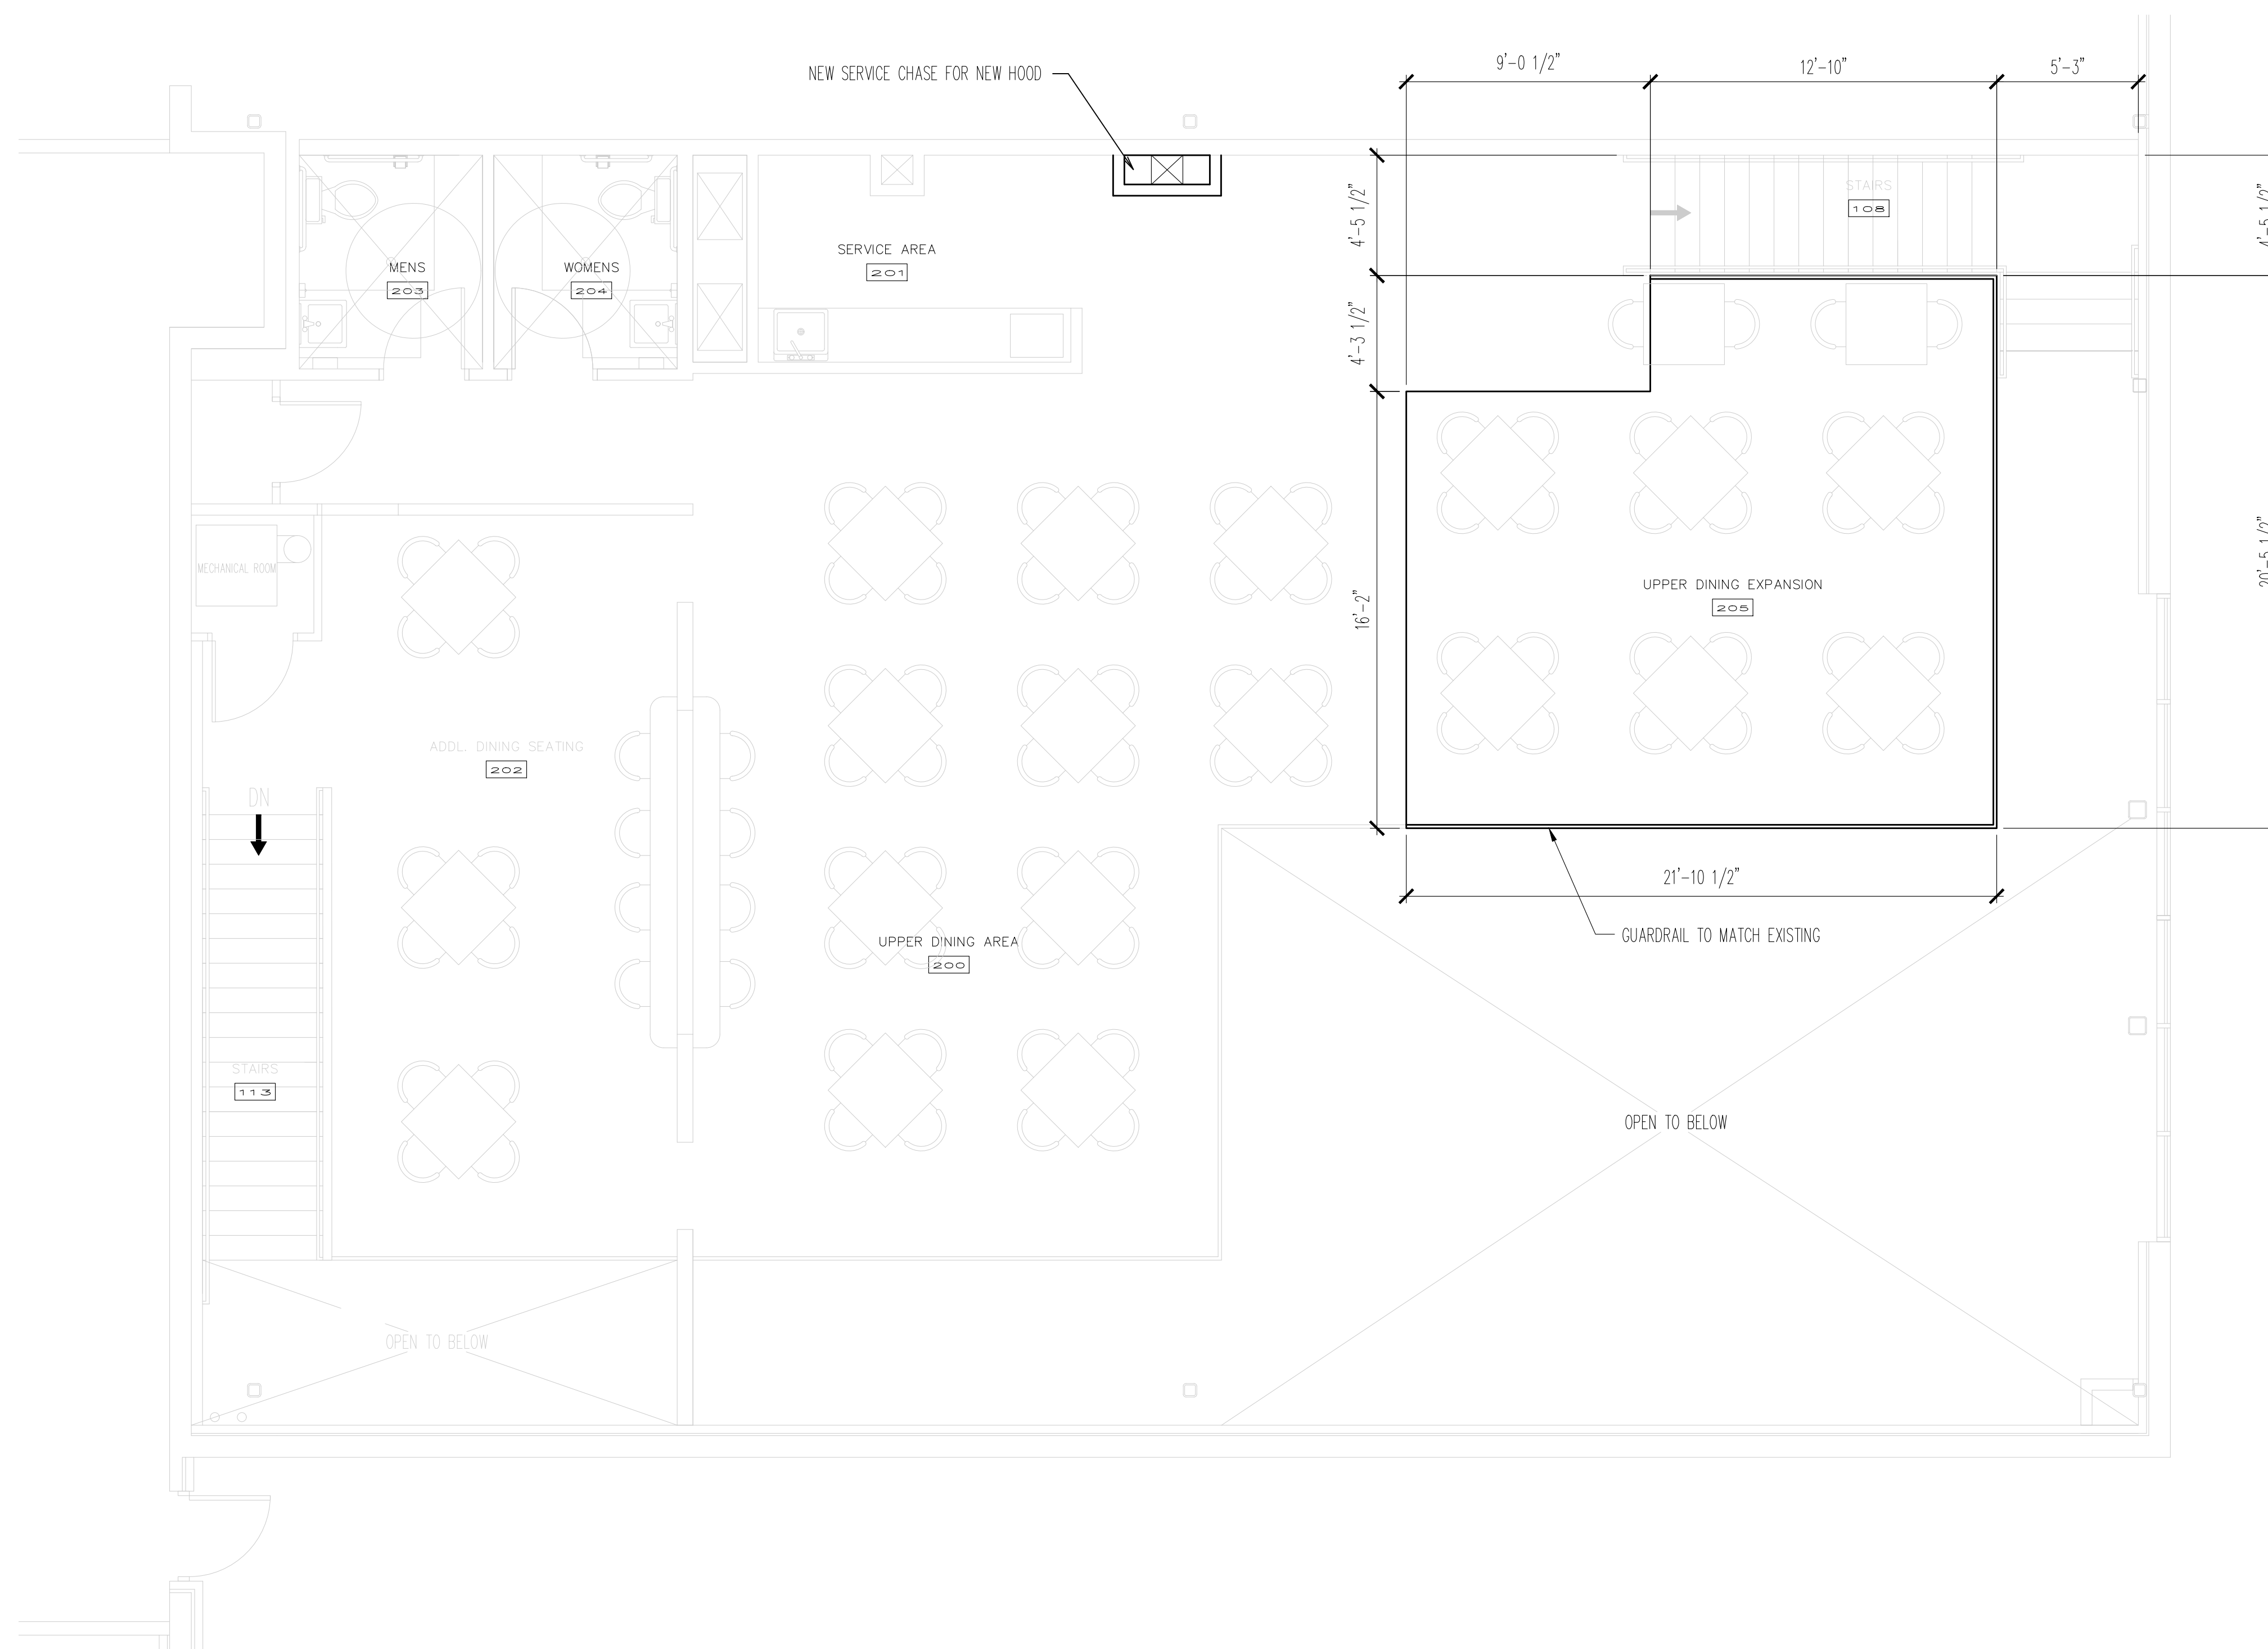


NORTH

Scale	NOTED
-------	-------


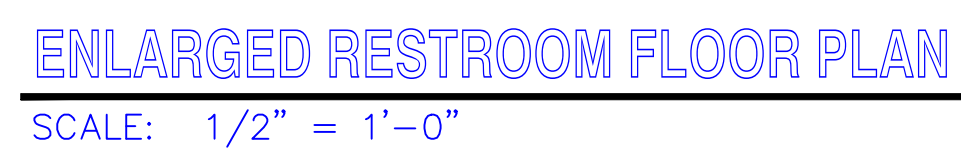


NORTH

Scale	NOTED
-------	-------

 

Summerwood Builders, Inc.
Phone: 801-520-6067
tony@summerwoodbuilders.com
summerwoodbuilders.com

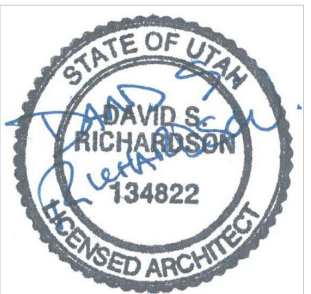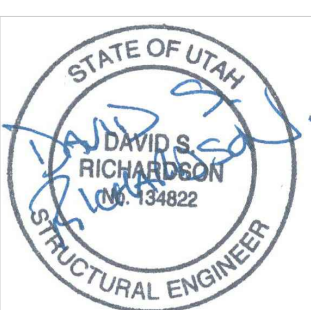

STAMPS



Structural Engineer:

[illegible]

THE BREAK SPORTS GRILL REMODEL

DETAILS

Project number	20-002
----------------	--------


Date	04/02/20
------	----------

Drawn by TW

Checked by TW


A4.1	
Scale	NOTED

Scale NOTED

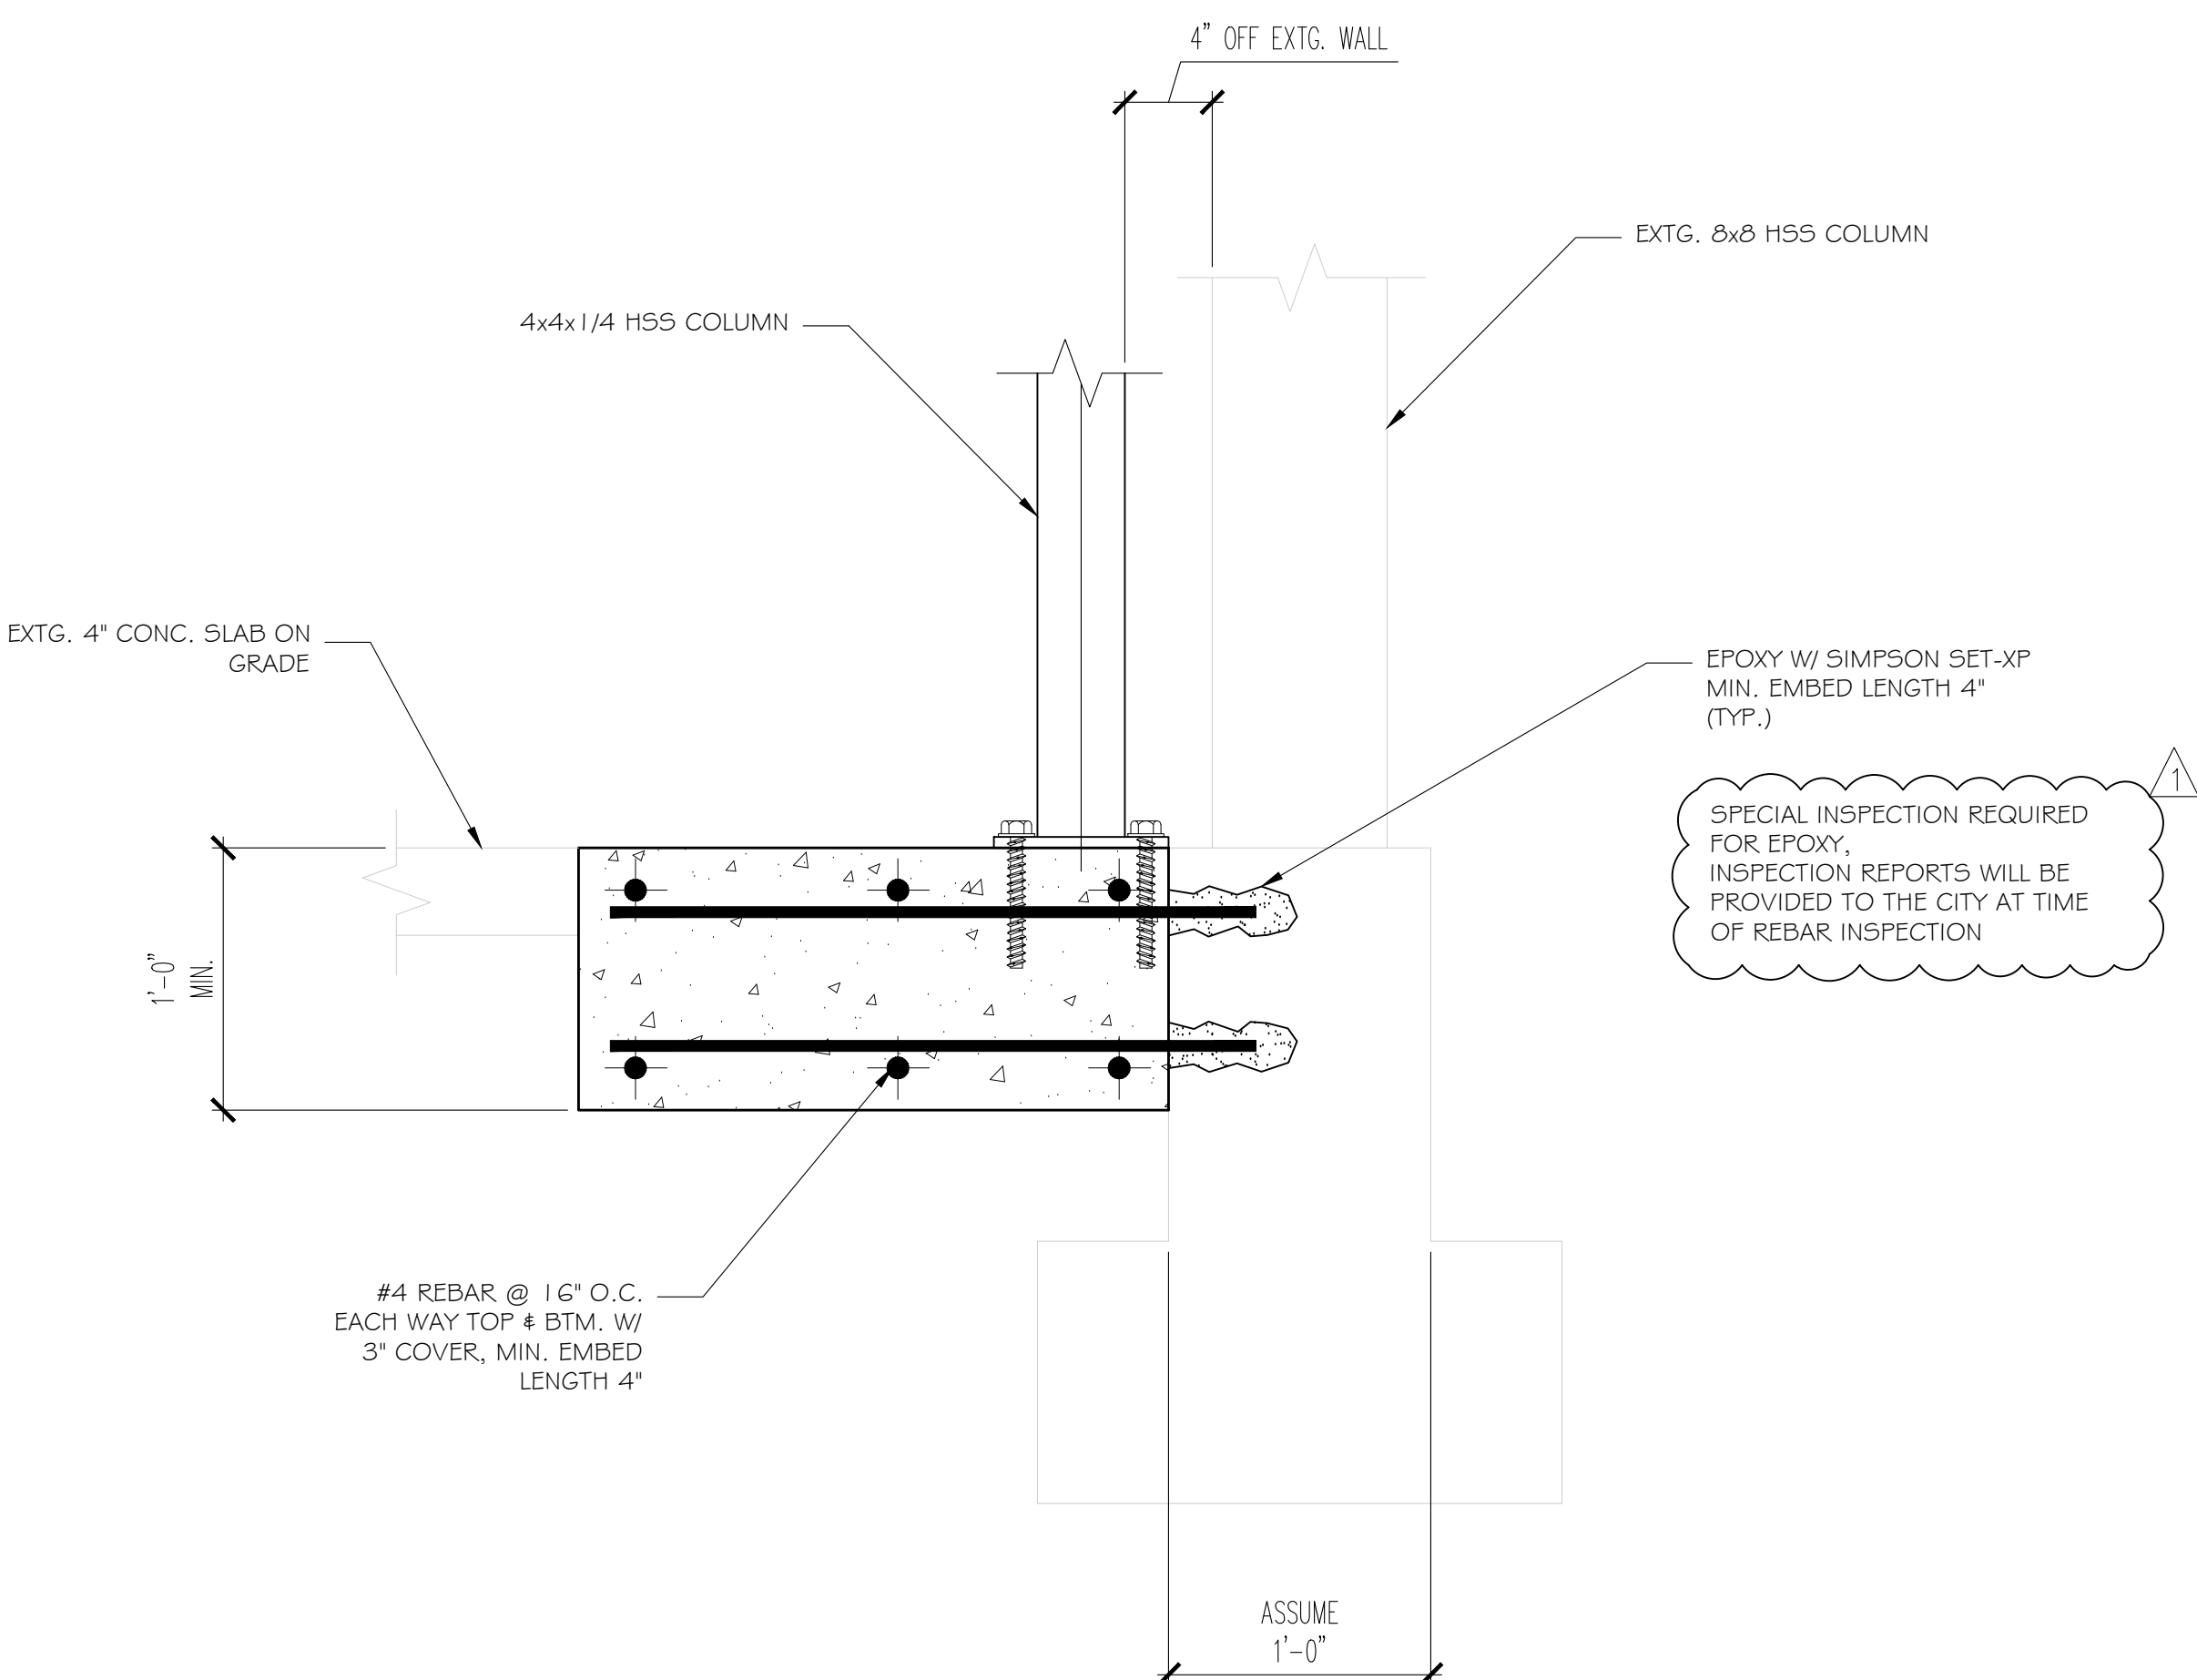


FOUNDATION DETAIL AT EXTERIOR WALL

SCALE: 1-1/2" = 1'-0"

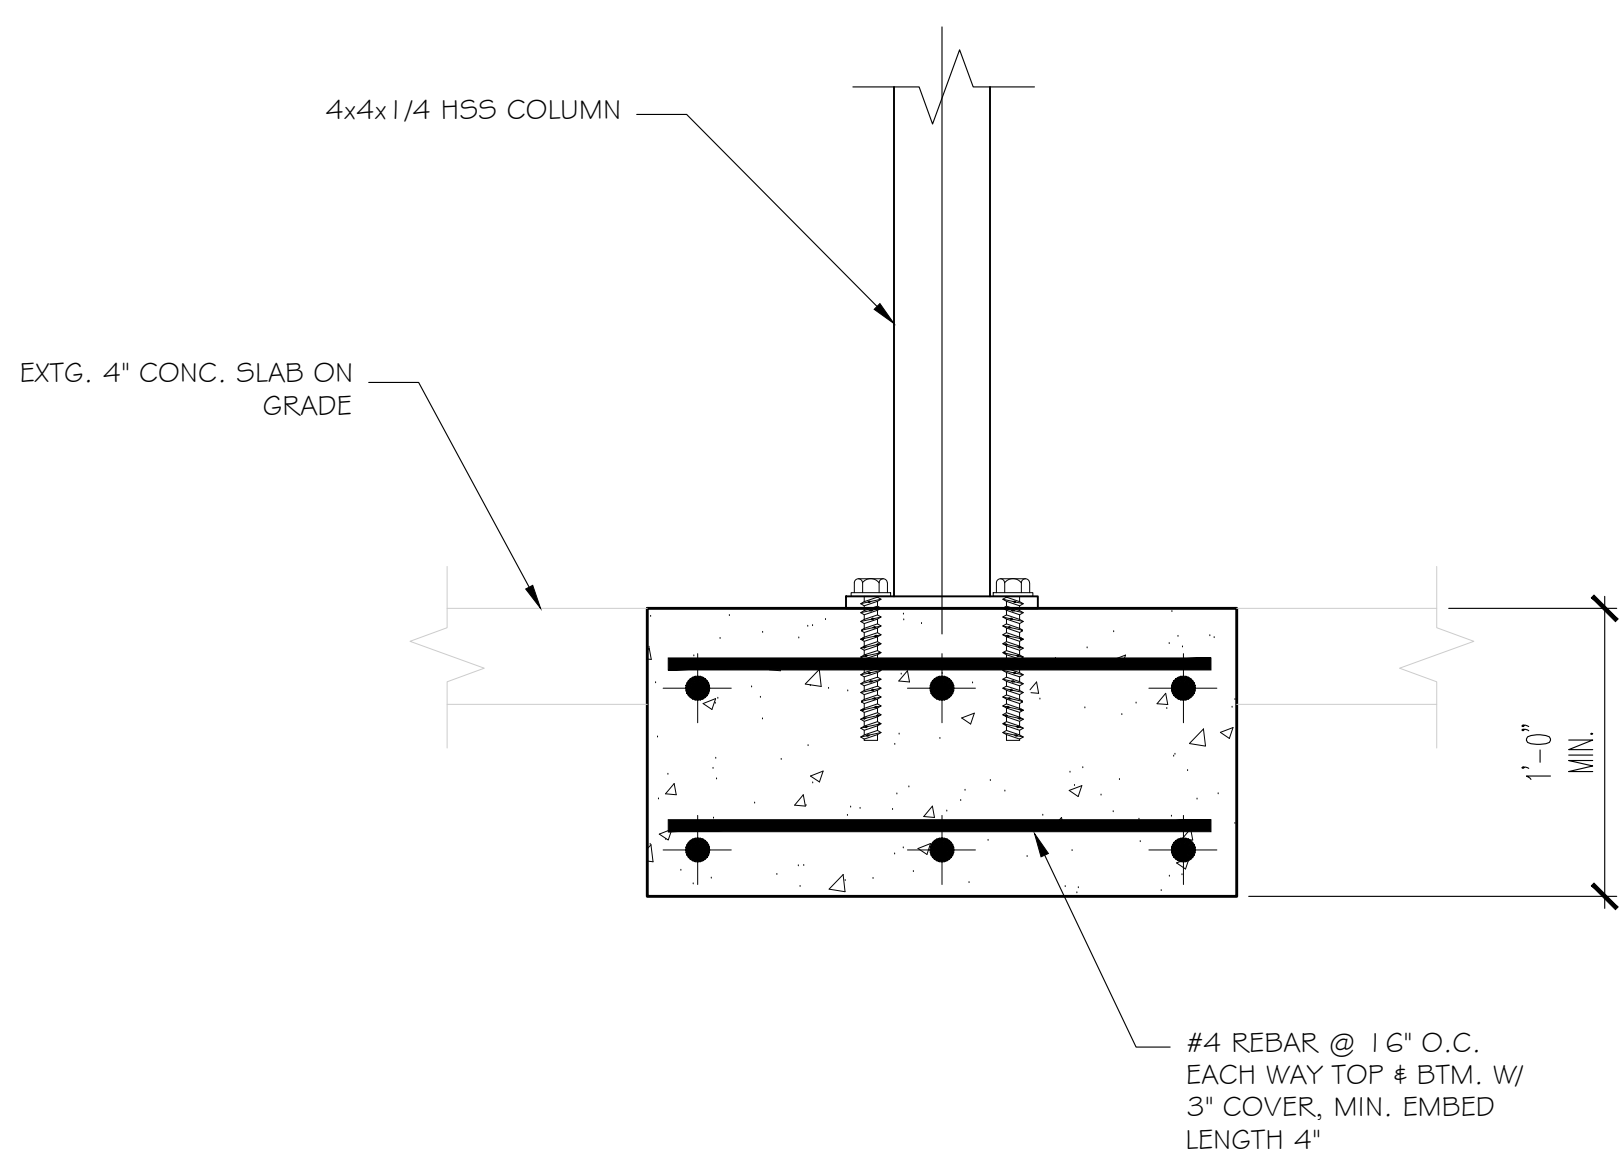

FOUNDATION DETAIL AT STAIRS



SCALE: 1-1/2" = 1'-0"

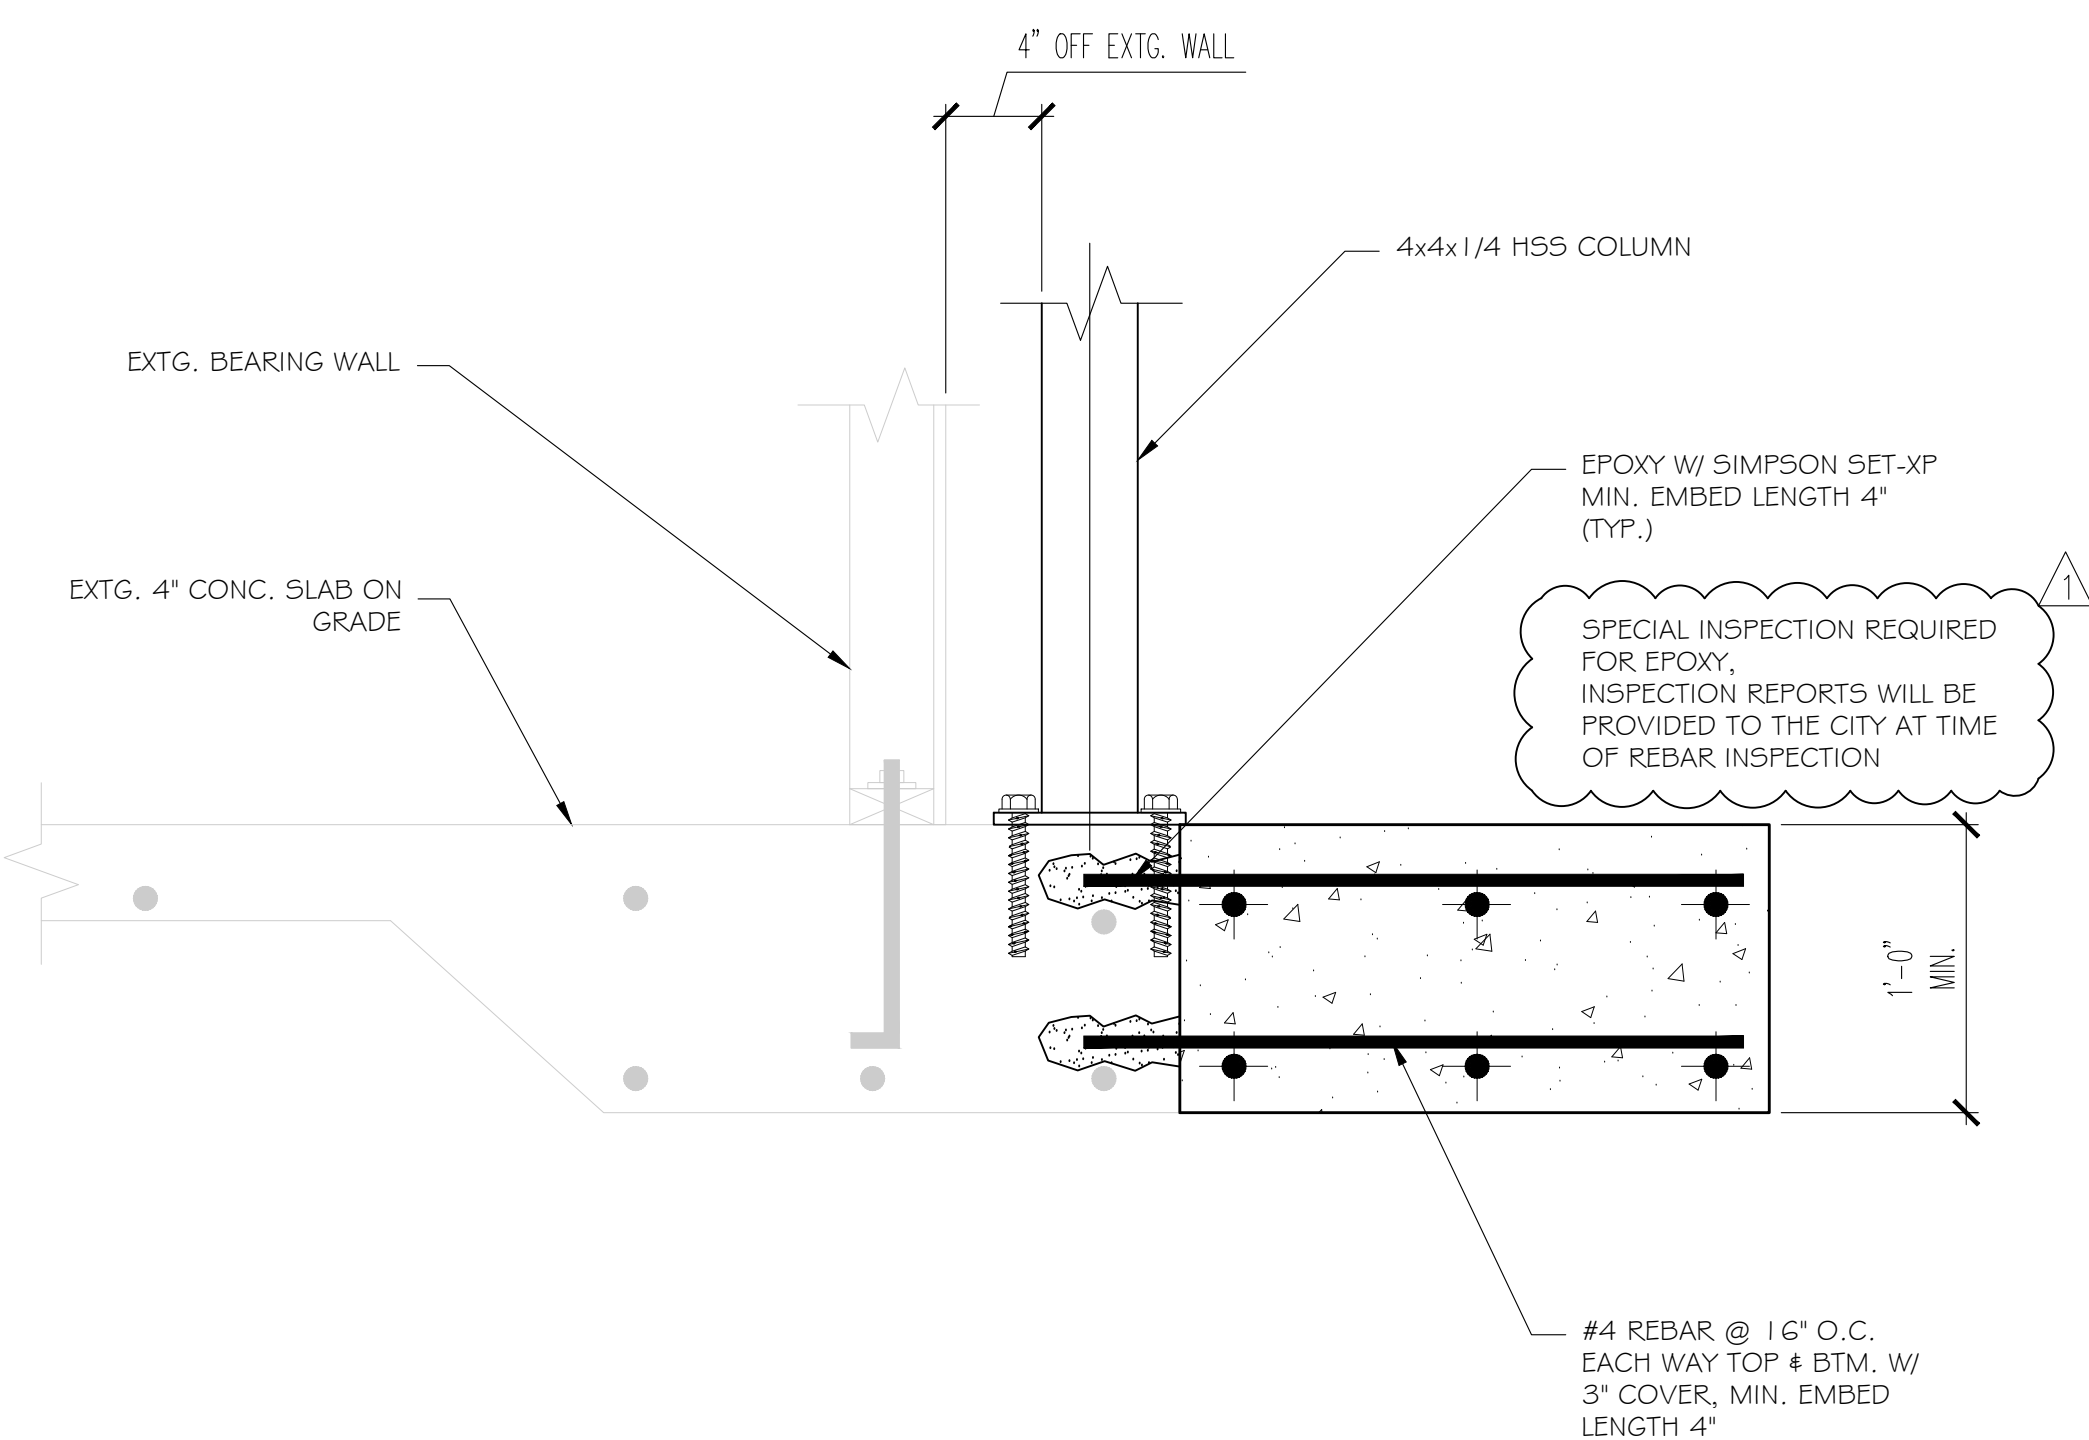

FOUNDATION DETAIL AT INTERIOR WALL

SCALE: $1-1/2" = 1'-0"$

Sumnerwood Builders, Inc.
Phone: 801-520-6067
tony@summerwoodbuilders.com
summerwoodbuilders.com

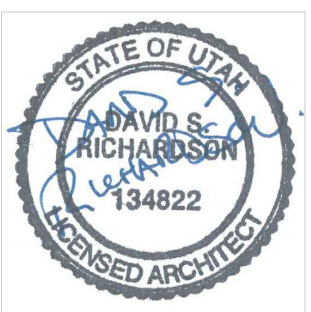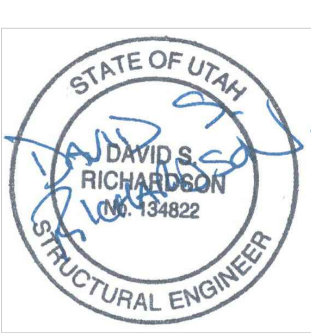

Structural Engineer:


[illegible]

THE BREAK SPORTS GRILL REMODEL

FOOTING &
FRAMING
PLANS

Project number	20-002
Date	04/02/20
Drawn by	TW
Checked by	TW



A5.0	
Scale	NOTED

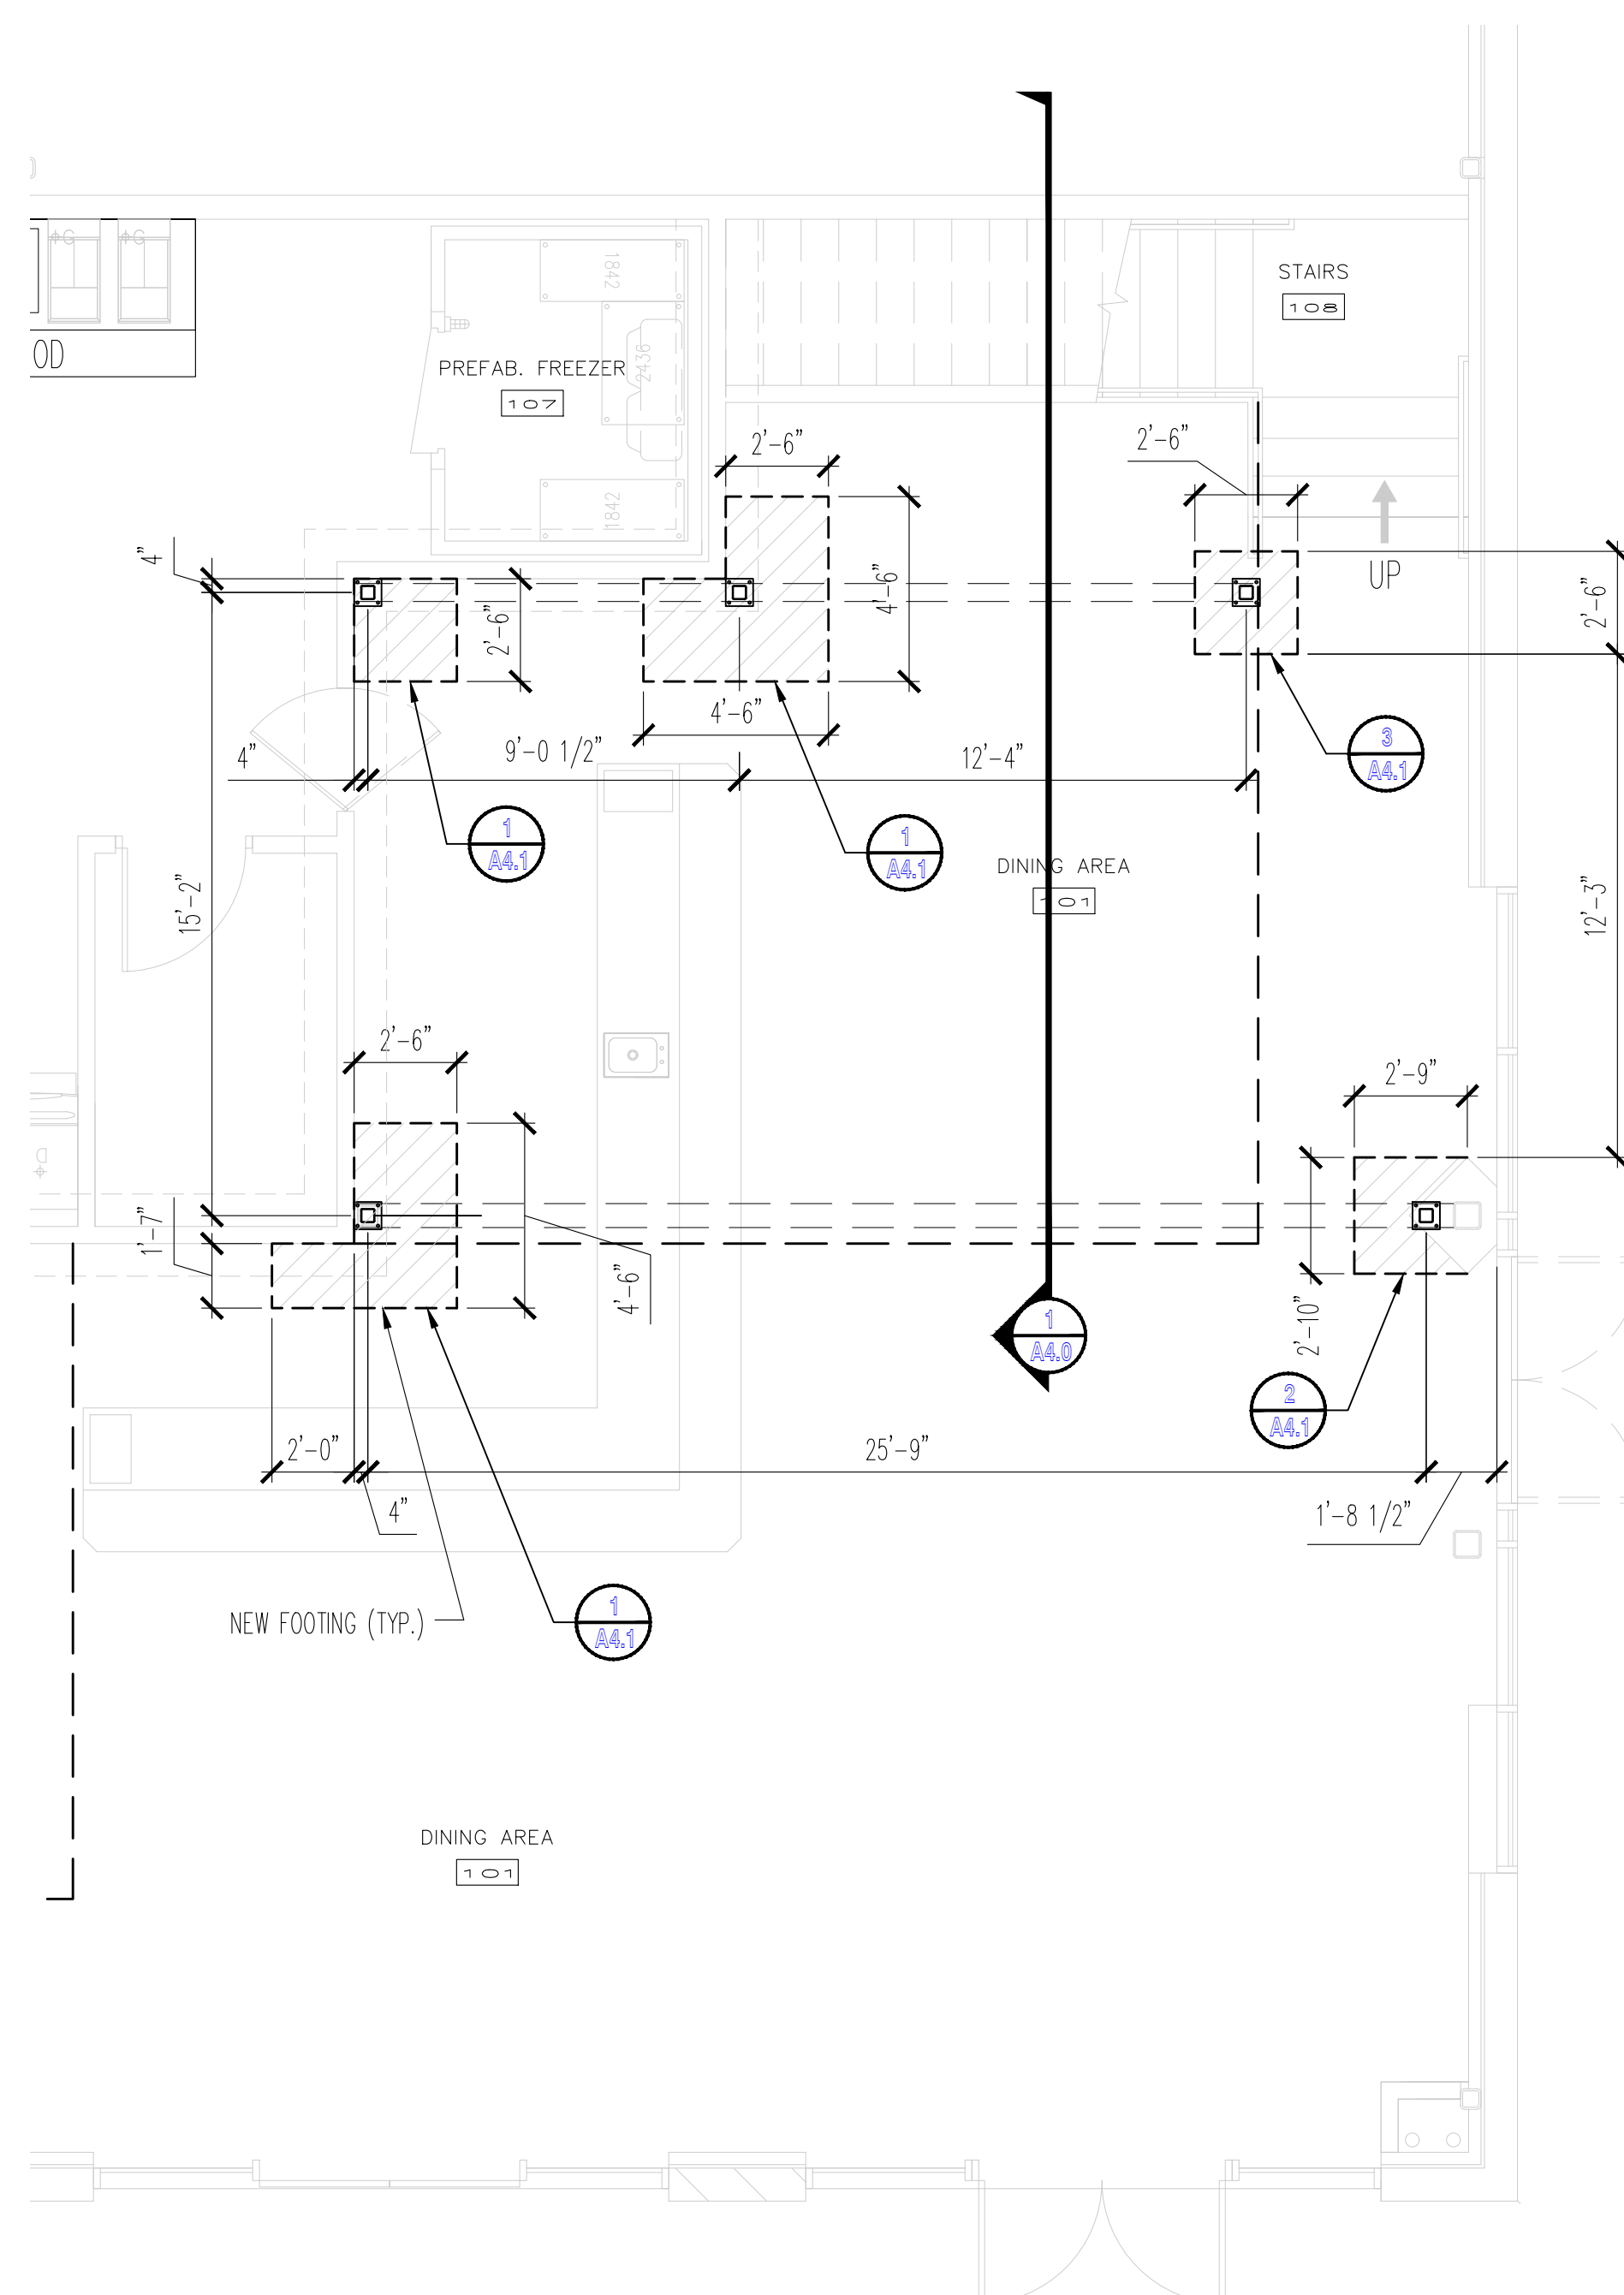

FOOTING PLAN

SCALE: 1/4" = 1'-0"


2

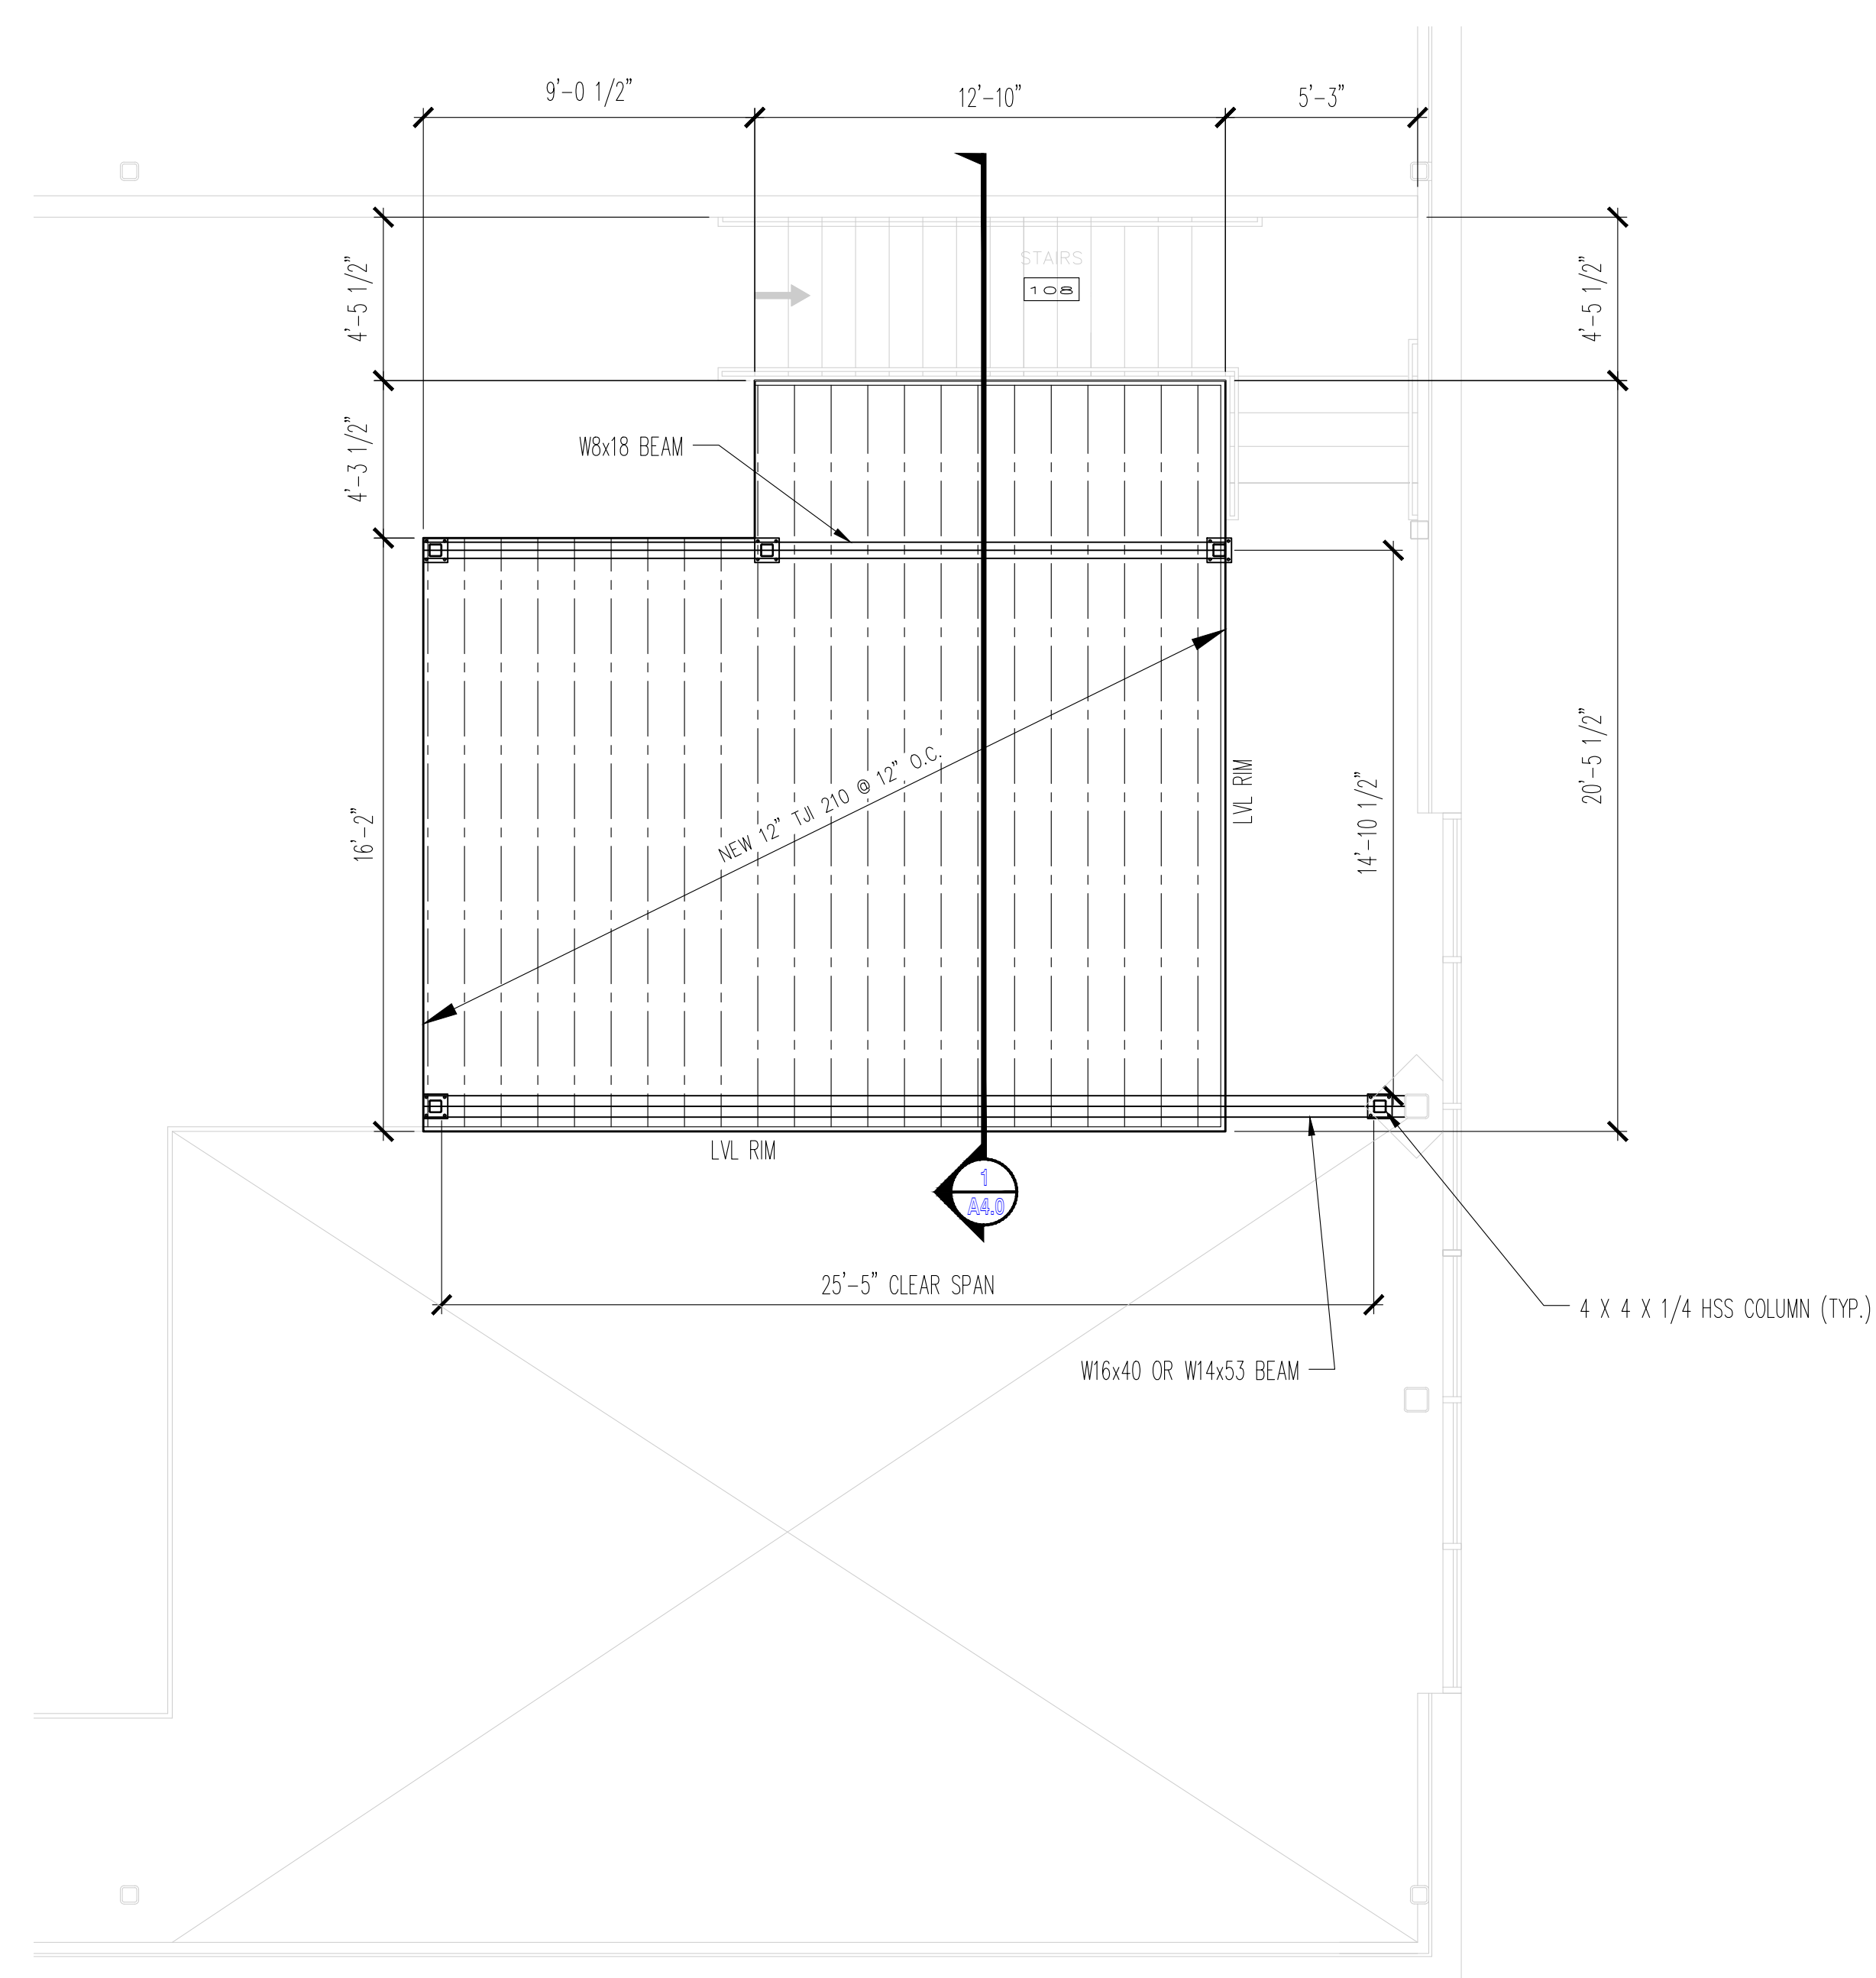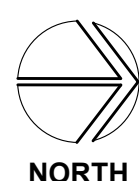

UPPER LEVEL FLOOR FRAMING PLAN


SCALE: 1/4" = 1'-0"

1

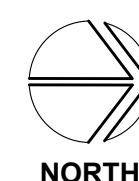


THE BREAK SPORTS GRILL REMODEL	
FOOTING & FRAMING PLANS	
Project number	20-002
Date	04/02/20
Drawn by	TW
Checked by	TW
A5.0	
Scale	NOTED

Structural Engineer:

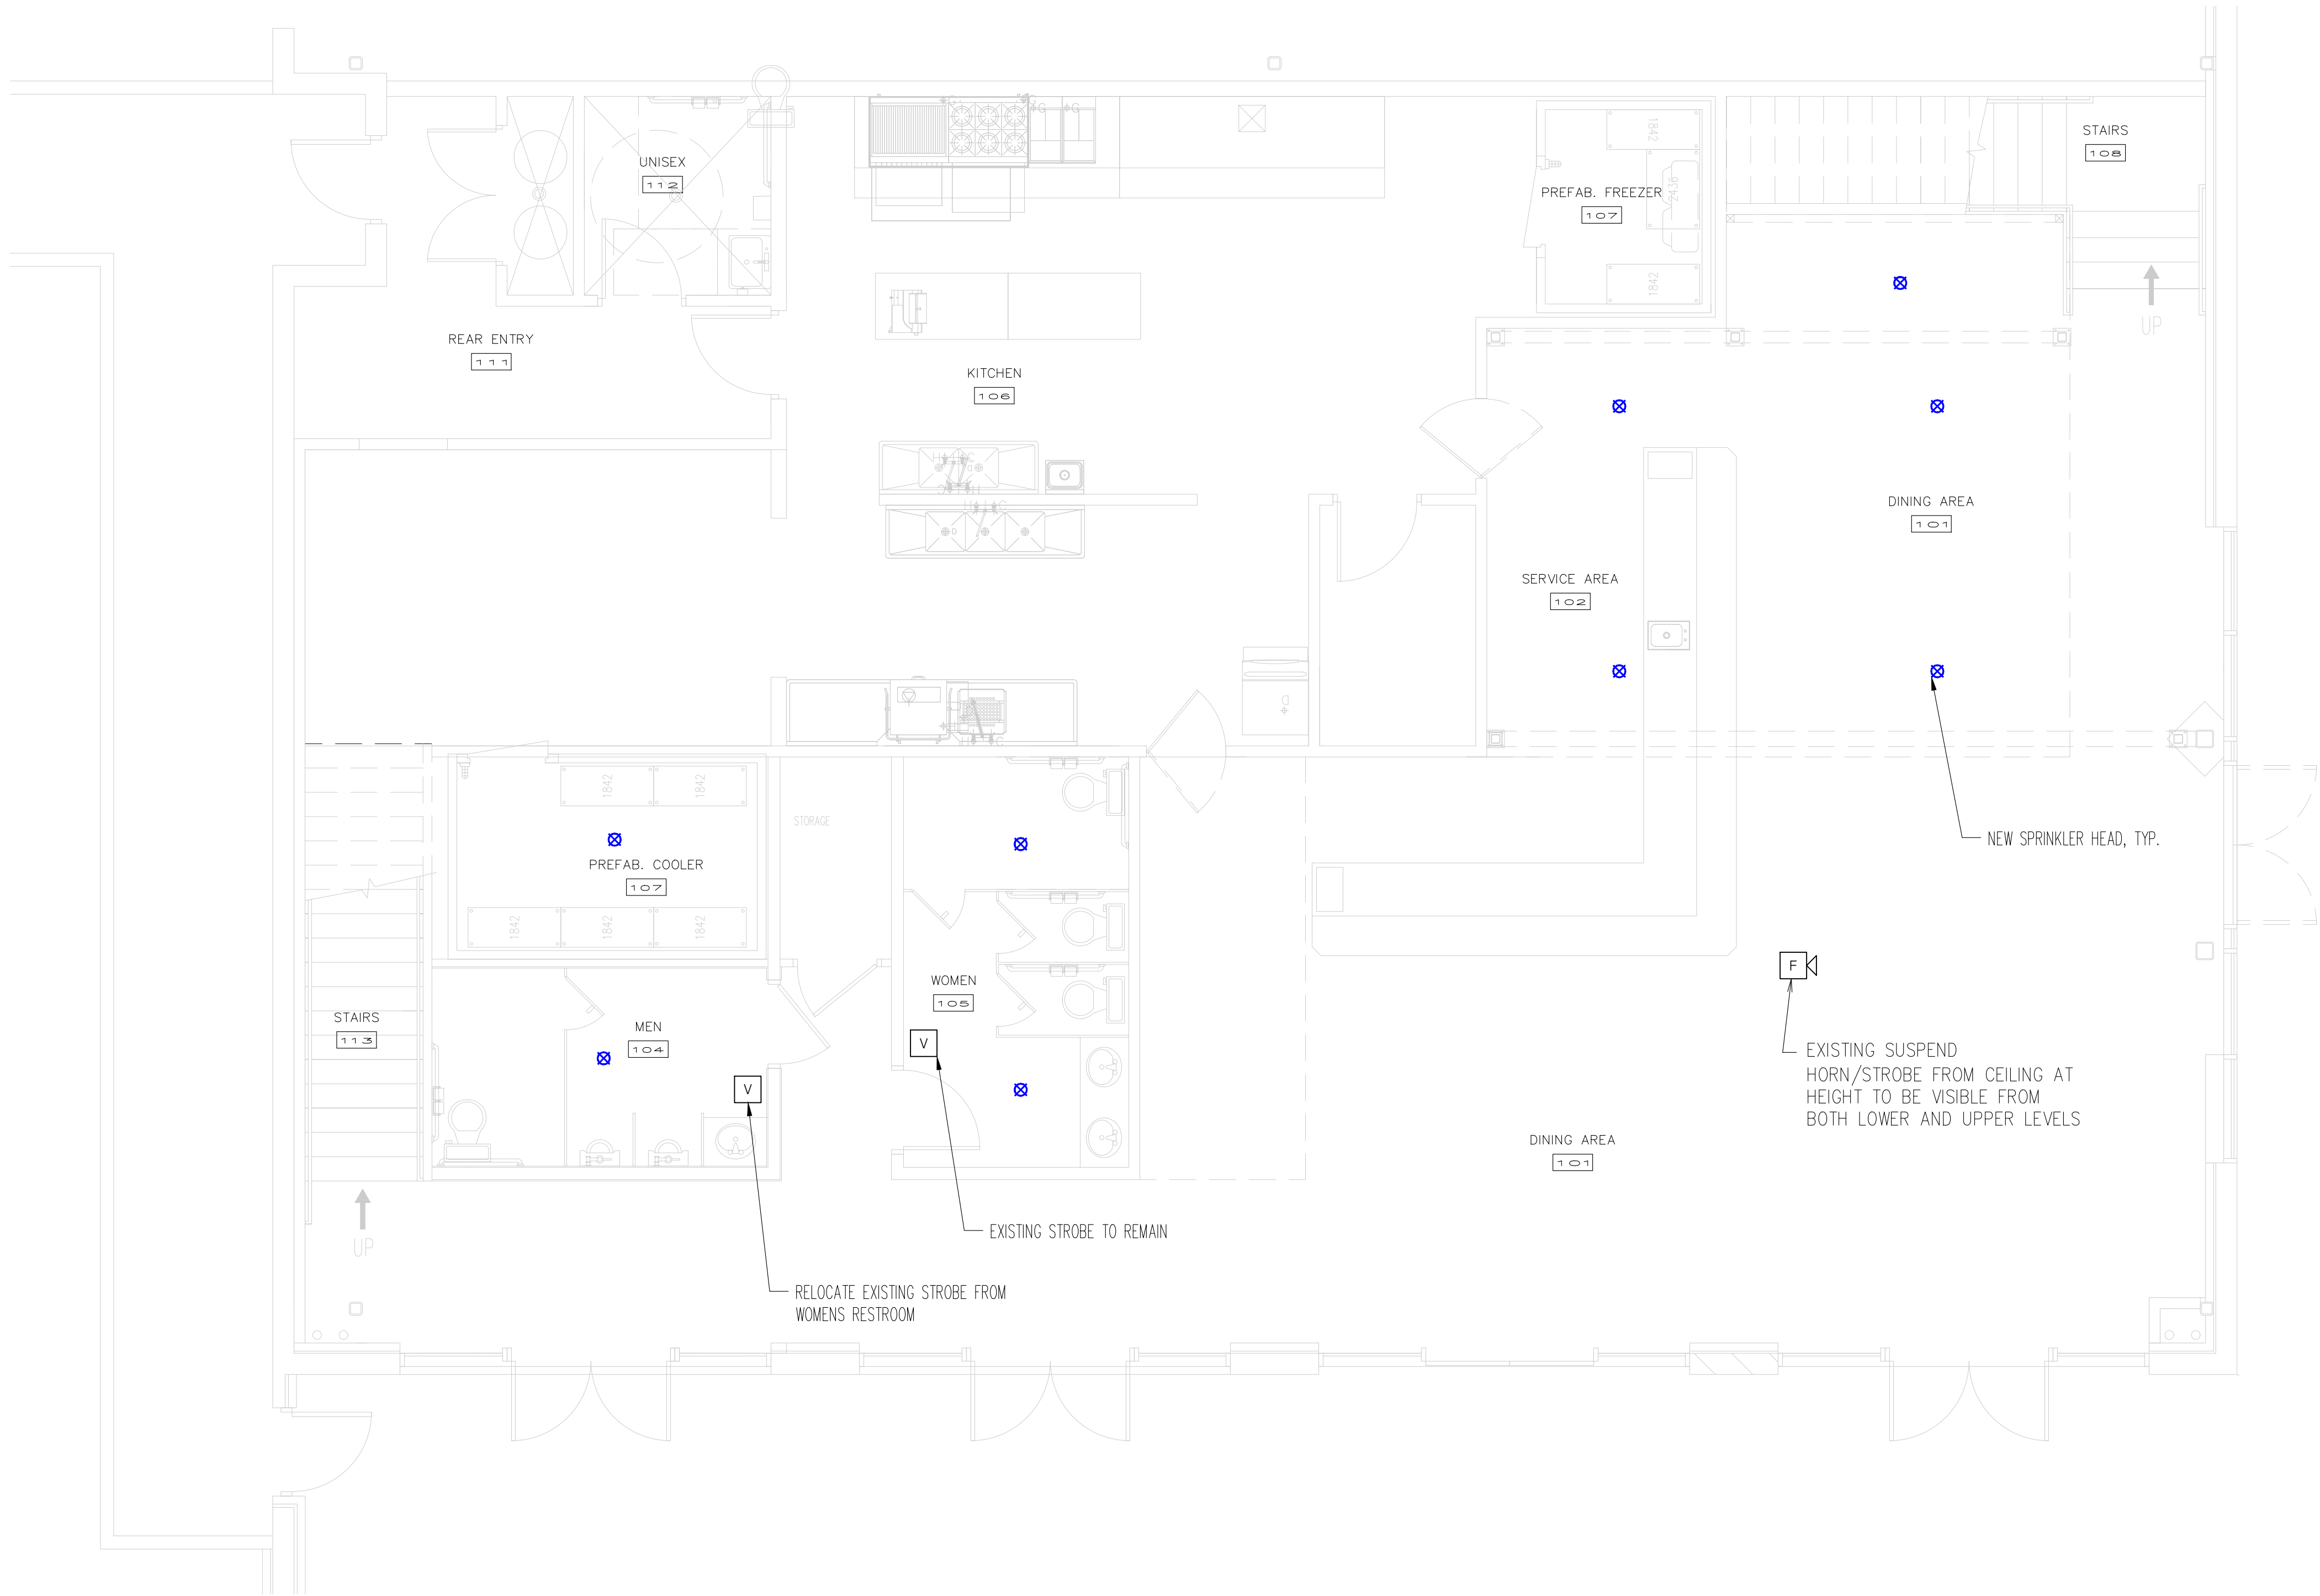

MAIN LEVEL FIRE PROTECTION PLAN
SCALE: 1/4" = 1'-0"

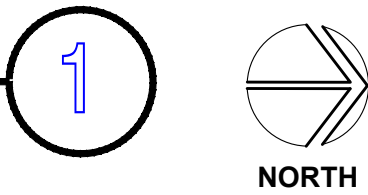

FIRE PROTECTION SYMBOLS	
	HORN/STROBE
	STROBE ONLY
	SPRINKLER HEAD

NOTE: NO WORK ON UPPER LEVEL

Summerwood Builders, Inc.
Phone: 801-520-6067
tony@summerwoodbuilders.com
summerwoodbuilders.com

STAMPS

DESIGN-BUILD CONTRACTORS

Structural Engineer:

No.	Description	Date
1	PLAN REVIEW COMMENTS	7/15/20

THE BREAK SPORTS GRILL REMODEL

FIRE PROTECTION PLAN

Project number	20-002
Date	04/02/20
Drawn by	TW
Checked by	TW

FP1.0

Scale	NOTED
-------	-------