


ATH 'STATION PARK' - LIGHTING CODED NOTES SCHEDULE							
Coded Note	Mark	Type	Manufacturer/Model	Color	Mount Height	Use	Notes
101	MS		LEVITON OSSMT-MDW	White	See Arch Dwgs for restroom, For platform mount at 48" above platform	Auto Shutoff	Set for 15 minutes
102	BB	From TCS BAYSYS. See M8-0		White	48" AFF	Shutoff override	Set for 2 hours
200	Install and wire light fixture on two circuit track lower circuit, (circuit #1)						
201	J-box & switch	4" Round x 1-1/2" Deep		Grey	See Arch Dwgs	Exterior Signage	Provide AC toggle switch
203	Install shaded fixtures on two circuit track upper circuit, (circuit #2), and non-shaded fixtures on two circuit track lower circuit, (circuit #1).						
300	P	Photocell			Roof mounted to RTU-1	Exterior lighting control	

ATHLETA 'STATION PARK' - LIGHT FIXTURE SCHEDULE												
TAG	MANUFAC TURER	FIXTURE CATALOG NUMBER	DESCRIPTION	SKU#	LAMP CATALOG NUMBER	DESCRIPTION	SKU#	LOCATION	BALLAST MANUF ACTURER	LAMP WATTS	ACTUAL WATTS	VOLTS
P601M	CON-TECH LIGHTING	CYL6-3-30K-MVD-FC-M-PL-P	PENDANT CYLINDER WITH FLEXIBLE CABLE, MEDIUM BEAM OPTICS		INCLUDED WITH FIXTURE	3000K INTEGRAL LED	N/A	FIT ROOM	N/A	20	20	120
P601W	CON-TECH LIGHTING	CYL6-3-30K-MVD-FC-W-PL-P	PENDANT CYLINDER WITH FLEXIBLE CABLE, WIDE BEAM OPTICS		INCLUDED WITH FIXTURE	3000K INTEGRAL LED	N/A	FIT ROOM	N/A	20	20	120
T101	CON-TECH LIGHTING	LT28S SERIES	TWO CIRCUIT SILVER TRACK 2FT	LT22S	N/A	N/A	N/A	SALES FLOOR	N/A	N/A	N/A	120
			TWO CIRCUIT SILVER TRACK 4FT	LT24S								
			TWO CIRCUIT SILVER TRACK 6FT	LT26S								
			TWO CIRCUIT SILVER TRACK 8FT	LT28S								
			TWO CIRCUIT SILVER END FEED	LA210S								
T115C	CON-TECH LIGHTING	CTL603AS-12W MAX LBL (SILVER + SILVER LED)	TRACK MOUNTED UNIVERSAL PAR LAMP HOLDER WITH SIDE SWIVEL SILVER	CTL603AS12W	CREE PAR30S-75-P1-30K-25NF-E26	PAR30S 3000K NFL WHITE BODY		SALES FLOOR	N/A	12	12	120
			TWO CIRCUIT WHITE TRACK 2FT	LT22P								
			TWO CIRCUIT WHITE TRACK 4FT	LT24P								
			TWO CIRCUIT WHITE TRACK 6FT	LT26P								
			TWO CIRCUIT WHITE TRACK 8FT	LT28P								
T107	CON-TECH LIGHTING	LT28P SERIES	TWO CIRCUIT WHITE TRACK 8FT	LT28P	N/A	N/A	N/A	STOREFRONT	N/A	N/A	N/A	120
			TWO CIRCUIT WHITE END FEED	LA210P								
			TWO CIRCUIT WHITE L CONN	LA212P								
			TWO CIRCUIT WHITE CONNECTOR	LA202P								
T116C	CON-TECH LIGHTING	CTL603AP-12W MAX LBL	TRACK MOUNTED UNIVERSAL PAR LAMP HOLDER WITH SIDE SWIVEL WHITE	CTL603AP12W	CREE PAR30S-75-P1-30K-25NF-E26	PAR30S 3000K NFL WHITE BODY		STOREFRONT	N/A	12	12	120
K1	KICHLER	420460Z	EVERLY PENDANT IN OLDE BRONZE FOR 1 LAMP WITH CLEAR GLASS	273264S	AAMSCO LED-4W-ST64-HYBRID-DIM	LED FILAMENT BULB		CASHWRAP	N/A	100	40	120
L300	BARTCO	IPR8S-32W-U-IS-F-SM-WH	SURFACE FLUORESCENT LINEAR 4' FIXTURE		(1) F32T8/ADV830/2XL/ALTO 25 WATT	3000K	N/A	HALLWAY/REST ROOM	INCL	28	28	120/277
L300EM	BARTCO	IPR8S-32W-U-IS-F-SM-WH-EM	SURFACE FLUORESCENT LINEAR 4' FIXTURE WITH EM PACK		(1) F32T8/ADV830/2XL/ALTO 25 WATT	3000K	N/A	HALLWAY/REST ROOM	INCL	28	28	120/277
F4W	MERCURY	MM232-OCT-C-ELB-UNI/WGMM232	4' FLUORESCENT STRIP 2 ROWS T8		(2) F32T8/ADV830/2XL/ALTO 25 WATT	3000K	N/A	STOCKROOM	INCL	64	64	120/277
F4WE	MERCURY	MM232-OCT-C-ELB-UNI-I320EM/WGMM232	4' FLUORESCENT STRIP 2 ROWS T8 WITH EM PACK		(2) F32T8/ADV830/2XL/ALTO 25 WATT	3000K	N/A	STOCKROOM	INCL	64	64	120/277
F8W	MERCURY	MM232-OCT/8T-C-ELB-UNI/(2)WGMM232	4' FLUORESCENT STRIP 2 ROWS T8		(4) F32T8/ADV830/2XL/ALTO 25 WATT	3000K	N/A	STOCKROOM	INCL	128	128	120/277
F8WE	MERCURY	MM232-OCT/8T-C-ELB-UNI-I320EM/(2)WGMM232	4' FLUORESCENT STRIP 2 ROWS T8		(4) F32T8/ADV830/2XL/ALTO 25 WATT	3000K	N/A	STOCKROOM	INCL	128	128	120/277
X200	SURELITE	CU2-LED	EMERGENCY		N/A	N/A	N/A	SALES	N/A	5	5	120/277
X104	CON-TECH LIGHTING	REXA-SF-R-EM-P SINGLE FACE REXA-MF-R-EM-P MULIFACE	UNIVERSAL MOUNT EDGELITE EXIT SINGLE OR DOUBLE FACE RED LETTERS WITH BATTERY BACKUP, WHITE FINISH		2.3W	N/A	N/A	SALES FOOR	N/A	5	5	120/277

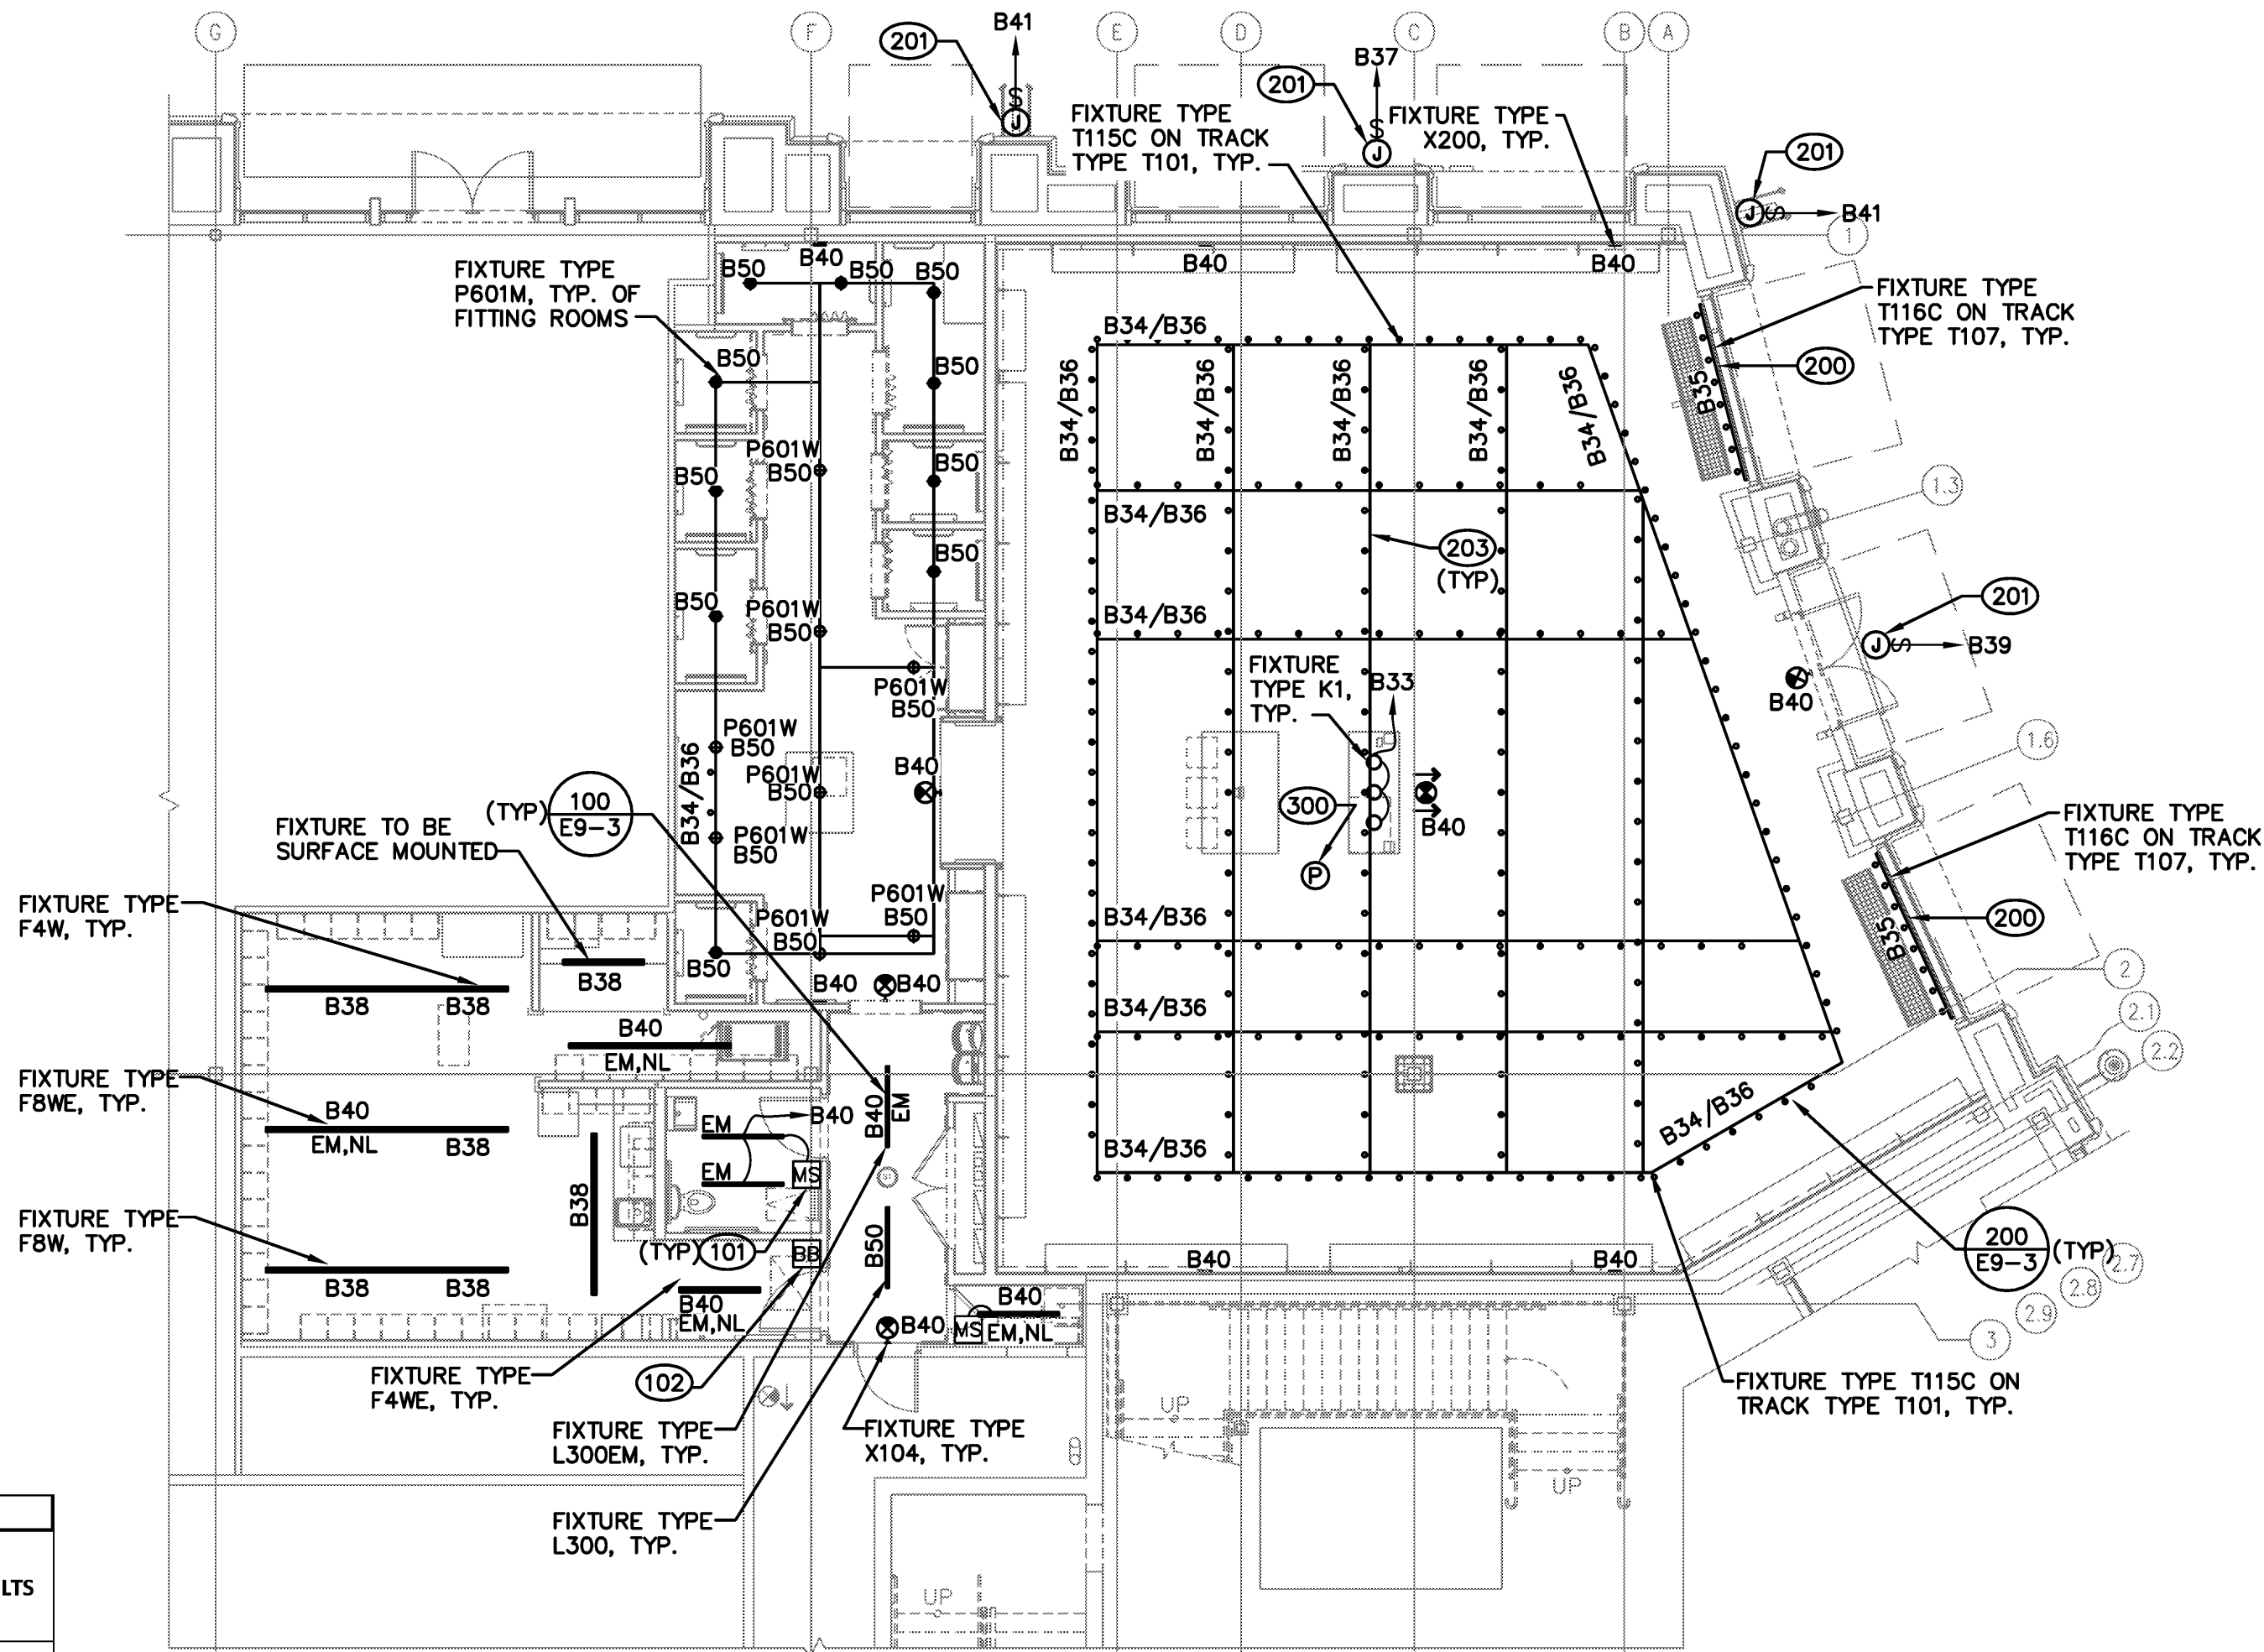


NOTE:
SALES AREA TRACK LIGHTING SHALL HAVE RIGID CONDUIT. NO FLEXIBLE CONDUIT SHALL BE USED. RIGID CONDUIT TO BE INSTALLED TO MIMIC THE LOOK OF THE THREADED ROD. DO NOT PAINT CONDUIT AND THREADED ROD. REFERENCE ARCHITECTURAL DRAWINGS

- TRACK WIRING NOTE:**
1. DO NOT REWIRE TRACK CONNECTORS. APPROPRIATE CONNECTORS SHALL BE PROVIDED PER PLANS.
 2. HOT WIRES SHALL CONNECT TO THE POLARITY LINE ON LIVE ENDS. BE MINDFUL OF HOT VS. NEUTRAL TERMINALS.
 3. KEEP THE GAP CLOSER THAN APPROACHING THE SILVER RIVET. TIGHT CONNECTIONS ENSURE GOOD CONTACTS.
 4. WIRED CONNECTIONS AT SCREW TERMINALS MUST OVERLAP FOR A GOOD TRANSFER OF ENERGY. PROVIDE MAXIMUM CONDUCTOR TO SCREW CONTACT WHEN WIRING LIVE ENDS.

NOTE:
G.C. TO REFERENCE ARCHITECTURAL REFLECTED CEILING PLAN FOR LOCATIONS OF ALL LIGHT FIXTURES AND SIGNS.

NOTE:
IN TOILET ROOMS, ALL MOTION SENSORS AND RECEPTACLES SHALL BE MOUNTED WITH CENTERLINE AT 44" TO AVOID CONFLICTS WITH BEADBOARD TRIM.

LIGHTING PLAN AND FIXTURE SCHEDULE

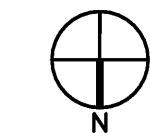

SCALE:
1/8" = 1'-0"

NEW STORE



GAP INC.
STORE DEVELOPMENT
2 FOLSOM STREET
SAN FRANCISCO, CA 94105

ORACLE I.D.:

140261

STORE NUMBER:

7341

STORE LOCATION:

STATION PARK

230 NE PROMONTORY
SPACE C-120
FARMINGTON, UT 84025

DESIGN TYPE:

DERBY B

GENERATION:

21Q34

PROTOTYPE DATE:

1/8/2021

OPENING:

2021

ARCHITECT INFO:



ARCHITECT OF RECORD:

MARIAH MEYER
8131 METCALF AVE
SUITE 300
OVERLAND PARK, KS 66204

www.brrarch.com

TEL: 913-262-9095
FAX: 913-262-9044

CONSULTANT INFO:



8345 LENEXA DRIVE, SUITE 300
LENEXA, KS 66214
TEL 913.742.5000 FAX 913.742.5001

WWW.HENDERSONENGINEERS.COM

2050004241
UT. CORPORATE NUMBER: 497264-0143
09/30/21

PROFESSIONAL STAMP:

THIS DOCUMENT IS RELEASED FOR THE PURPOSE OF PRELIMINARY SUBMITTAL WILLIAM R. WINSTON LICENSE # 11811162-2202
IT IS NOT TO BE USED FOR CONSTRUCTION PURPOSES.

ISSUE TYPE:

LL/PERMIT/BD: 02/19/21

REVISIONS:

DRAWN BY: HEI

A/E JOB NUMBER: 65011072

TITLE SHEET:
LIGHTING PLAN AND
FIXTURE SCHEDULE

SHEET NUMBER:

E1-1