



TELECOM BACKBOARD DETAIL

NOT TO SCALE
201

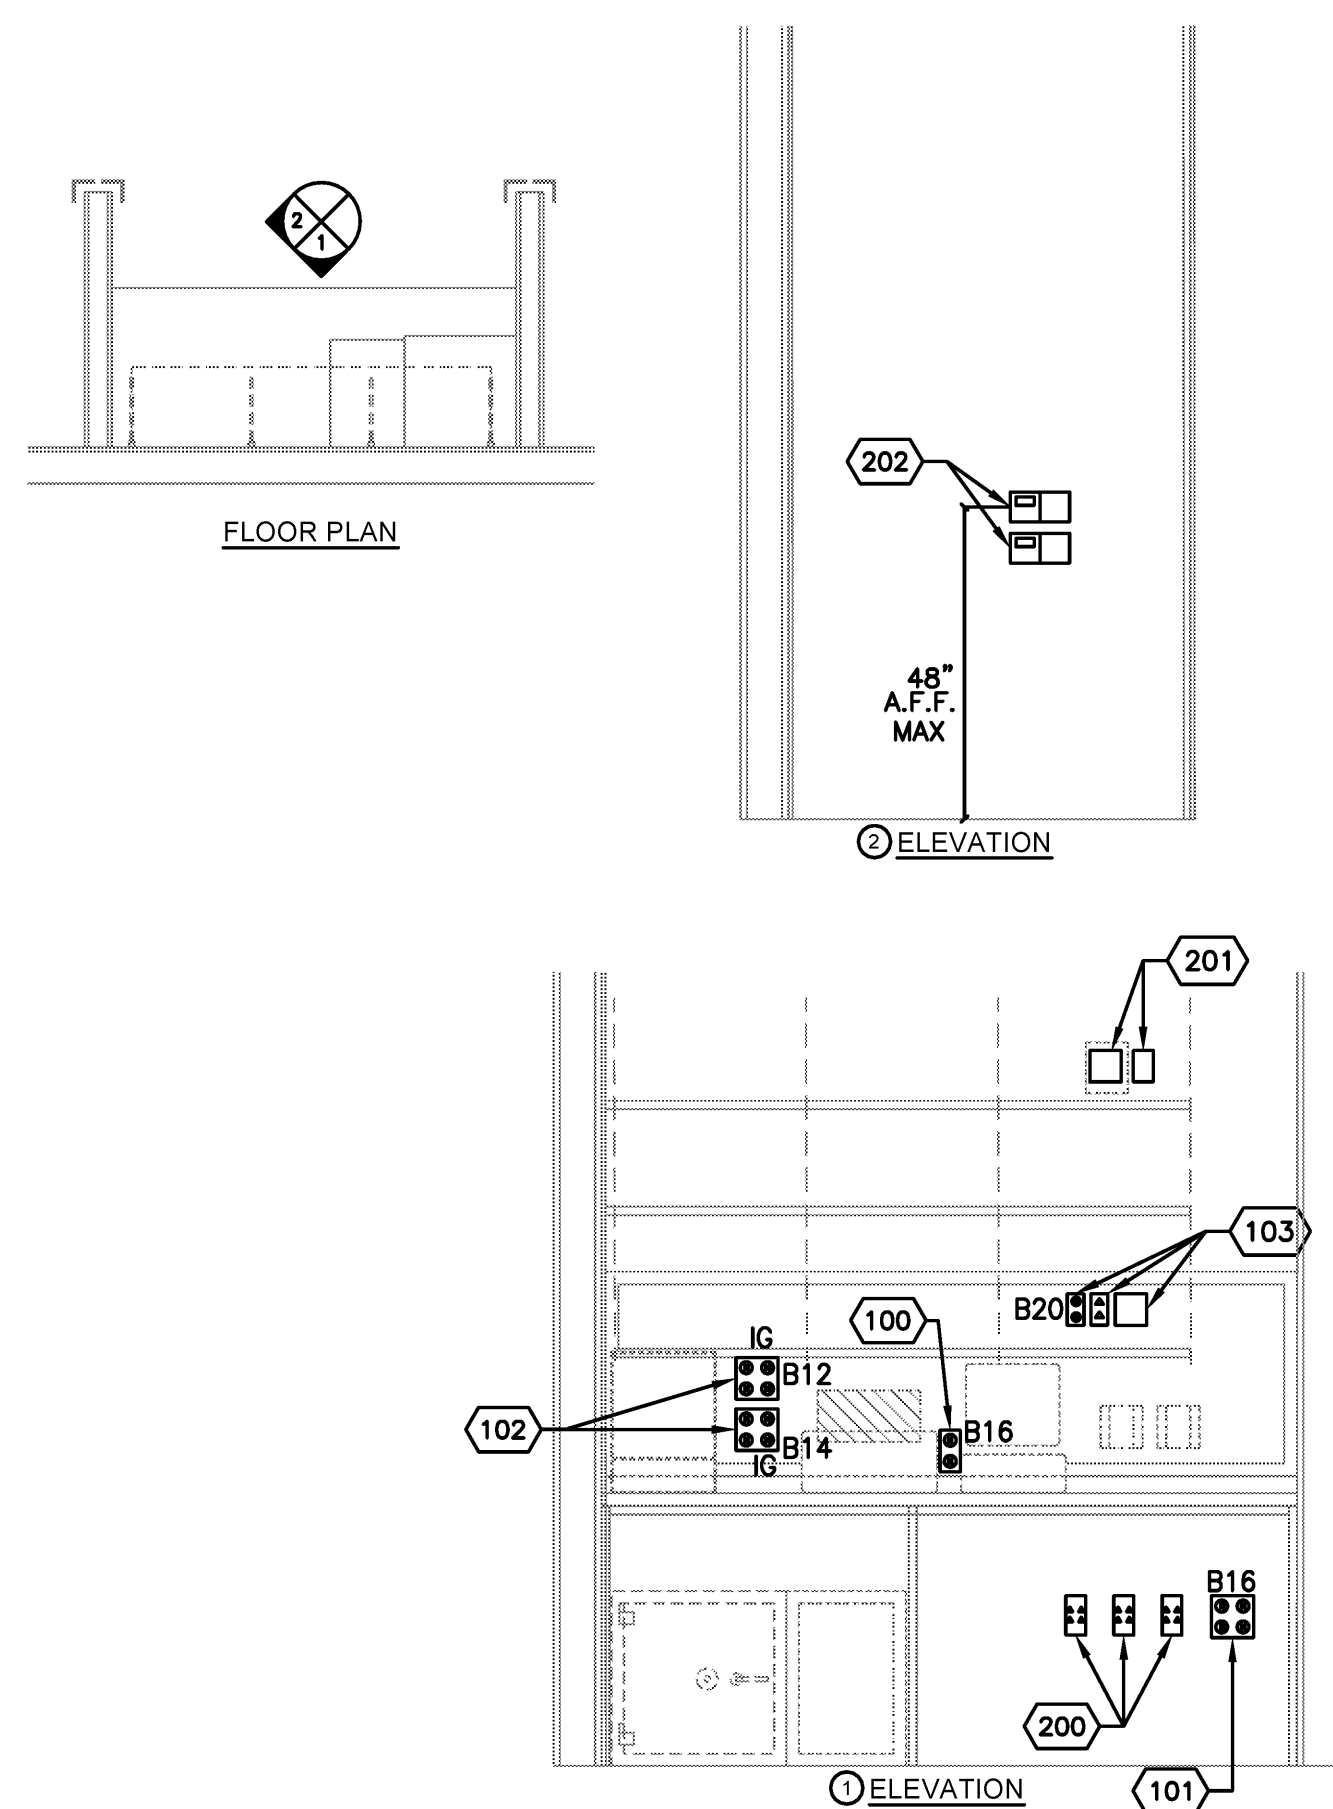

MANAGERS DESK ELEVATIONS

NOT TO SCALE
200

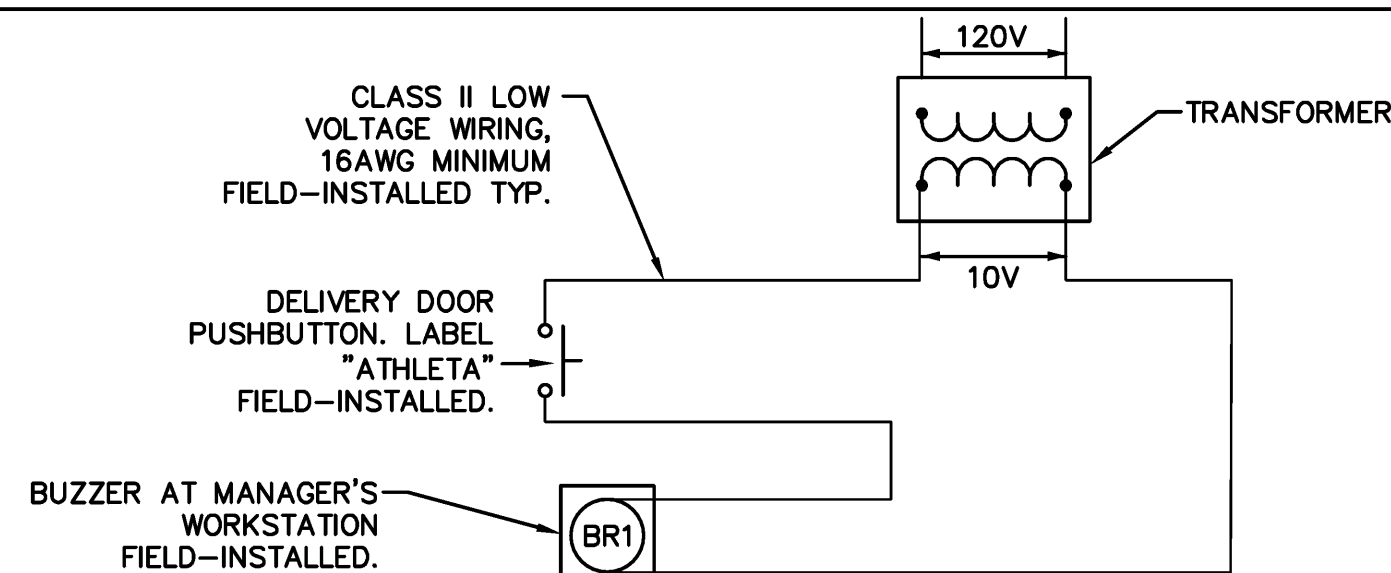

DOOR BUZZER DETAIL

NOT TO SCALE
202

MANAGER'S DESK CODED NOTES

- 100 DUPLEX CONVENIENCE RECEPTACLE FOR GENERAL USE POWER. LABEL "CONVENIENCE", AND CIRCUIT AS INDICATED.
- 101 CONVENIENCE RECEPTACLE FOR GENERAL USE POWER. INSTALL IN 4" SQ BY 2-1/8" DEEP BOX WITH TWO GANG 1/2" PLASTER RING COVER. LABEL "CONVENIENCE", AND CIRCUIT AS INDICATED.
- 102 ISOLATED GROUND RECEPTACLES FOR CCTV EQUIPMENT. INSTALL IN 4" SQ BY 2-1/8" DEEP BOX WITH TWO GANG 1/2" PLASTER RING COVER. LABEL "CCTV", AND CIRCUIT AS INDICATED ON POWER PLAN AND PANEL SCHEDULE.
- 103 INSTALL A DUPLEX RECEPTACLE FOR SOUND SYSTEM. NEXT TO THE DUPLEX RECEPTACLE INSTALL (1) SINGLE GANG AND (1) 2-GANG J-BOX WITH 3/4" CONDUIT PIPED 6" ABOVE CEILING FOR WIRES. REFER TO POWER PLAN AND SOUND SYSTEM DETAIL FOR ADDITIONAL INFORMATION.
- 200 INSTALL (3) SINGLE GANG JUNCTION BOXES AND RUN 3/4" CONDUIT EACH WITH PULL WIRE BACK TO NETWORK BOARD LOCATION. PROVIDE LABEL FOR EACH BOX: (1) PHONE, (1) PRINTER, (1) WORKSTATION.
- 201 NUTONE BUZZER UNIT AND TRANSFORMER ON WALL.
- 202 2"x4" J-BOX FOR THERMOSTAT FOR HVAC EQUIPMENT. INSTALL J-BOX IN THE HORIZONTAL POSITION. ENSURE APPROXIMATELY 10" HORIZONTAL BETWEEN J-BOXES CENTER TO CENTER. INSTALL 1/2" CONDUIT WITH BUSHINGS AND PULL WIRE TO ABOVE CEILING FOR CONTROL WIRING. COORDINATE LOCATION WITH GC PRIOR TO ROUGH-IN. VERIFY EXACT QUANTITY AND REQUIREMENTS WITH MECHANICAL DRAWINGS PRIOR TO ROUGH-IN.

MANAGER'S DESK GENERAL NOTES

1. REFER TO CONDUIT RISER DIAGRAM FOR EMPTY CONDUIT SIZES.
2. FINAL CONNECTIONS, HUBS AND WIRING FOR POS AND TELEPHONE SYSTEMS ARE PROVIDED AND INSTALLED BY SPENCER ENGINEERING AND LUCENT TECHNOLOGY RESPECTIVELY.
3. FINAL CONNECTIONS AND WIRING FOR MUSIC SYSTEM ARE PROVIDED AND INSTALLED BY PLAY NETWORK.
4. ALL J-BOXES TO BE RECESSED UNLESS NOTED OTHERWISE.
5. ALL COVERS FOR JUNCTION BOXES AND RECEPTACLES ABOVE THE DESK SHALL BE FLUSH WITH THE CORK FINISH. PROVIDE EXTENSION RINGS AS REQUIRED.
6. REFER TO ARCHITECTURAL ELEVATIONS FOR MOUNTING HEIGHTS.
7. REFER TO ARCH PLANS FOR DIMENSIONS OF ALL COMPONENTS.

NEW STORE



GAP INC.
STORE DEVELOPMENT
2 FOLSOM STREET
SAN FRANCISCO, CA 94105

ORACLE I.D.:

STORE NUMBER:

STORE LOCATION:

STATION PARK
230 NE PROMONTORY
SPACE C-120
EARMINGTON, UT 84025

DESIGN TYPE:	DERBY B
GENERATION:	21Q34
PROTOTYPE DATE:	1/8/2021
OPENING:	2021

ARCHITECT INFO:



ARCHITECT OF RECORD:
MARIAH MEYER
8131 METCALF AVE
SUITE 300
OVERLAND PARK, KS 66202
www.bmrarch.com
TEL: 913-262-9095
FAX: 913-262-9044

CONSULTANT INFO:



8345 LENEXA DRIVE, SUITE 300
LENEXA, KS 66214
TEL 913.742.5000 FAX 913.742.5001
WWW.HENDERSONENGINEERS.COM

2050004241
UT. CORPORATE NUMBER: 4977264-014
09/30/21

PROFESSIONAL STAMP:

THIS DOCUMENT IS RELEASED
FOR THE PURPOSE OF
PRELIMINARY SUBMITTAL
WILLIAM R. WINSTON
LICENSE # 11811162-2202

IT IS NOT TO BE USED FOR
CONSTRUCTION
PURPOSES.

ISSUE TYPE:

LL/PERMIT/BID:	02/19/21
----------------	----------

REVISIONS:

DRAWN BY: HEI
A/E JOB NUMBER: 65011072

TITLE SHEET:
ELECTRICAL
DETAILS

SHEET NUMBER

E9-5