



COLD WATER AND HOT WATER RISER DIAGRAM

NO SCALE
103

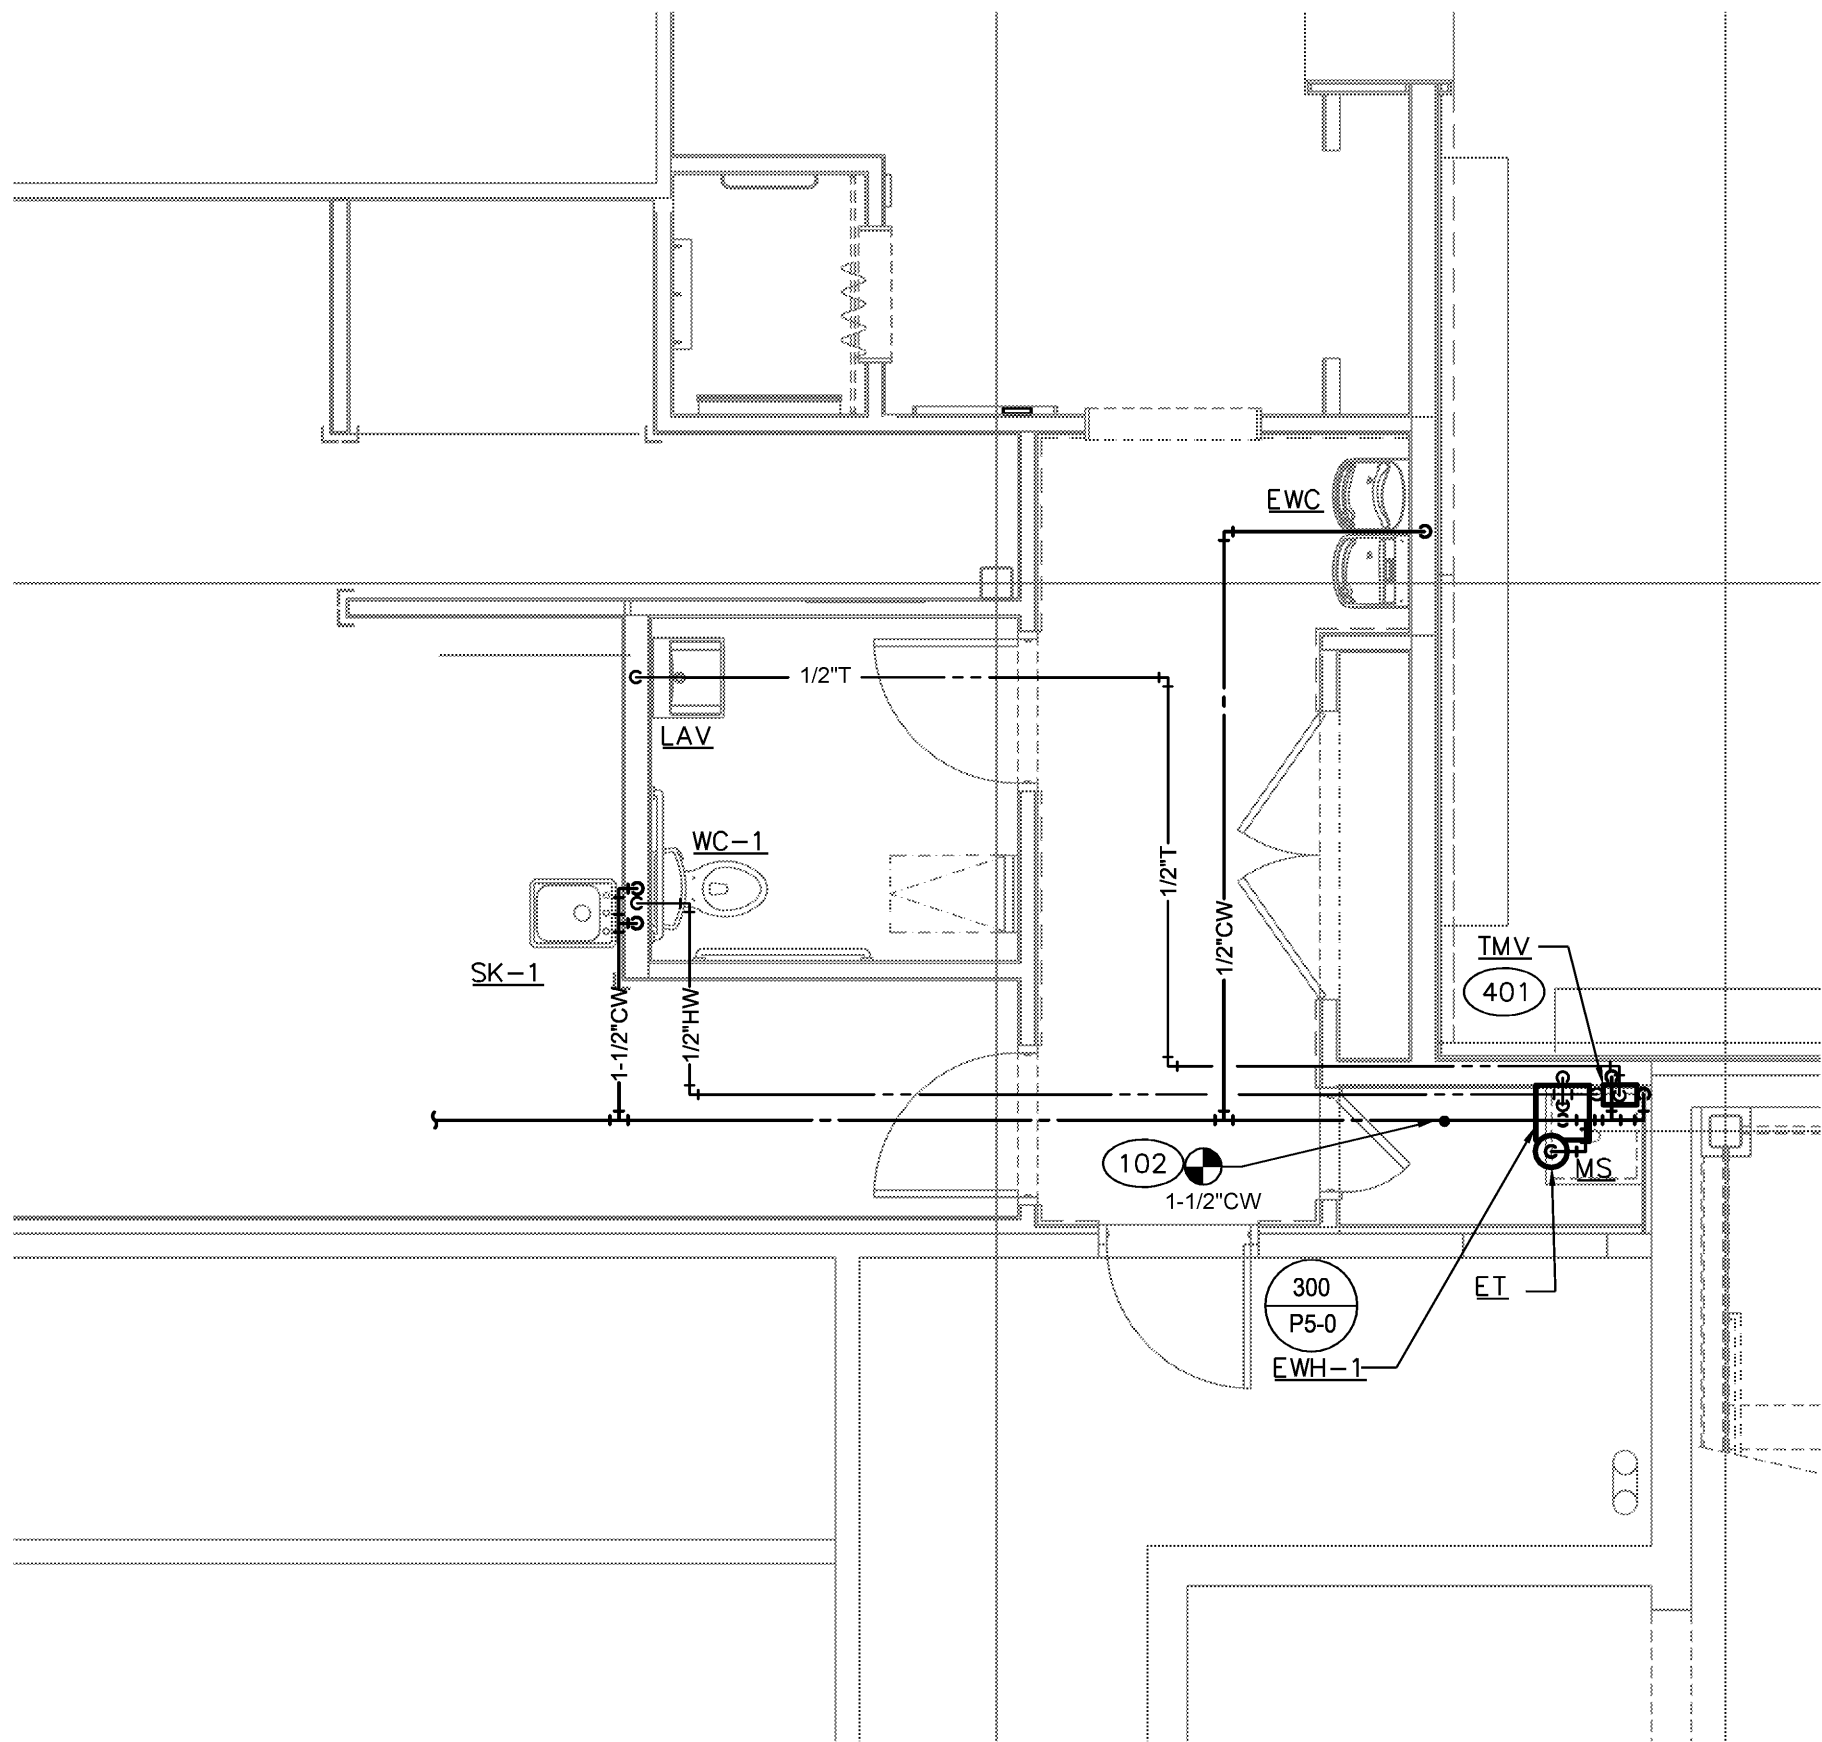


ENLARGED COLD WATER AND HOT WATER PLUMBING PLAN

1/4" = 1'-0"
102

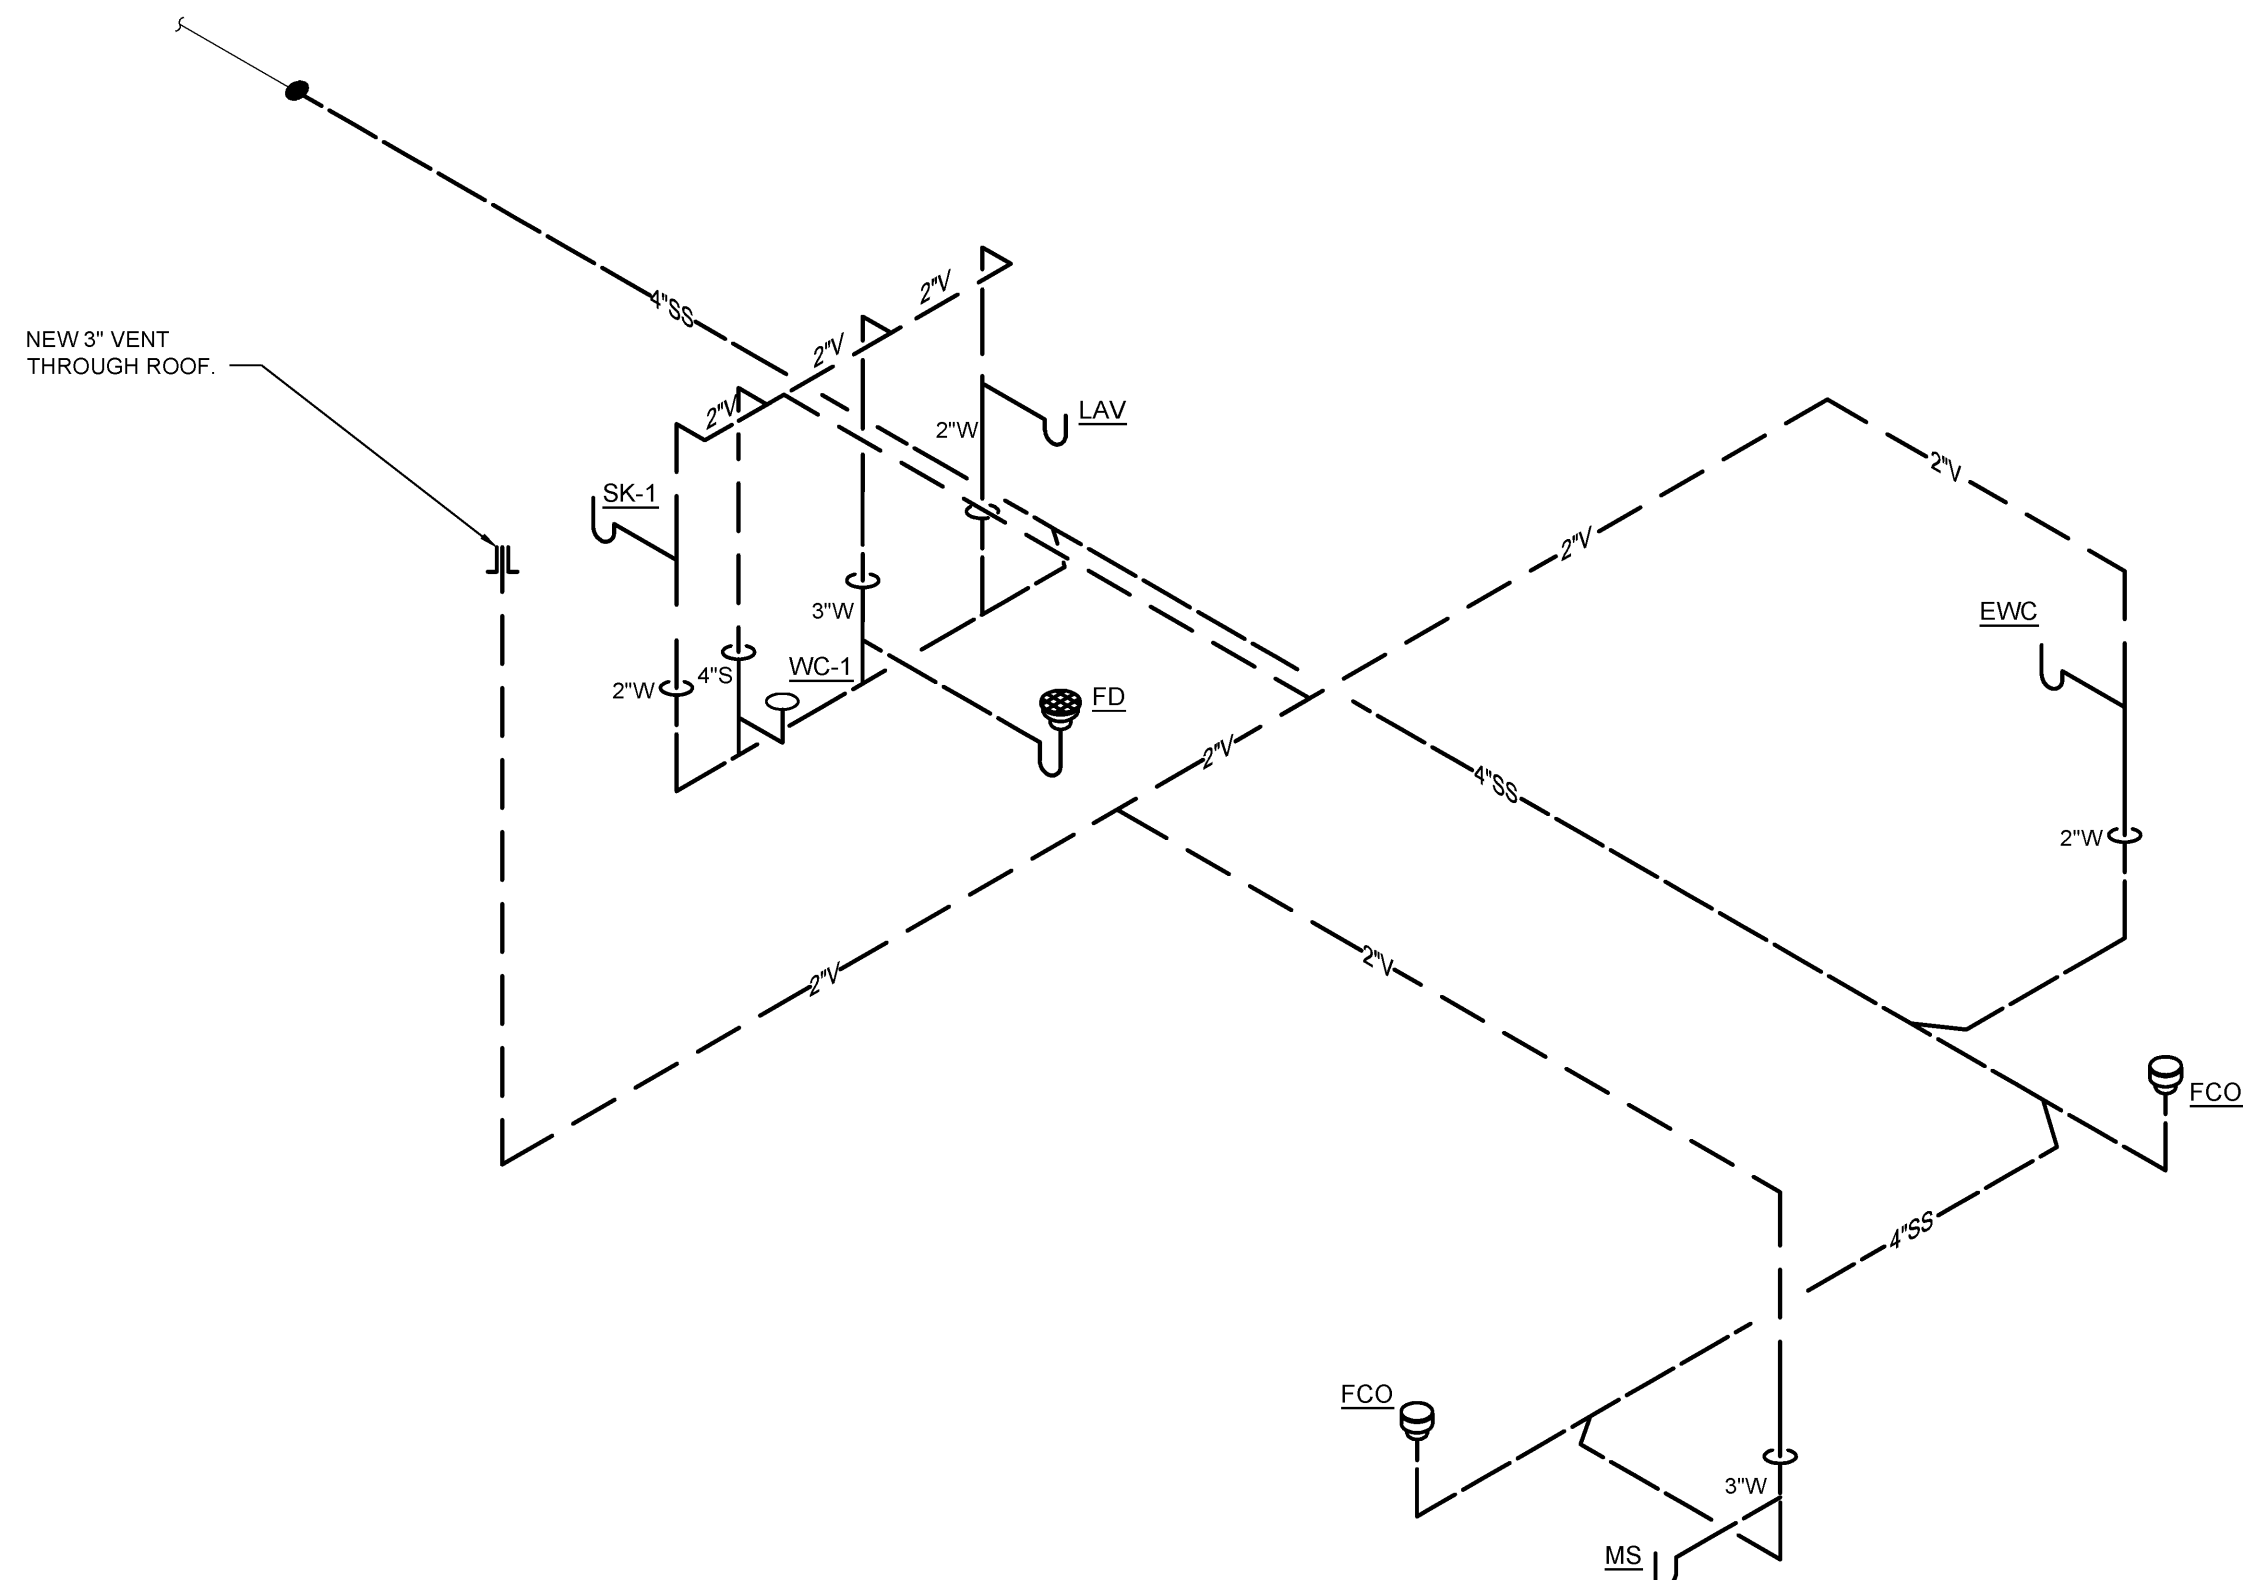

WASTE AND VENT RISER DIAGRAM

NO SCALE
101

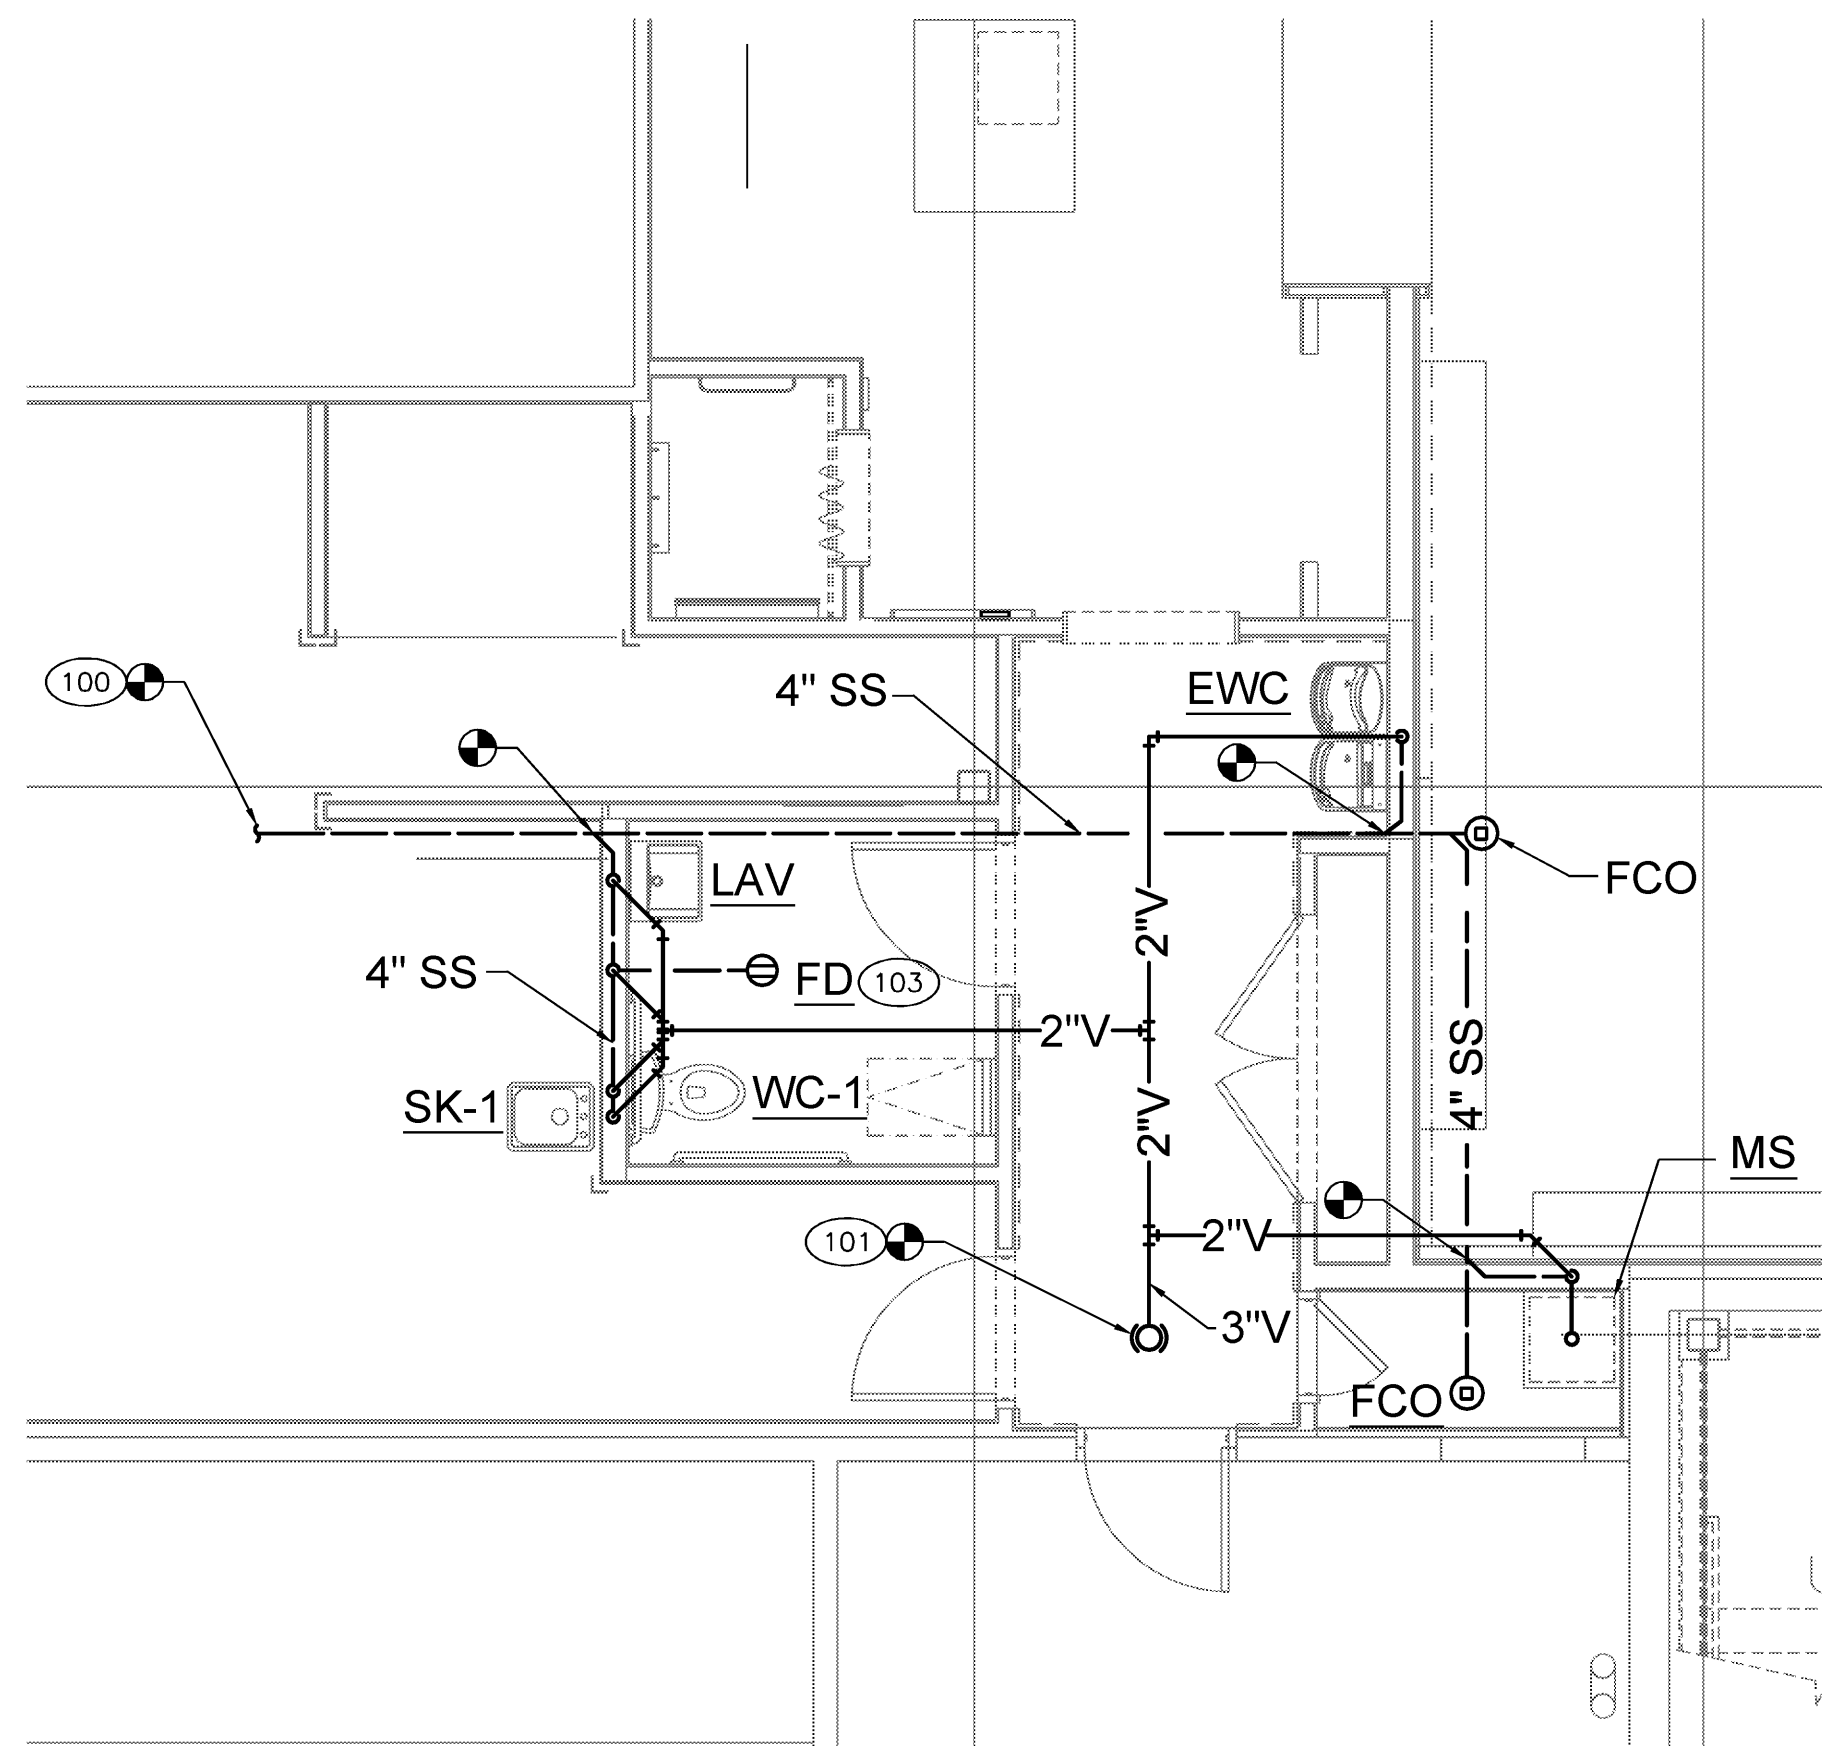

ENLARGED WASTE AND VENT PLUMBING PLAN

1/4" = 1'-0"
100

PLUMBING CODED NOTES

- 100 CONNECT NEW SANITARY LINE INTO THE EXISTING SANITARY SERVICE. FIELD VERIFY EXACT LOCATION OF LANDLORD'S MAIN PRIOR TO BIDDING. INSTALL CLEANOUT AT CONNECTION TO LANDLORD'S MAIN AND COORDINATE LOCATION AND TYPE OF COVER REQUIRED TO MATCH FLOOR FINISH WITH G.C. REFER TO WASTE AND VENT RISER DIAGRAM AND PLUMBING SPECIFICATIONS FOR ADDITIONAL REQUIREMENTS.
- 101 EXTEND NEW VENT THROUGH ROOF. REFER TO WASTE AND VENT RISER DIAGRAM AND PLUMBING SPECIFICATIONS FOR ADDITIONAL REQUIREMENTS. ALL ROOFING WORK SHALL BE DONE BY LANDLORD APPROVED ROOFING CONTRACTOR.
- 102 CONNECT NEW COLD WATER LINE INTO THE EXISTING COLD WATER TAP. NOTIFY G.C. IF TAP IS SMALLER THAN SHOWN. REFER TO COLD WATER AND HOT WATER RISER DIAGRAM AND PLUMBING SPECIFICATIONS FOR ADDITIONAL REQUIREMENTS.
- 103 PROVIDE FLOOR DRAIN WITH TRAP SEAL DEVICE (TS) PER SCHEDULE. INSTALL DEVICE PER MANUFACTURER'S INSTALLATION MANUAL.

NEW STORE



GAP INC.
STORE DEVELOPMENT
2 FOLSOM STREET
SAN FRANCISCO, CA 94105

ORACLE I.D.:

140261

STORE NUMBER:

7341

STORE LOCATION:

STATION PARK
230 NE PROMONTORY
SPACE C-120
FARMINGTON, UT 84025

DESIGN TYPE:

DERBY B

GENERATION:

21Q34

PROTOTYPE DATE:

1/8/2021

OPENING:

2021

ARCHITECT INFO:



ARCHITECT OF RECORD:

MARIAH MEYER
8131 METCALF AVE
SUITE 300
OVERLAND PARK, KS 66204

www.brrarch.com

TEL: 913-262-9095

FAX: 913-262-9044

CONSULTANT INFO:



8345 LENEXA DRIVE, SUITE 300
LENEXA, KS 66214
TEL 913.742.5000 FAX 913.742.5001
WWW.HENDERSONENGINEERS.COM

2050004241
UT. CORPORATE NUMBER: 497264-0143
09/30/21

PROFESSIONAL STAMP:

THIS DOCUMENT IS RELEASED
FOR THE PURPOSE OF
PRELIMINARY SUBMITTAL
SEAN O. EISLER
LICENSE # 7804825-2202
IT IS NOT TO BE USED FOR
CONSTRUCTION
PURPOSES.

ISSUE TYPE:

LL/PERMIT/BID: 02/19/21

REVISIONS:

DRAWN BY: HEI

A/E JOB NUMBER: 65011072

TITLE SHEET:
ENLARGED PLUMBING
PLANS AND RISERS

SHEET NUMBER:

P1-1