



THIS DRAWING SHEET AND ALL INFORMATION HEREON IS COPYRIGHTED AND THE PROPERTY OF JTB HVAC & PLUMBING ENGINEERING, INC. AND SHALL NOT BE USED ON ANY OTHER PROJECT WITHOUT WRITTEN PERMISSION FROM JTB HVAC & PLUMBING ENGINEERING, INC.

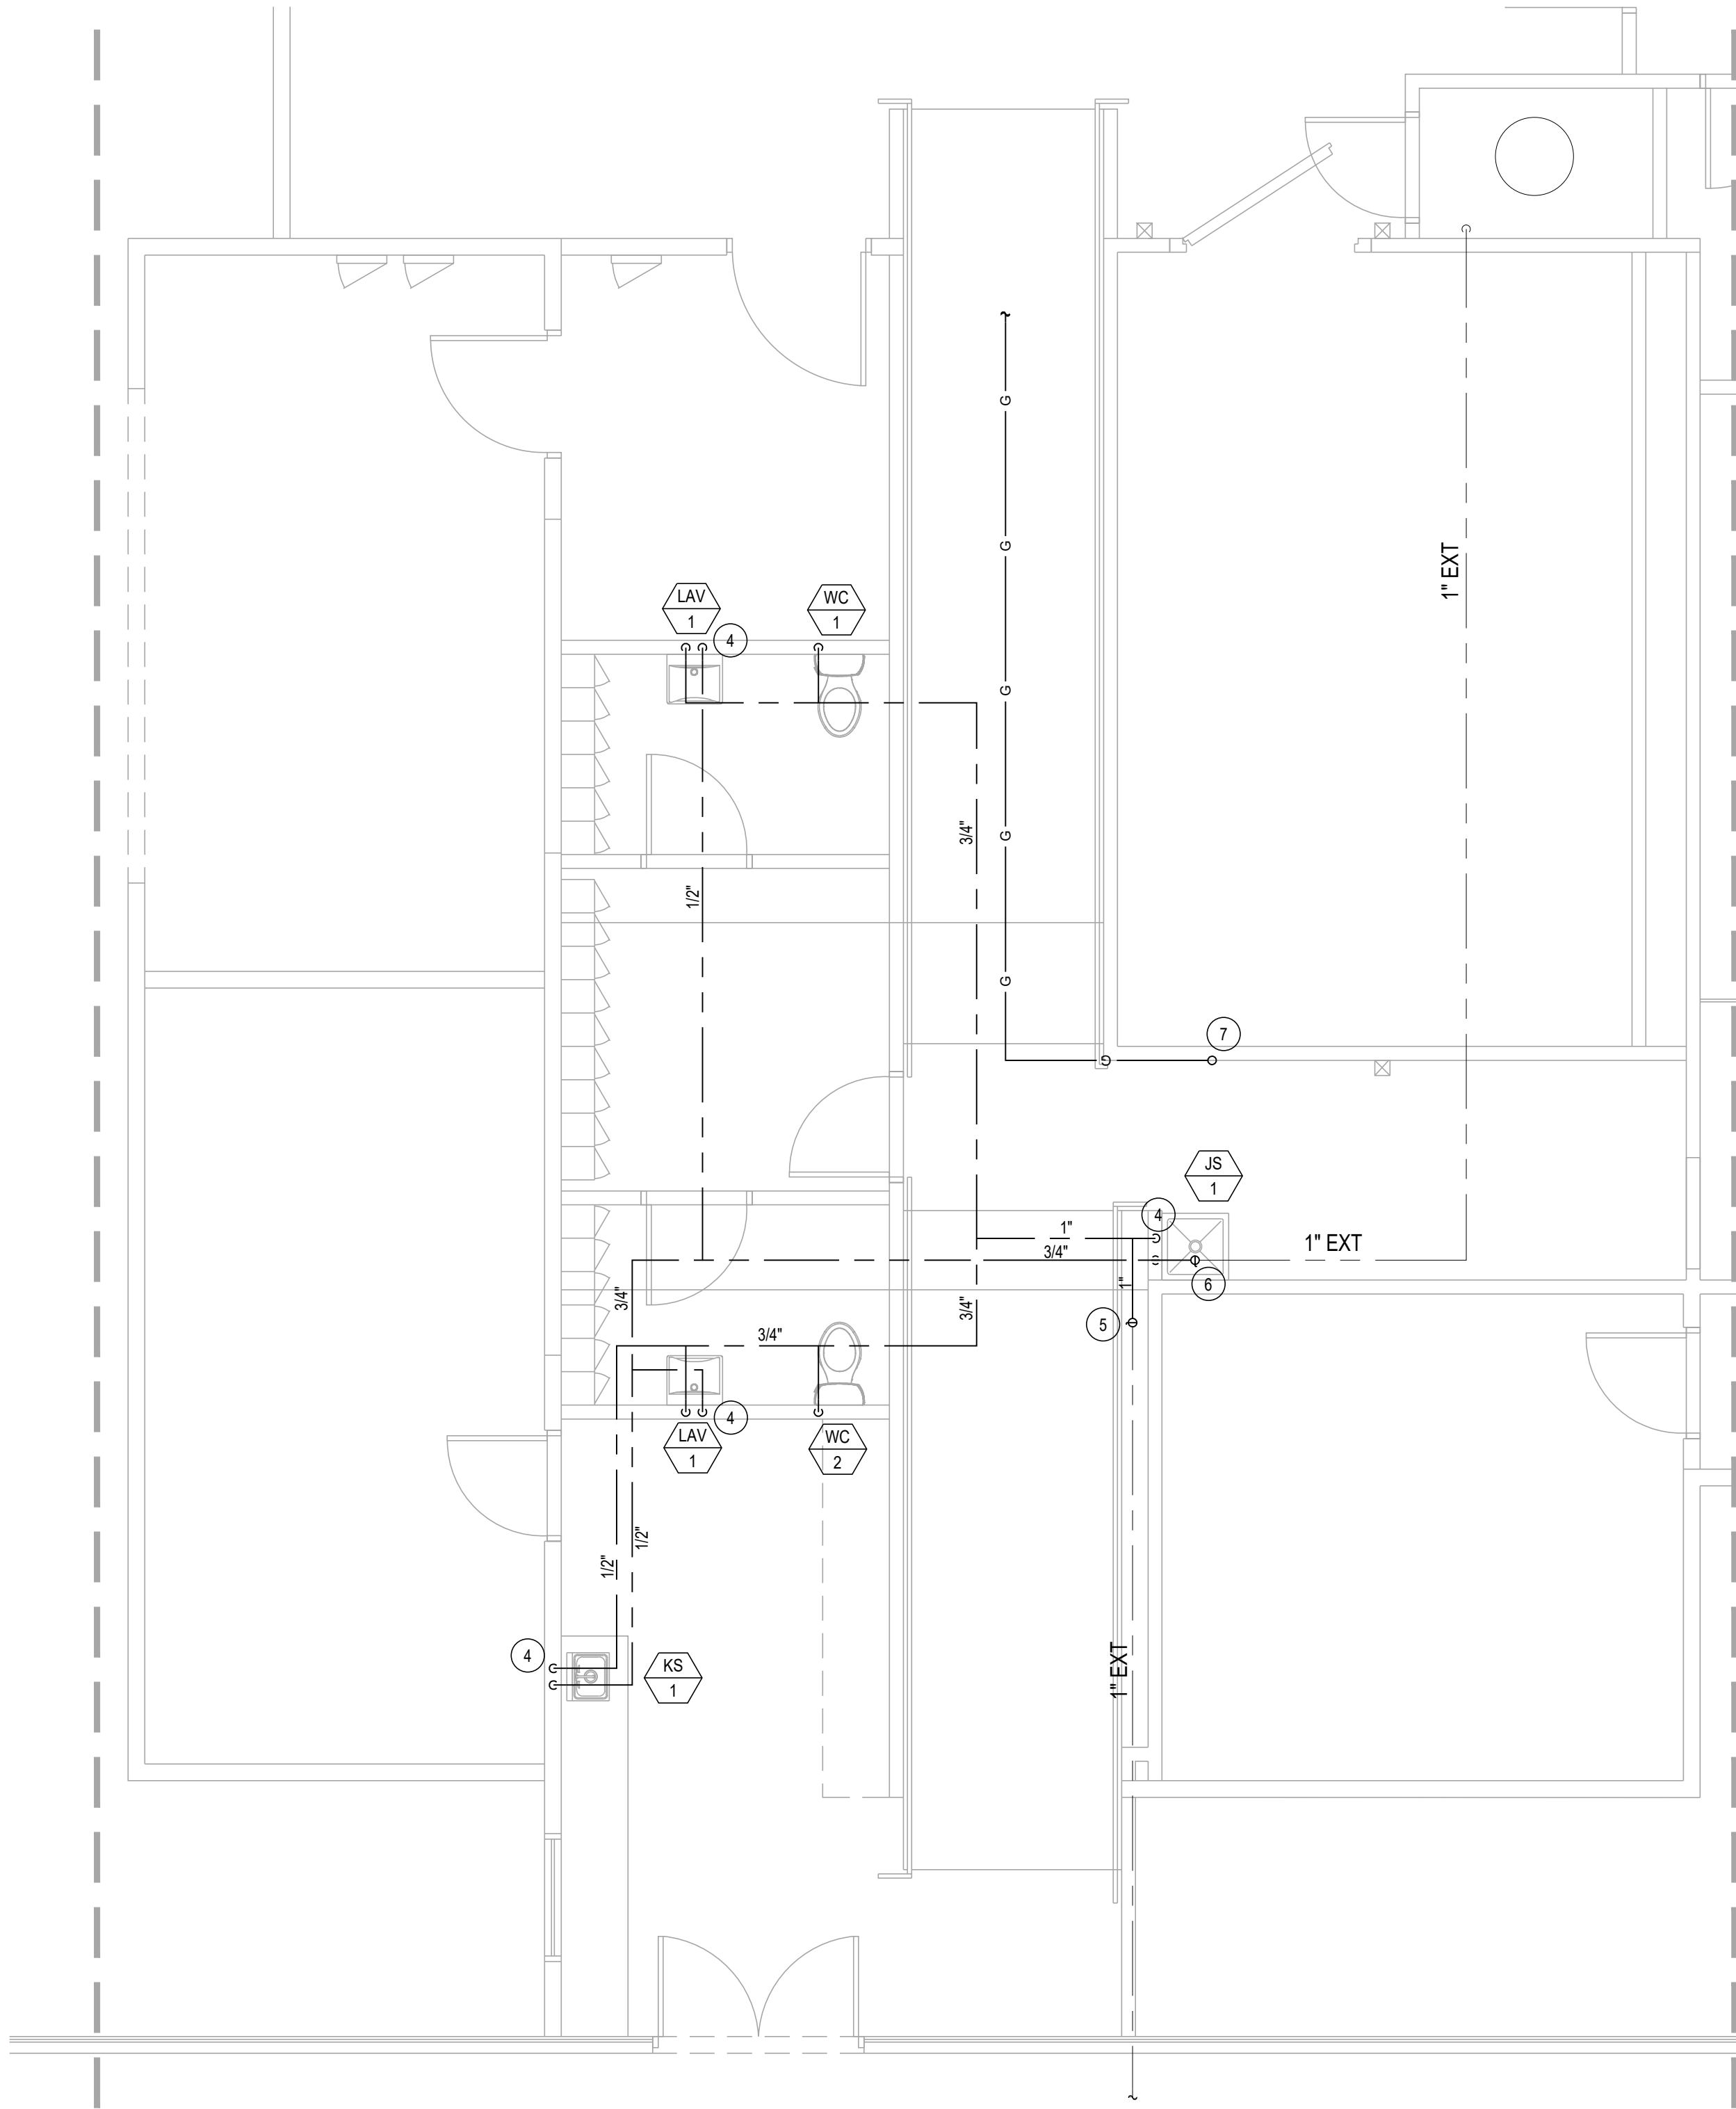


NORTH
WATER AND GAS PLUMBING PLAN
SCALE: 1/4"=1'-0"

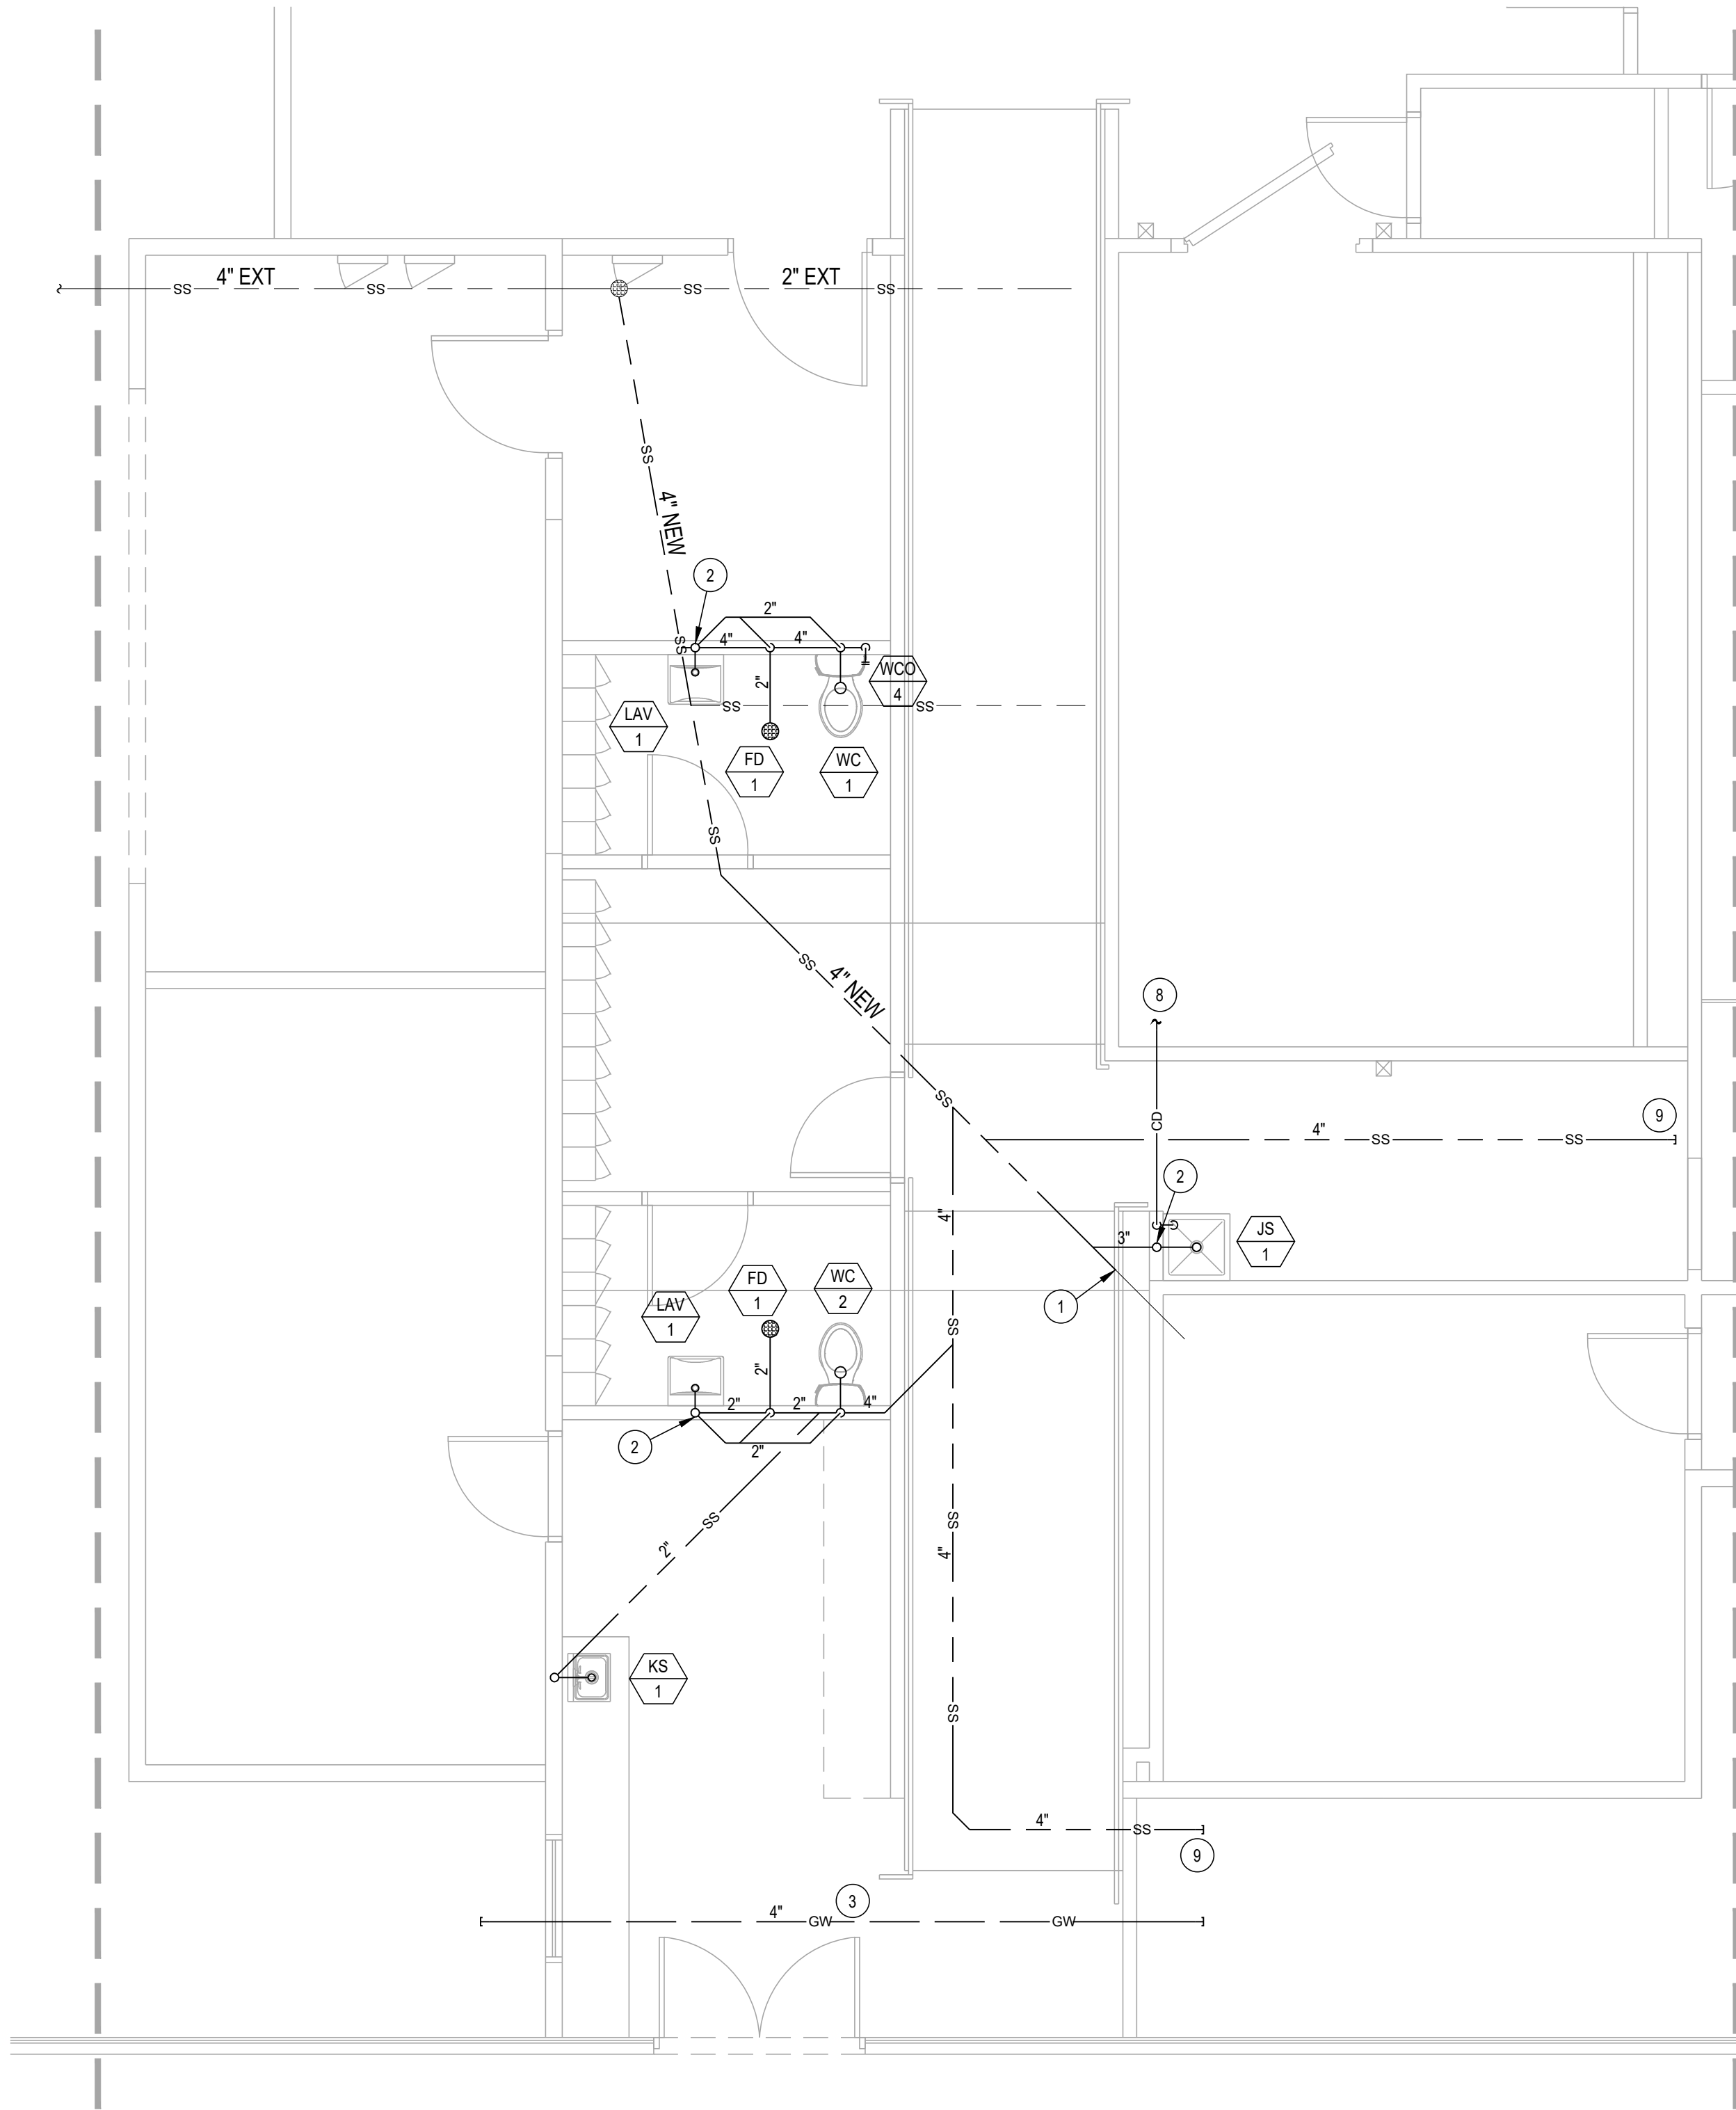

NORTH
WASTE AND VENT PLUMBING PLAN
SCALE: 1/4"=1'-0"


KEYED NOTES

- 1 CONNECT TO EXISTING SEWER, FIELD VERIFY LOCATION AND DEPTH.
- 2 2" VENT THRU THE ROOF.
- 3 INSTALL 4" FUTURE GREASE WASTE LINE FROM FUTURE PHASE II TO OUTSIDE, CAP EACH END. SLOPE AT 1/8" PER FOOT TOWARD WEST.
- 4 1/2" DOW AND DHW DROP DOWN WALL TO SINK.
- 5 CONNECT TO EXISTING 1" DOW.
- 6 CONNECT TO EXISTING 1" DHW.
- 7 EXTEND EXISTING GAS LINE FROM UNIT HEATER, UP THRU ROOF TO ROOFTOP UNIT.
- 8 REROUTE CONDENSATE FROM FREEZER TO NEW MOP SINK WITH AIR GAP.
- 9 RUN NEW 4" SANITARY SEWER TO THIS LOCATION AND CAP FOR FUTURE PHASE II.

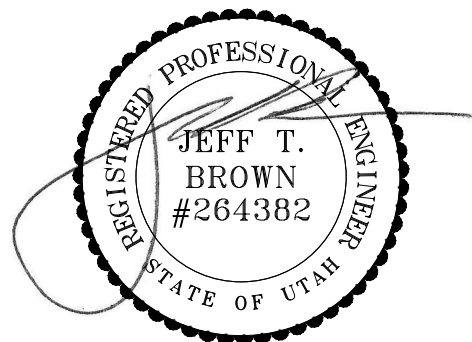

PERMIT SET

REV.	DATE	DESCRIPTION
-	-	-
-	-	-
-	-	-
-	-	-
B	01/23/2018	REVISED PER COMMENTS
A	01/19/2018	RELEASED FOR PERMIT

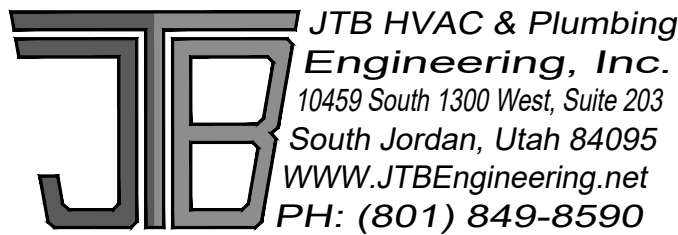

PROJECT NAME: LA CAILLE- BANQUET SUPPORT REMODEL

ADDRESS
9565 WASATCH BLVD
SANDY, UT 84092

DRAWING TITLE: PLUMBING PLAN

JOB NO.:	18.005	SHEET NUMBER
DATE:	01/23/2018	
DRAWN BY:	JTB	
SCALE:	NTS	

P202