



THIS DRAWING SHEET AND ALL INFORMATION HEREON IS COPYRIGHTED AND THE PROPERTY OF JTB HVAC & PLUMBING ENGINEERING, INC. AND SHALL NOT BE USED ON ANY OTHER PROJECT WITHOUT WRITTEN PERMISSION FROM JTB HVAC & PLUMBING ENGINEERING, INC.

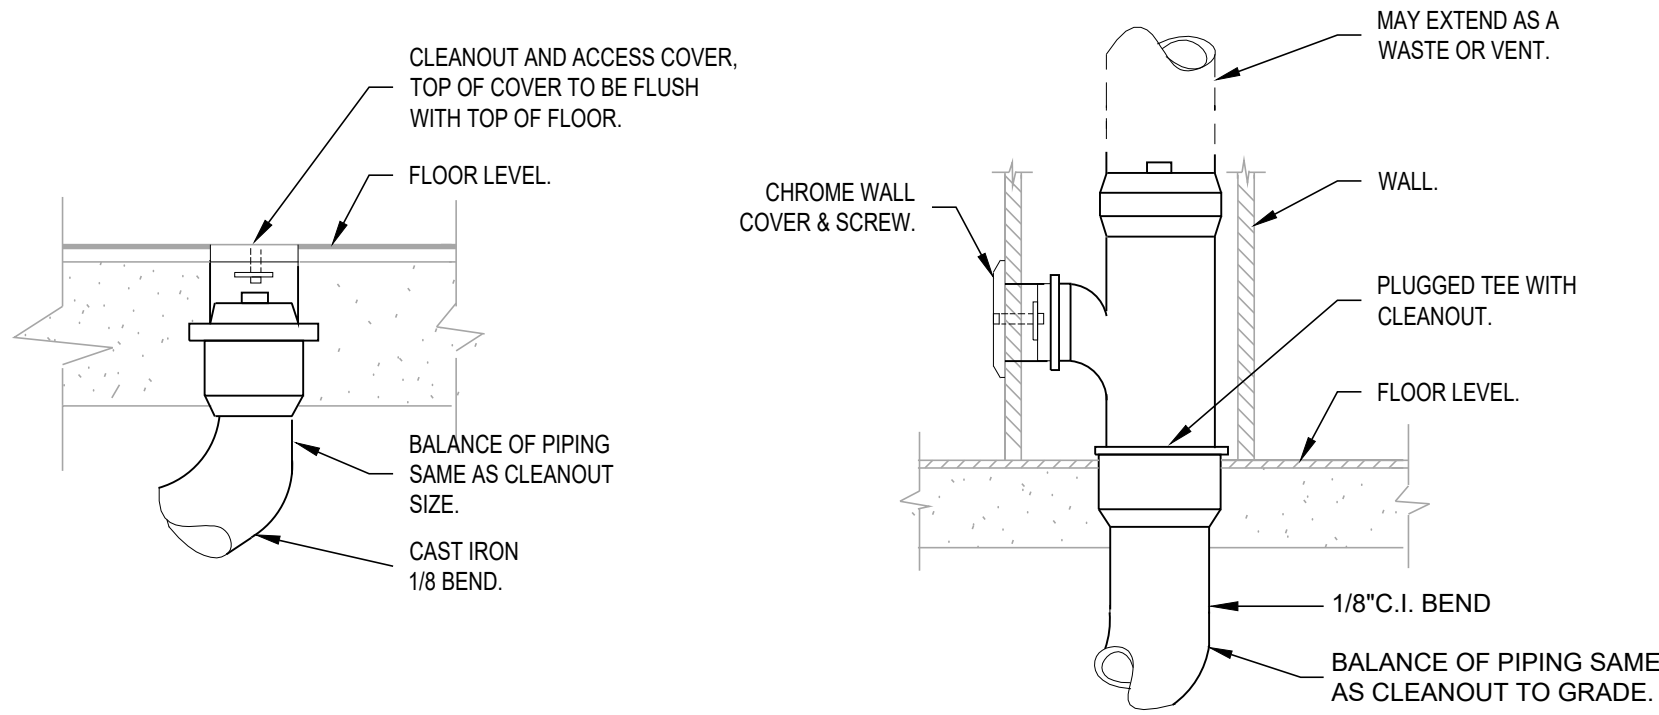

FLOOR CLEAN-OUT

WALL CLEAN-OUT


A CLEANOUT DETAILS

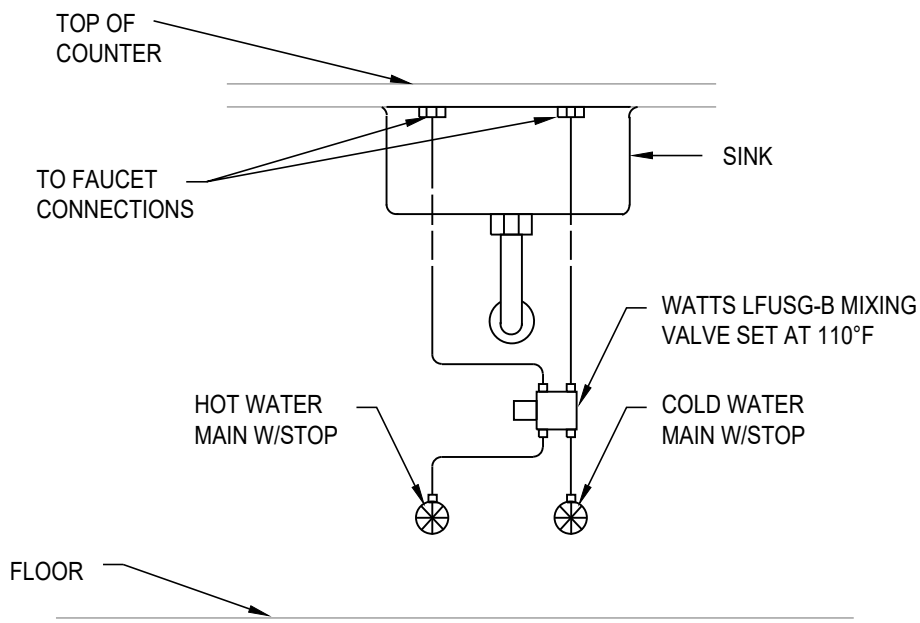

B LAV MIXING VALVE DETAIL


PLUMBING SCHEDULE

TAG	FIXTURE TYPE MOUNTING LOCATION	FIXTURE ROUGH-IN SIZES inches					FINISH COLOR	ACCESSORIES AND COMMENTS	FIXTURE MANUFACTURER MODEL NUMBER
		DOMESTIC WATER		WASTE & VENT					
		COLD	HOT	TRAP	VENT	WASTE			
WC 1	WATER CLOSET-ADA FLOOR MOUNT-TANK	1/2"	-	-	2	4	WHITE	BRASS CRAFT KWIK TURN STOPS BEMIS WHITE SEAT (1955C)	PROFLO CHROME ESCUTCHEON LEFT CHROME TRIP LEVER KOHLER K-3979
WC 2	WATER CLOSET-ADA FLOOR MOUNT-TANK	1/2"	-	-	2	4	WHITE	BRASS CRAFT KWIK TURN STOPS BEMIS WHITE SEAT (1955C)	PROFLO CHROME ESCUTCHEON RIGHT CHROME TRIP LEVER KOHLER K-3979
LAV 1	LAVATORY-ADA WALL MOUNT	1/2	1/2	1 1/4	2	2	WHITE	INSULATED P-TRAP COVER PROFLO 1 1/4" SS GRID STRAINER AND P-TRAP	BRASS CRAFT KWIK TURN STOPS, WATTS LFUSG-B MIXING VALVE MOEN FAUCET (8800 CHROME) KOHLER K-2005
FD 1	FLOOR DRAIN	-	-	2	2	2	NB	TRAP GUARD, SIMILAR TO SURESEAL 97041	- WATTS - F07-5R-2-PVC
KS 1	KITCHEN SINK-ADA COUNTER MOUNT-SINGLE COMP.	1/2	1/2	1 1/2	2	2	SS	PROFLO 1 1/2" SS BASKET, STRAINER & P-TRAP MOEN FAUCET (7430-CHROME W/O SPRAYER)	- BRASS CRAFT KWIK TURN STOPS - ELKAY LRAD222265
JS 1	JANITOR SINK FLOOR MOUNT	1/2	1/2	3	2	3	WHITE	FIAT FAUCET (830-AA) FIAT HOSE AND BRACKET (832-AA)	FIAT MOP BRACKET (889-CC) - FIAT MSB-2424
WCO -	WALL CLEANOUT NUMBER IS SIZE	-	-	-	-	VARIES	-	PROVIDE COVER AND SCREW	- JAY R. SMITH - 4472T
FCO -	FLOOR CLEANOUT NUMBER IS SIZE	-	-	-	-	VARIES	-	GASKET SEAL BRONZE PLUG	- JAY R. SMITH - 4101S
GCO -	GRADE CLEANOUT NUMBER IS SIZE	-	-	-	-	VARIES	-	SHALLOW COVER AND SCREW	- JAY R. SMITH - 4422C

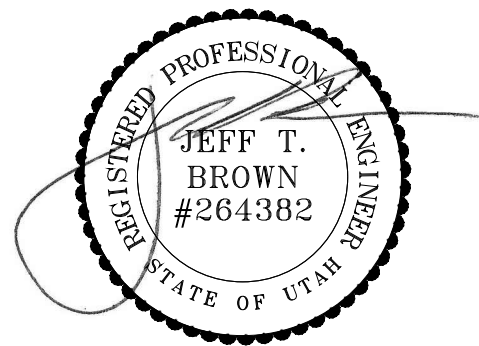

PERMIT SET

REV.	DATE	DESCRIPTION
-	-	-
-	-	-
-	-	-
-	-	-
-	-	-
A	01/19/2018	RELEASED FOR PERMIT

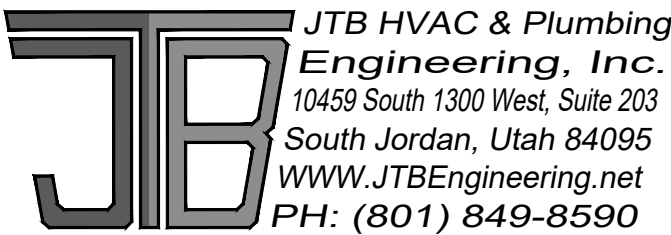

PROJECT NAME:
LA CAILLE- BANQUET
SUPPORT REMODEL

ADDRESS
9565 WASATCH BLVD
SANDY, UT 84092

DRAWING TITLE:
PLUMBING
DETAILS AND SCHEDULES

JOB NO.:	18.005	SHEET NUMBER
DATE:	01/19/2018	P701
DRAWN BY:	JTB	
SCALE:	NTS	