



STAMP

LA CAILLE - BANQUET SUPPORT REMODEL
9565 WASATCH BOULEVARD
SANDY, UTAH 84092

THESE DRAWINGS ARE INSTRUMENTS OF SERVICE AND SHALL REMAIN THE PROPERTY OF LUNA DESIGN STUDIO. NO USE OR RE-USE OF THESE DRAWINGS IS ALLOWED WITHOUT THE WRITTEN PERMISSION OF LUNA DESIGN STUDIO. UNLESS AUTHORIZED IN WRITING BY LUNA DESIGN STUDIO, ANY RE-USE OF THESE DRAWINGS IS PROHIBITED. COPYRIGHT © 2018

ISSUE DATE:	01-28-18	PERMIT SET
ISSUE DATE:		
ISSUE DATE:		
ISSUE DATE:		
ISSUE DATE:		
ISSUE DATE:		
ISSUE DATE:		
ISSUE DATE:		

LIGHTING
PLAN

DRAWING NO.:
E1.1

KEYED NOTES

1. PROVIDE A WALL MOUNT DUAL TECH TWO POLE OCC SENSOR FOR RESTROOM LIGHT AND FAN CONTROL. (SENSOR SWITCH #WSX PDT 2P OR EQUIVALENT).


GENERAL NOTES

- A. CONNECT ALL EMERGENCY AND EXIT LIGHT FIXTURES TO THE UNSWITCHED SIDE OF THE LIGHTING BRANCH CIRCUIT. LIGHT FIXTURES WITH EMERGENCY DRIVERS SHALL BE NORMALLY SWITCHED WITH THE AREA LIGHTING, BUT HAVE THEIR EMERGENCY DRIVERS CONNECTED AHEAD OF THE LIGHT SWITCH OR LIGHTING CONTROL PANEL. RELAY IT IS THE INTENT OF THE CONSTRUCTION DOCUMENTS THAT EMERGENCY LIGHTS SHALL BE INSTALLED IN ALL AREAS ABOVE CEILINGS CONCEALED WHERE POSSIBLE.
- B. COORDINATE MOUNTING HEIGHTS OF ALL PENDANT AND WALL MOUNTED LIGHT FIXTURES WITH ARCHITECTURAL ELEVATIONS.

LTG CTRL
SEQUENCE OF OPERATION

LIGHTING AND CONTROLS ARE DESIGNED TO MEET IECC 2015
OCCUPANCY SENSORS WILL CONTROL LIGHTING IN RESTROOMS, STORAGE, NEW RAMP AND LOCKER ROOMS.
OCCUPANCY SENSORS SHALL BE SET TO MANUAL ON / AUTOMATIC OFF EXCEPT IN RESTROOMS AND NEW RAMP.
NEW RAMP, AND LIGHTING IS EXEMPT FROM LIGHTING REDUCTION CONTROLS PER IECC 2015 C405.2

LIGHT FIXTURE SCHEDULE					
TYPE	MANUFACTURER	CATALOG NO.	VOLTAGE	LAMPING	CONTROL
DL1	LITHONIA	TCARAL 10LM 30K 90 FL MVOLT ZT	120	1000 LUM 3000K	RECESSED
ML1	LITHONIA	CLXL48 3000 LUM SEF WDL SCBA WD MVOLT G210 30K 80	120	3000 LUM 3000K	SURFACE
ML1E	SAME AS TYPE ML1 EXCEPT WITH EMERGENCY BATTERY.				
EM	LITHONIA	LQM S W 3 G 120/277 EL N	120	LED INCLD	N/A
					UNIV
					1

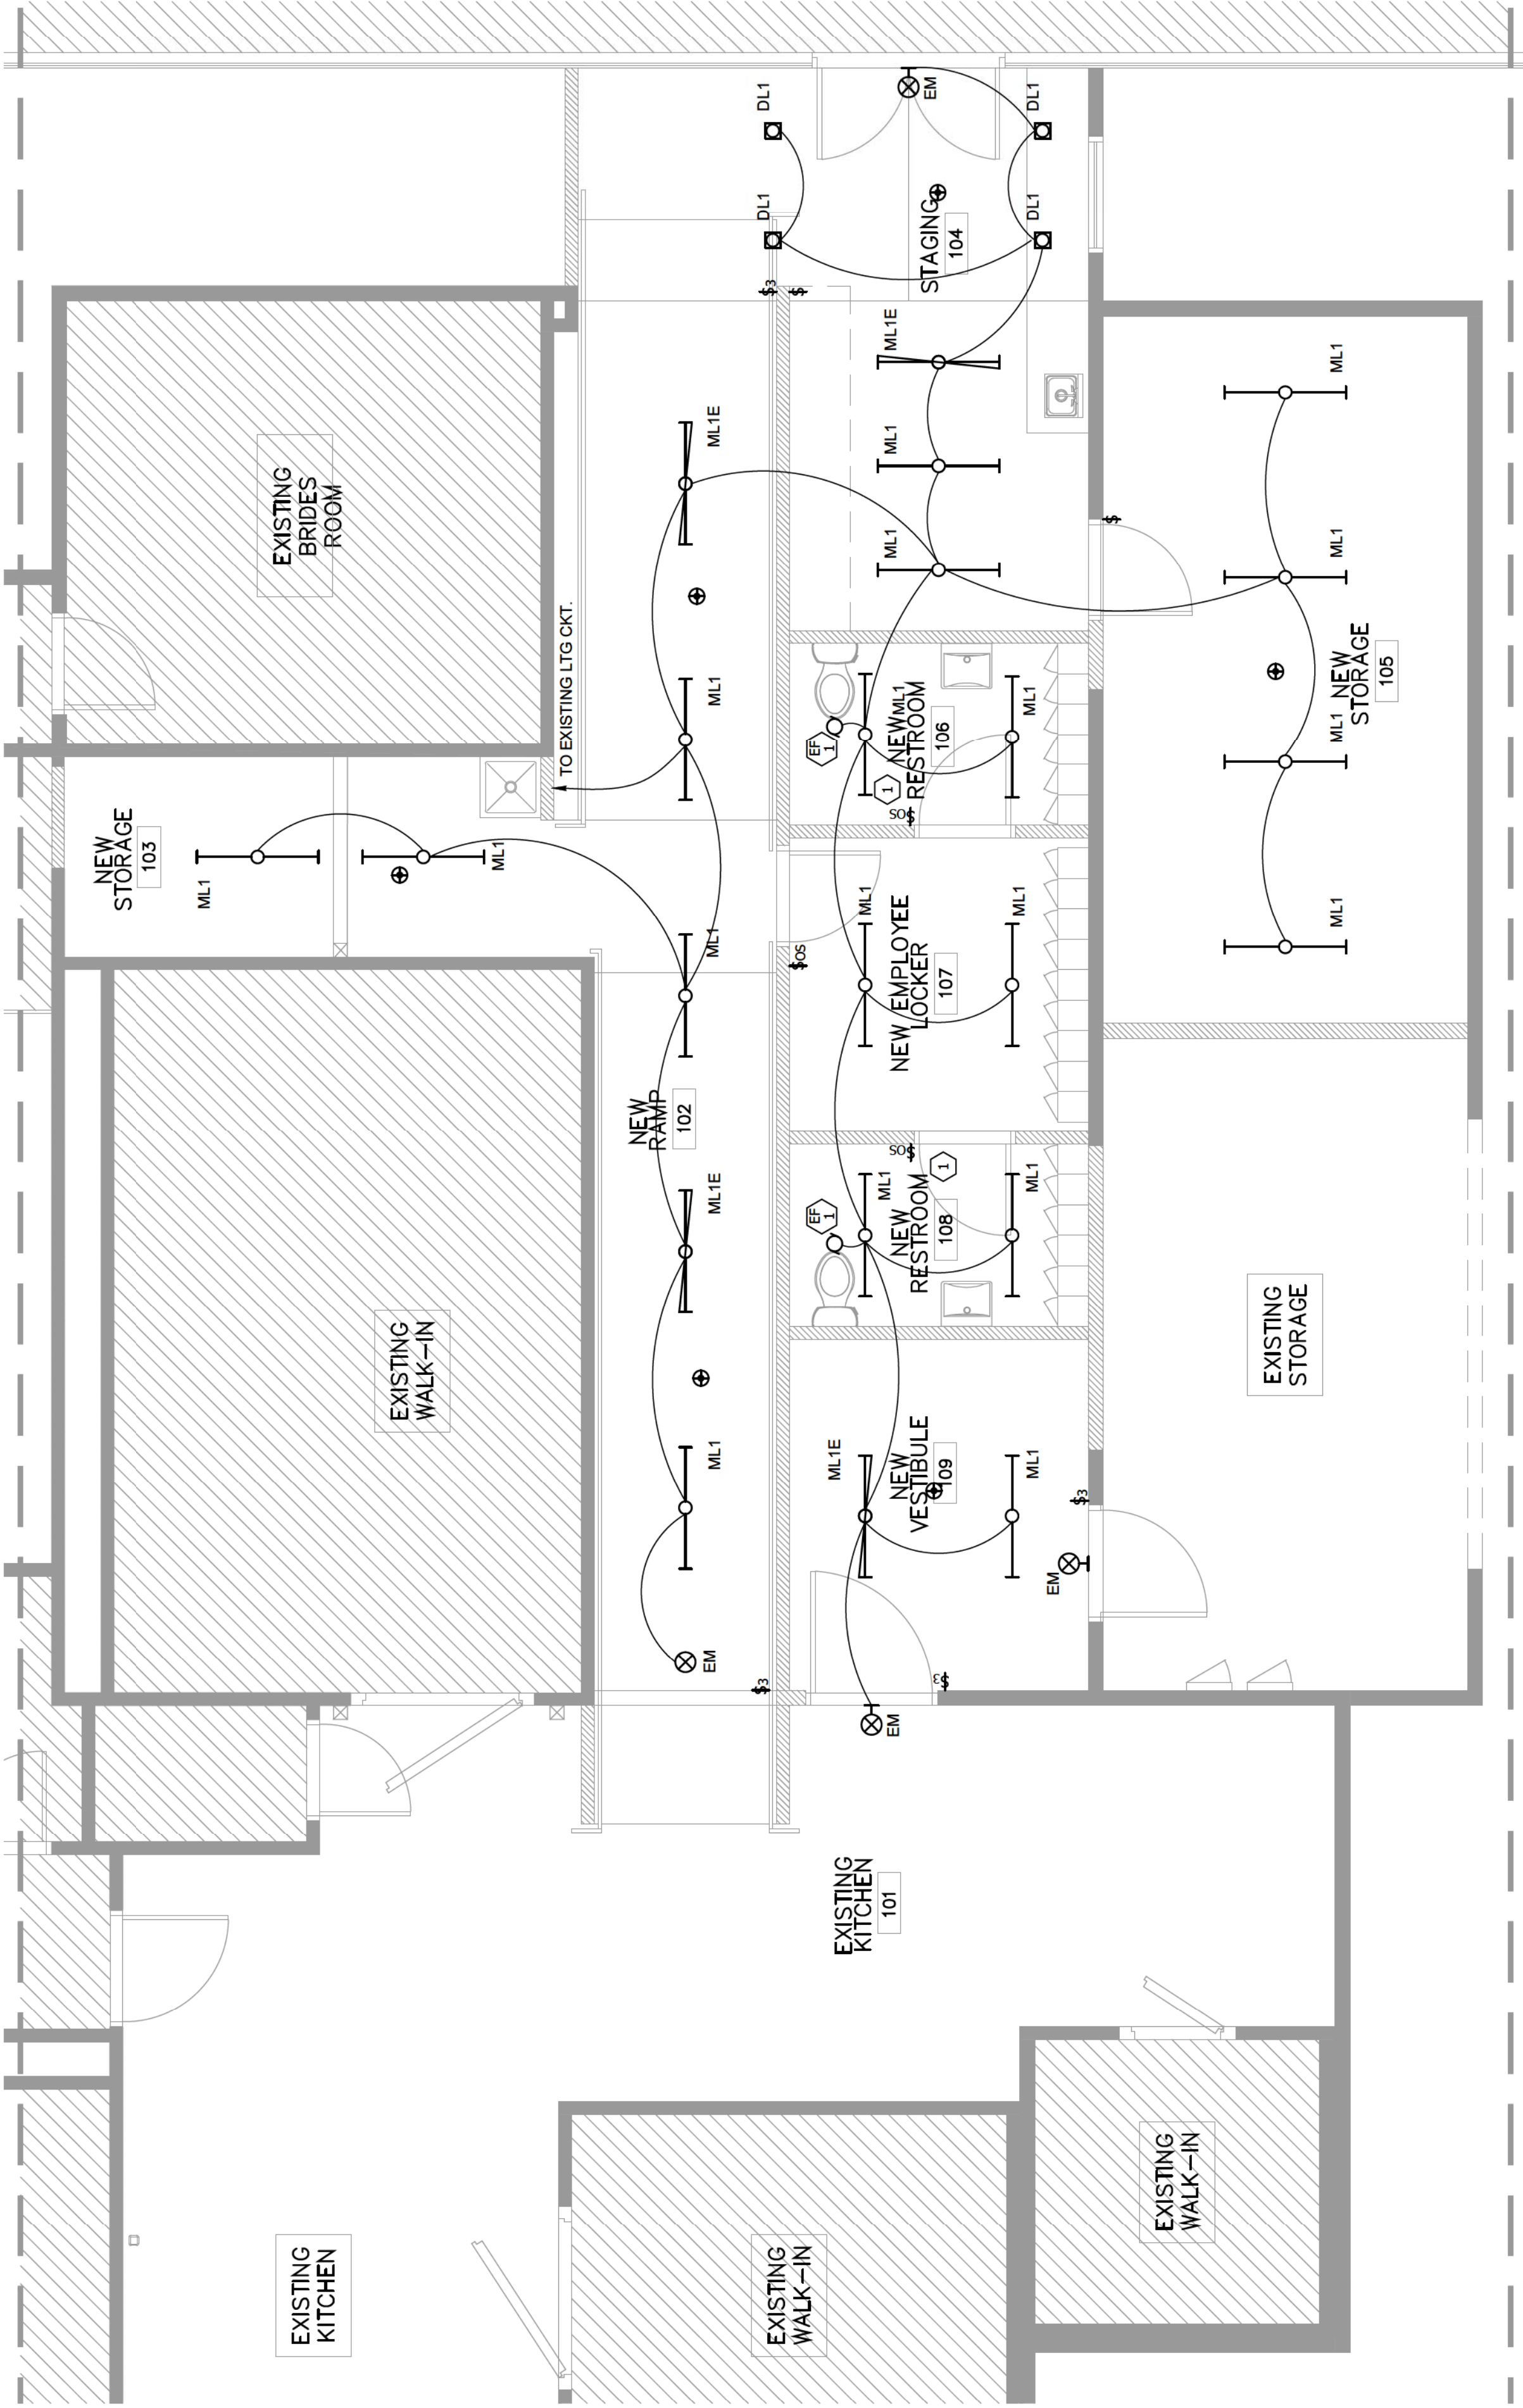

1
EL.1
LIGHTING PLAN
SCALE: 1/4" = 1'-0"